


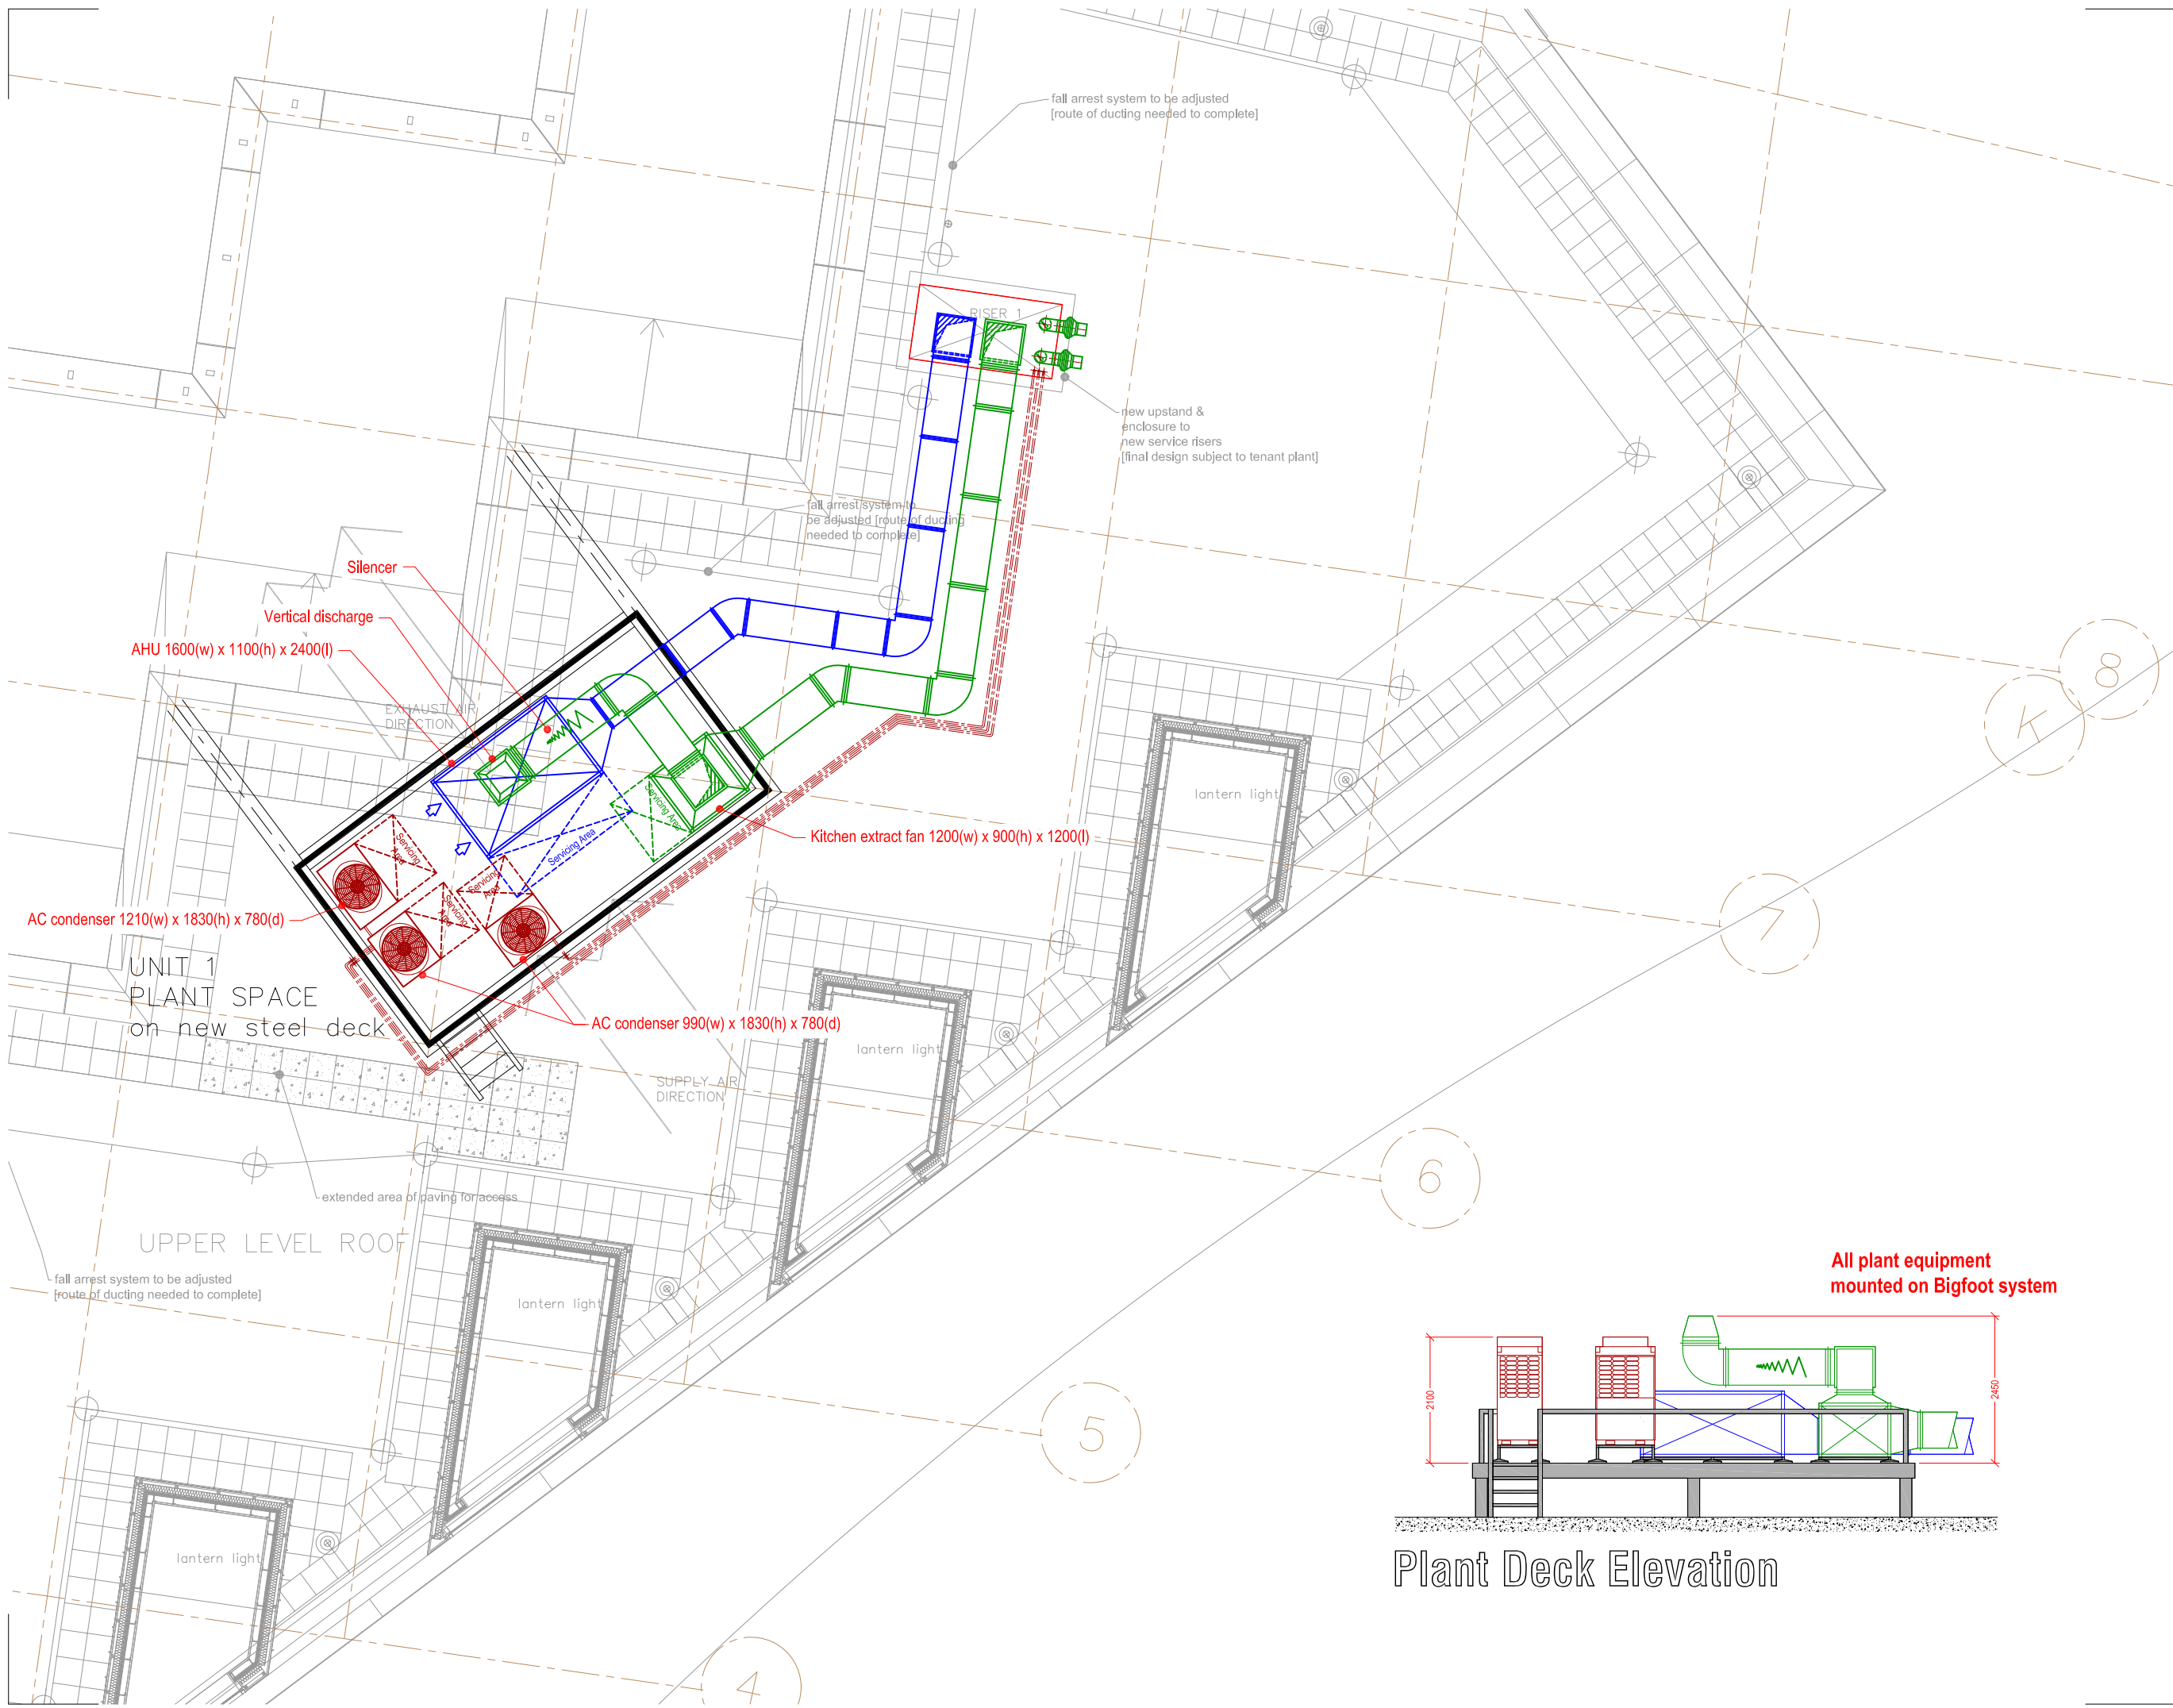

All plant equipment mounted on Bigfoot system

Plant Deck Elevation

No.	Date	Rev.	By	Revision Description
A	28-07-15	PR		Revised plant equipment layout.

Client: **wahaca**

Project: **Wahaca Liverpool**

Drawing Title: **Ventilation Layout Roof**

Drawing No:	Rev:
017-009-14	A

Scale: 1:50 @ A1 1:100 @ A3

Drawn By: PR Date: 17/06/15

chapman ventilation

15-20 Woodfield Road
Welwyn Garden City
Hertfordshire AL7 1JQ
Tel: 01707 372858 Fax: 01707 325001
E-mail: info@chapmanventilation.co.uk
Web: www.chapmanventilation.co.uk

Copyright of this drawing resides with Chapman Ventilation Limited

