


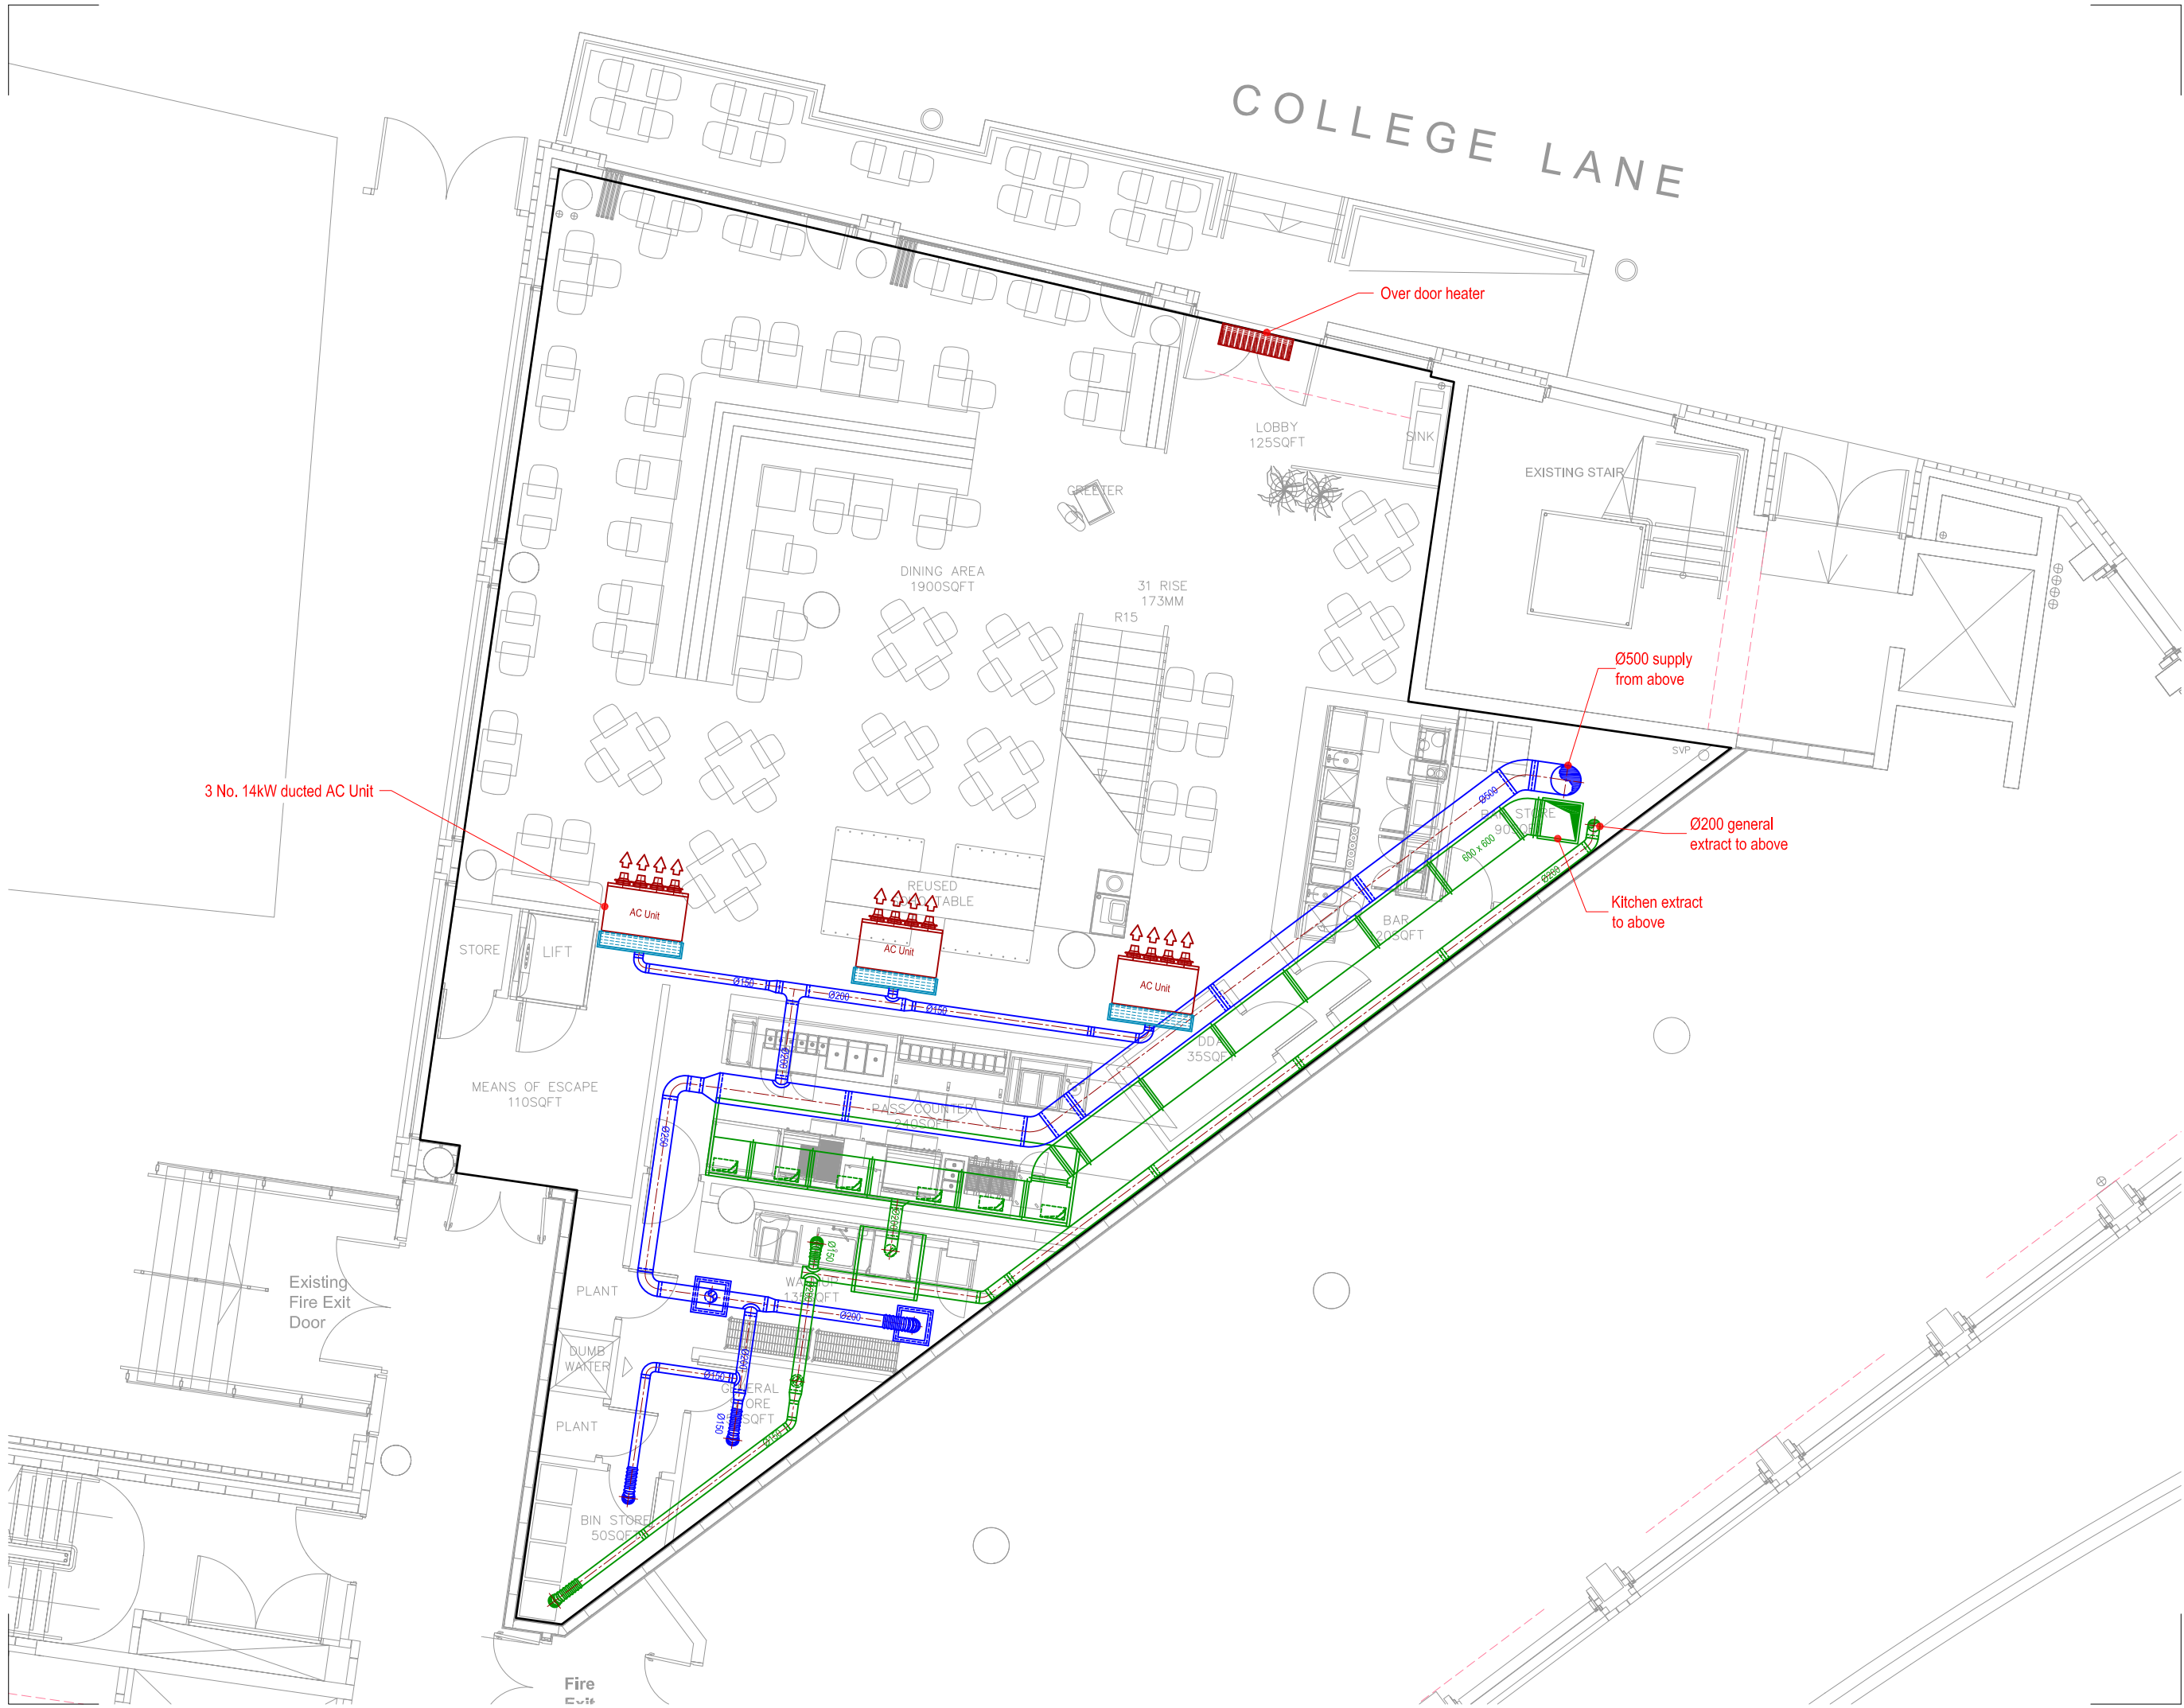

No.	Date	Rev. By	Revision Description
-----	------	---------	----------------------

Client: **wahaca**

Project: **Wahaca Liverpool**

Drawing Title: **Ventilation Layout Ground Floor**

Drawing No:	Rev:
017-009-01	-
Scale: 1:50 @ A1 1:100 @ A3	
Drawn By: PR	Date: 17/06/15

chapman ventilation
15-20 Woodfield Road
Walsby Garden City
Hertfordshire AL7 1JQ
Tel: 01707 372858 Fax: 01707 325001
E-mail: info@chapmanventilation.co.uk
Web: www.chapmanventilation.co.uk
Copyright of this drawing resides with Chapman Ventilation Limited

