


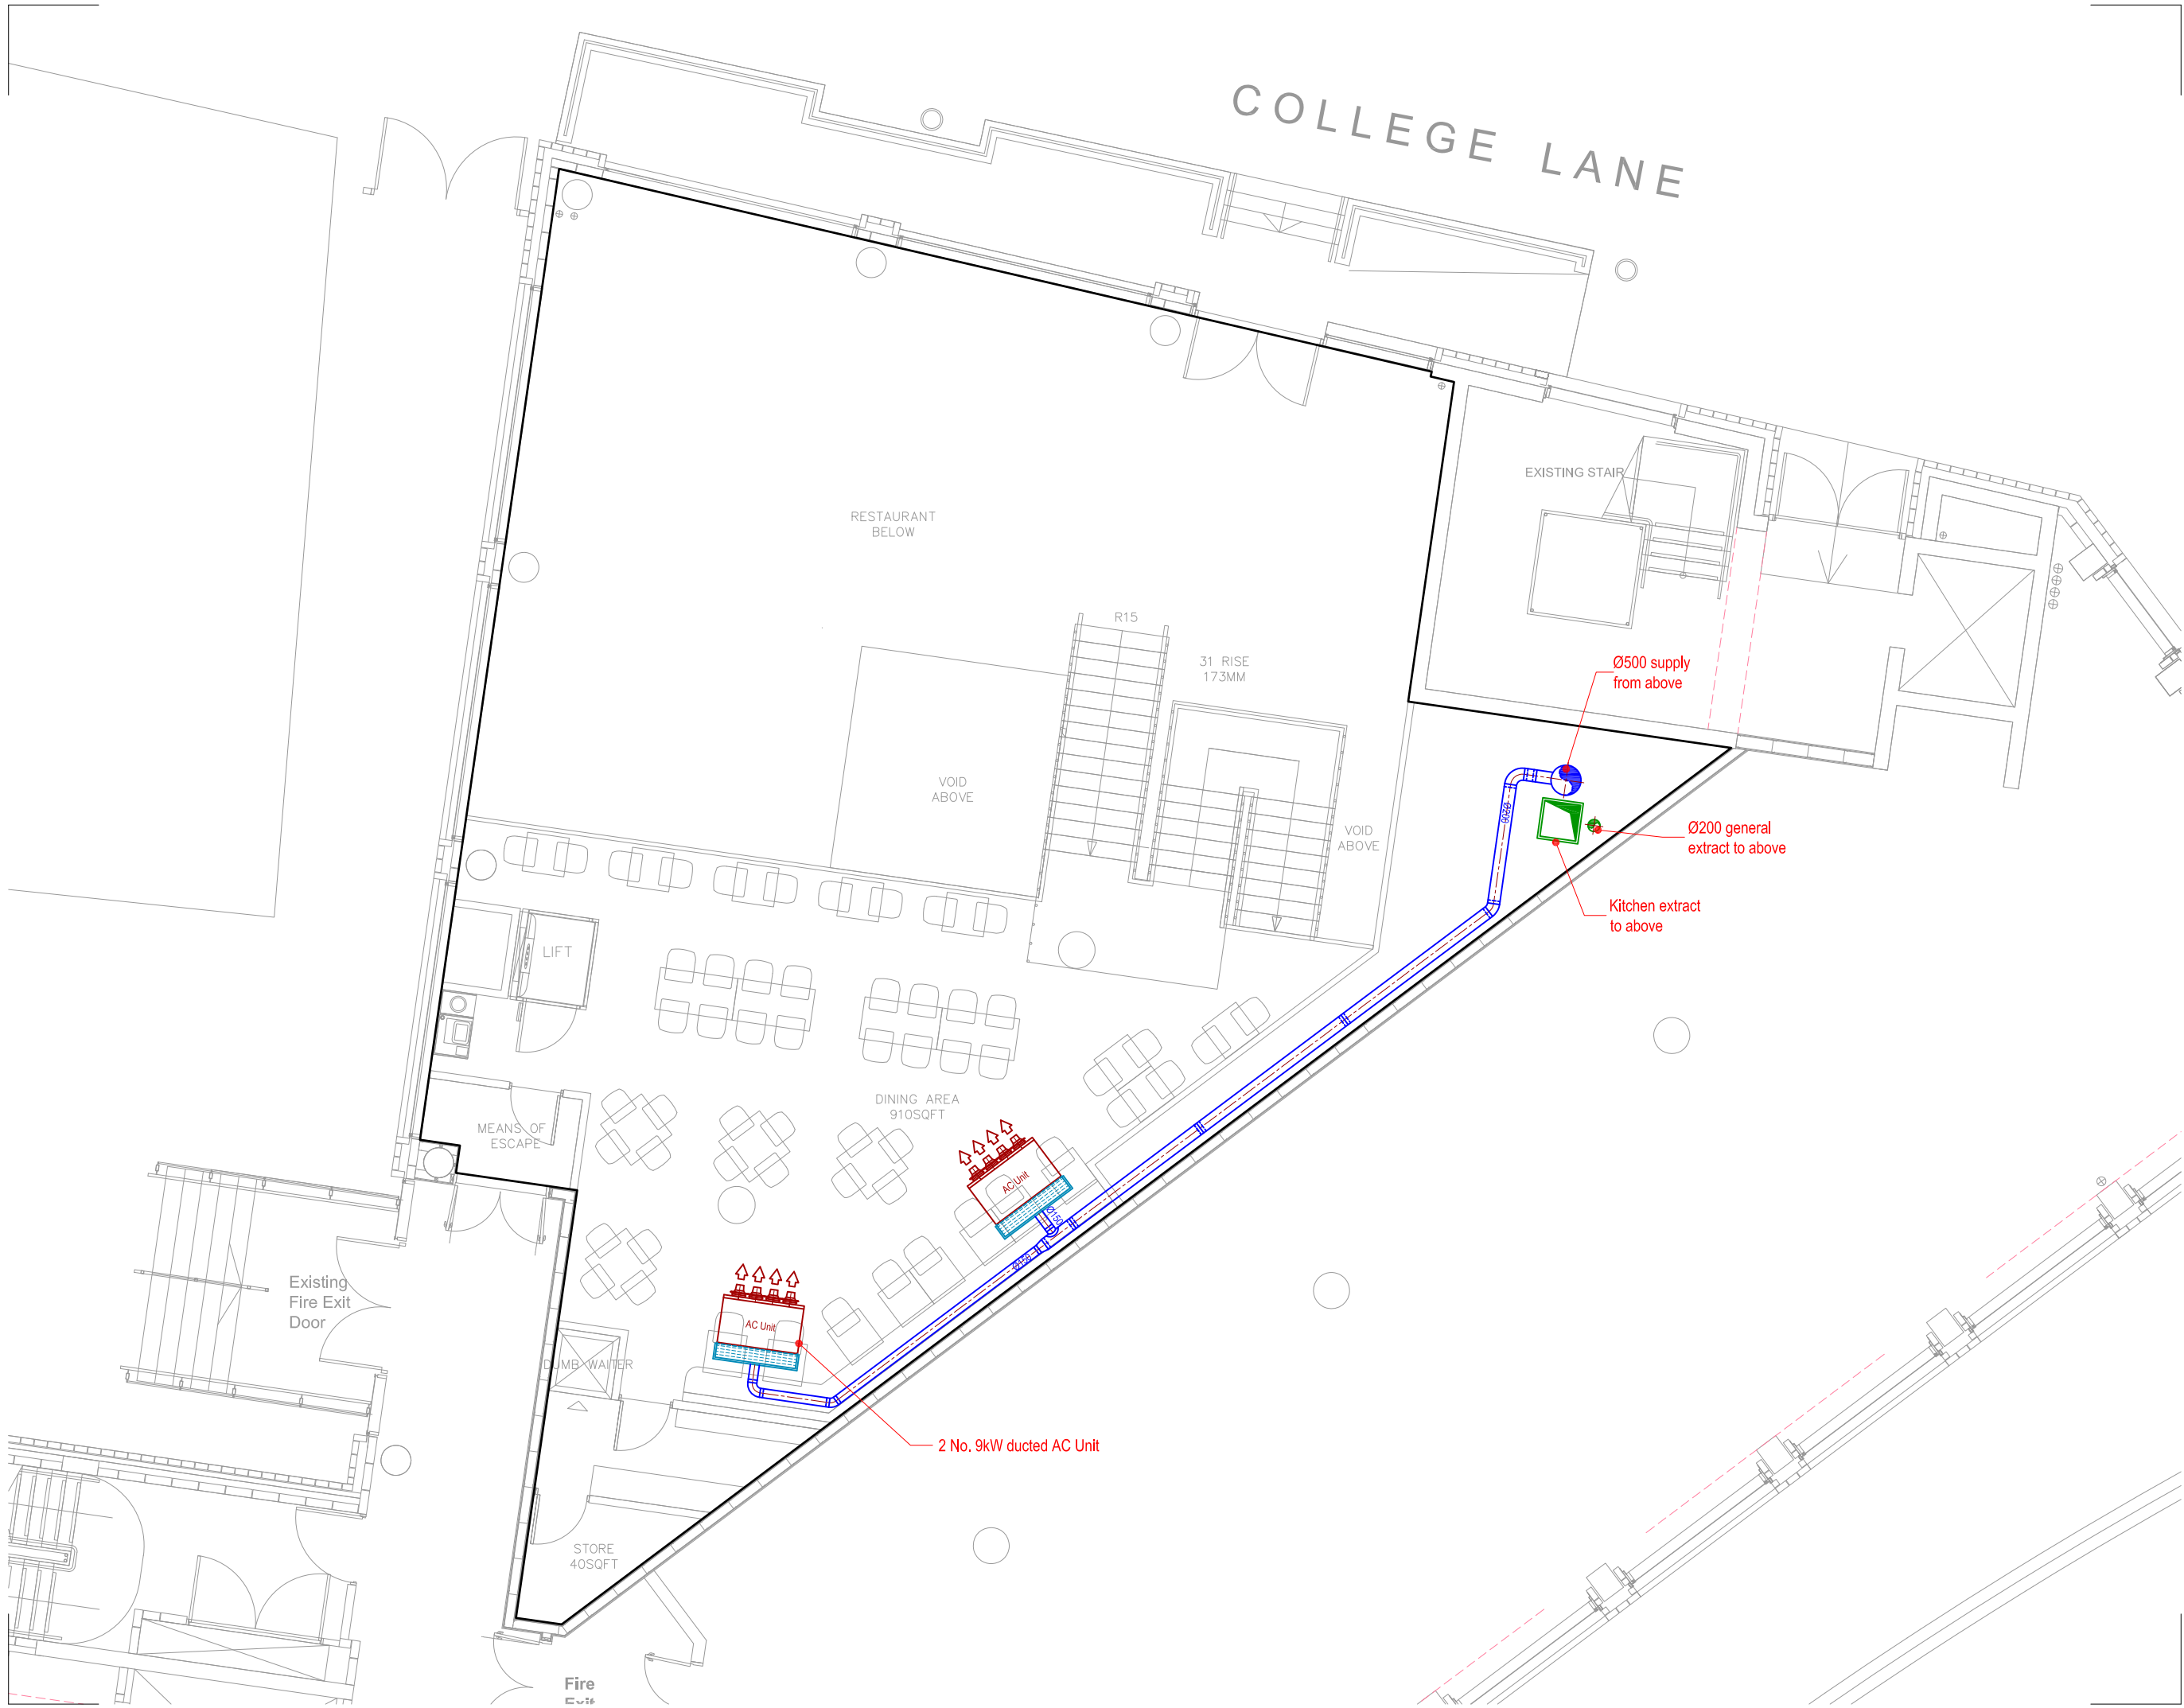

No.	Date	Rev. By	Revision Description

Client: **wahaca**

Project :
**Wahaca
Liverpool**

Drawing Title :
**Ventilation Layout
Mezzanine**

Drawing No:	Rev:
017-009-02	-
Scale: 1:50 @ A1 1:100 @ A3	
Drawn By: PR	Date: 17/06/15

**chapman
ventilation**
15-20 Woodfield Road
Wahyn Garden City
Hertfordshire AL7 1JQ
Tel: 01707 372858 Fax: 01707 325001
E-mail: info@chapmanventilation.co.uk
Web: www.chapmanventilation.co.uk
Copyright of this drawing resides
with Chapman Ventilation Limited

