



NOTES		
BS-1192:2007+A1:2015 Definitions		
Originator	MOU	Mouchel
System	01	Car Park Lighting
Location	01	Heron Eccles
Type	DR	Drawing
Role	E	Electrical

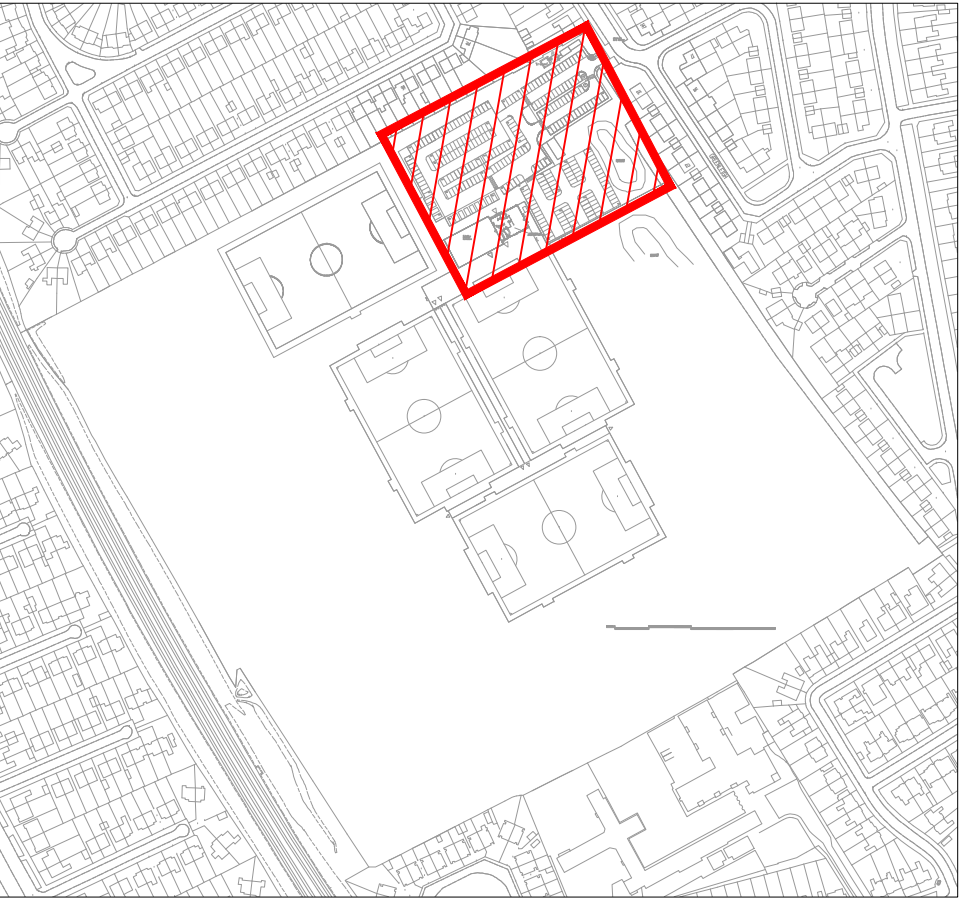

SCOPE OF WORKS NTS

LUMINAIRE SCHEDULE

Symbol	Label	Qty	Catalog Number	Description	Lamp
	A2	9	DSX1.L114.FW	DSX Luminaire - 13088 LUMENS @ 6 MTRS	NICHIA 219 4000K

STATISTICS

Description	Symbol	Avg	Max	Min	Min/Avg
Carpark	+	24 lux	71 lux	5 lux	0.21
Overspill	+	1 lux	10 lux	0 lux	0.00



T02	UPDATED TO SUIT REVISED PLAN		05.07.16 MAG	05.07.16 MG	05.07.16 SH
T01	ISSUED FOR PLANNING		29.02.16 MGD	29.02.16 MG	29.02.16 SH
Version	Amendment		Drawn & Date	Checked & Date	Approved & Date
<div> building great relationships</div>					
Issuing Office Exchange Station Liverpool			Telephone 0151 600 5500		
E-mail mark.gardiner@mouchel.com					
Internal Project Number 1070311-060-001					
Client Liverpool City Council					
Project Name Heron Eccles Playing Fields					
Drawing Title Proposed Car Park Lighting Scheme					
Scale 1:400	Original Size A1		Purpose of Issue Planning Application		
Date of First Issue 29.02.16	Author MGD	Checked MG	Approved SH		Status S4
1070311-MOU-01-01-DR-E-0001					Revision T02
Project	Originator	System/Level	Type	Issue Number	