



NOTES		
BS-1192:2007+A1:2015 Definitions		
Originator	MOU	Mouchel
System	01	Car Park Lighting
Location	03	Jerricho Lane
Type	DR	Drawing
Role	E	Electrical

LUMINAIRE SCHEDULE					
Symbol	Label	Qty	Catalog Number	Description	Lamp
	A	1	DSX1.L114.AY	DSX Luminaire - 13266.6 LUMENS	NICHIA 219 4000K
	B	1	DSX1.L114.FW	DSX Luminaire - 13088 LUMENS	NICHIA 219 4000K
	B2	5	DSX1.L114.FW	DSX Luminaire - 13088 LUMENS	NICHIA 219 4000K

STATISTICS					
Description	Symbol	Avg	Max	Min	Min/Avg
Carpark		23 lux	63 lux	7 lux	0.30
Overspill		1 lux	12 lux	0 lux	0.00

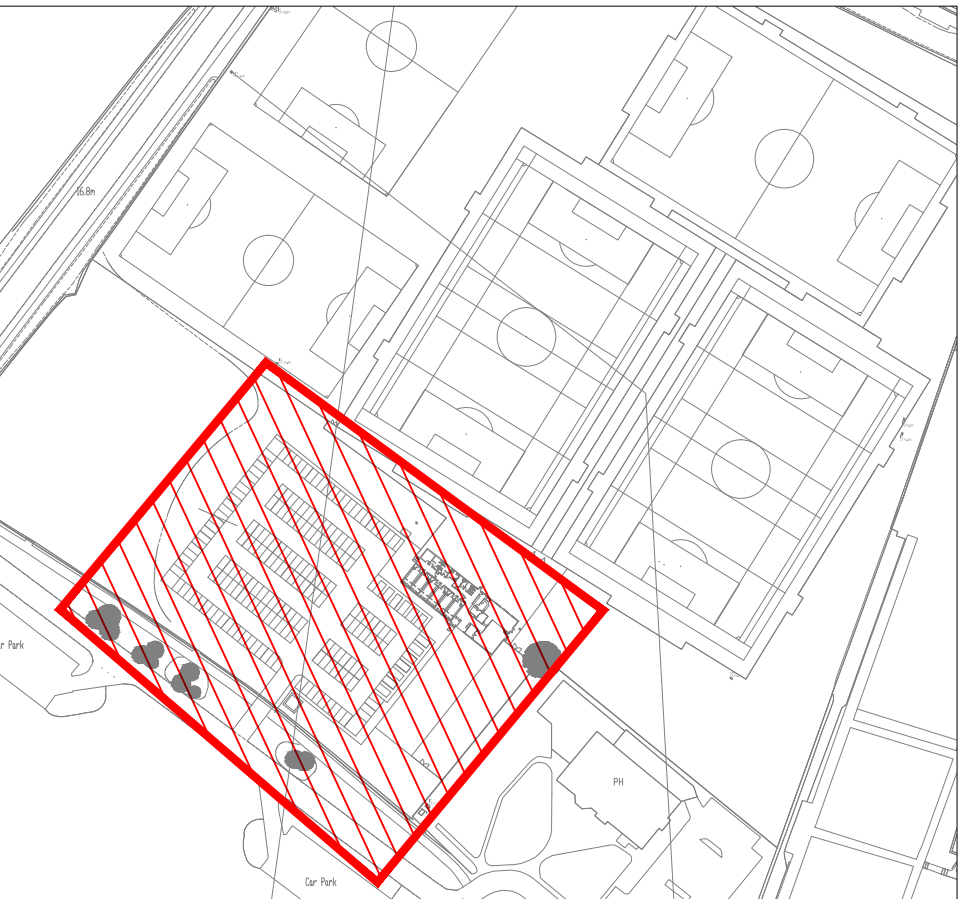

SCOPE OF WORKS NTS

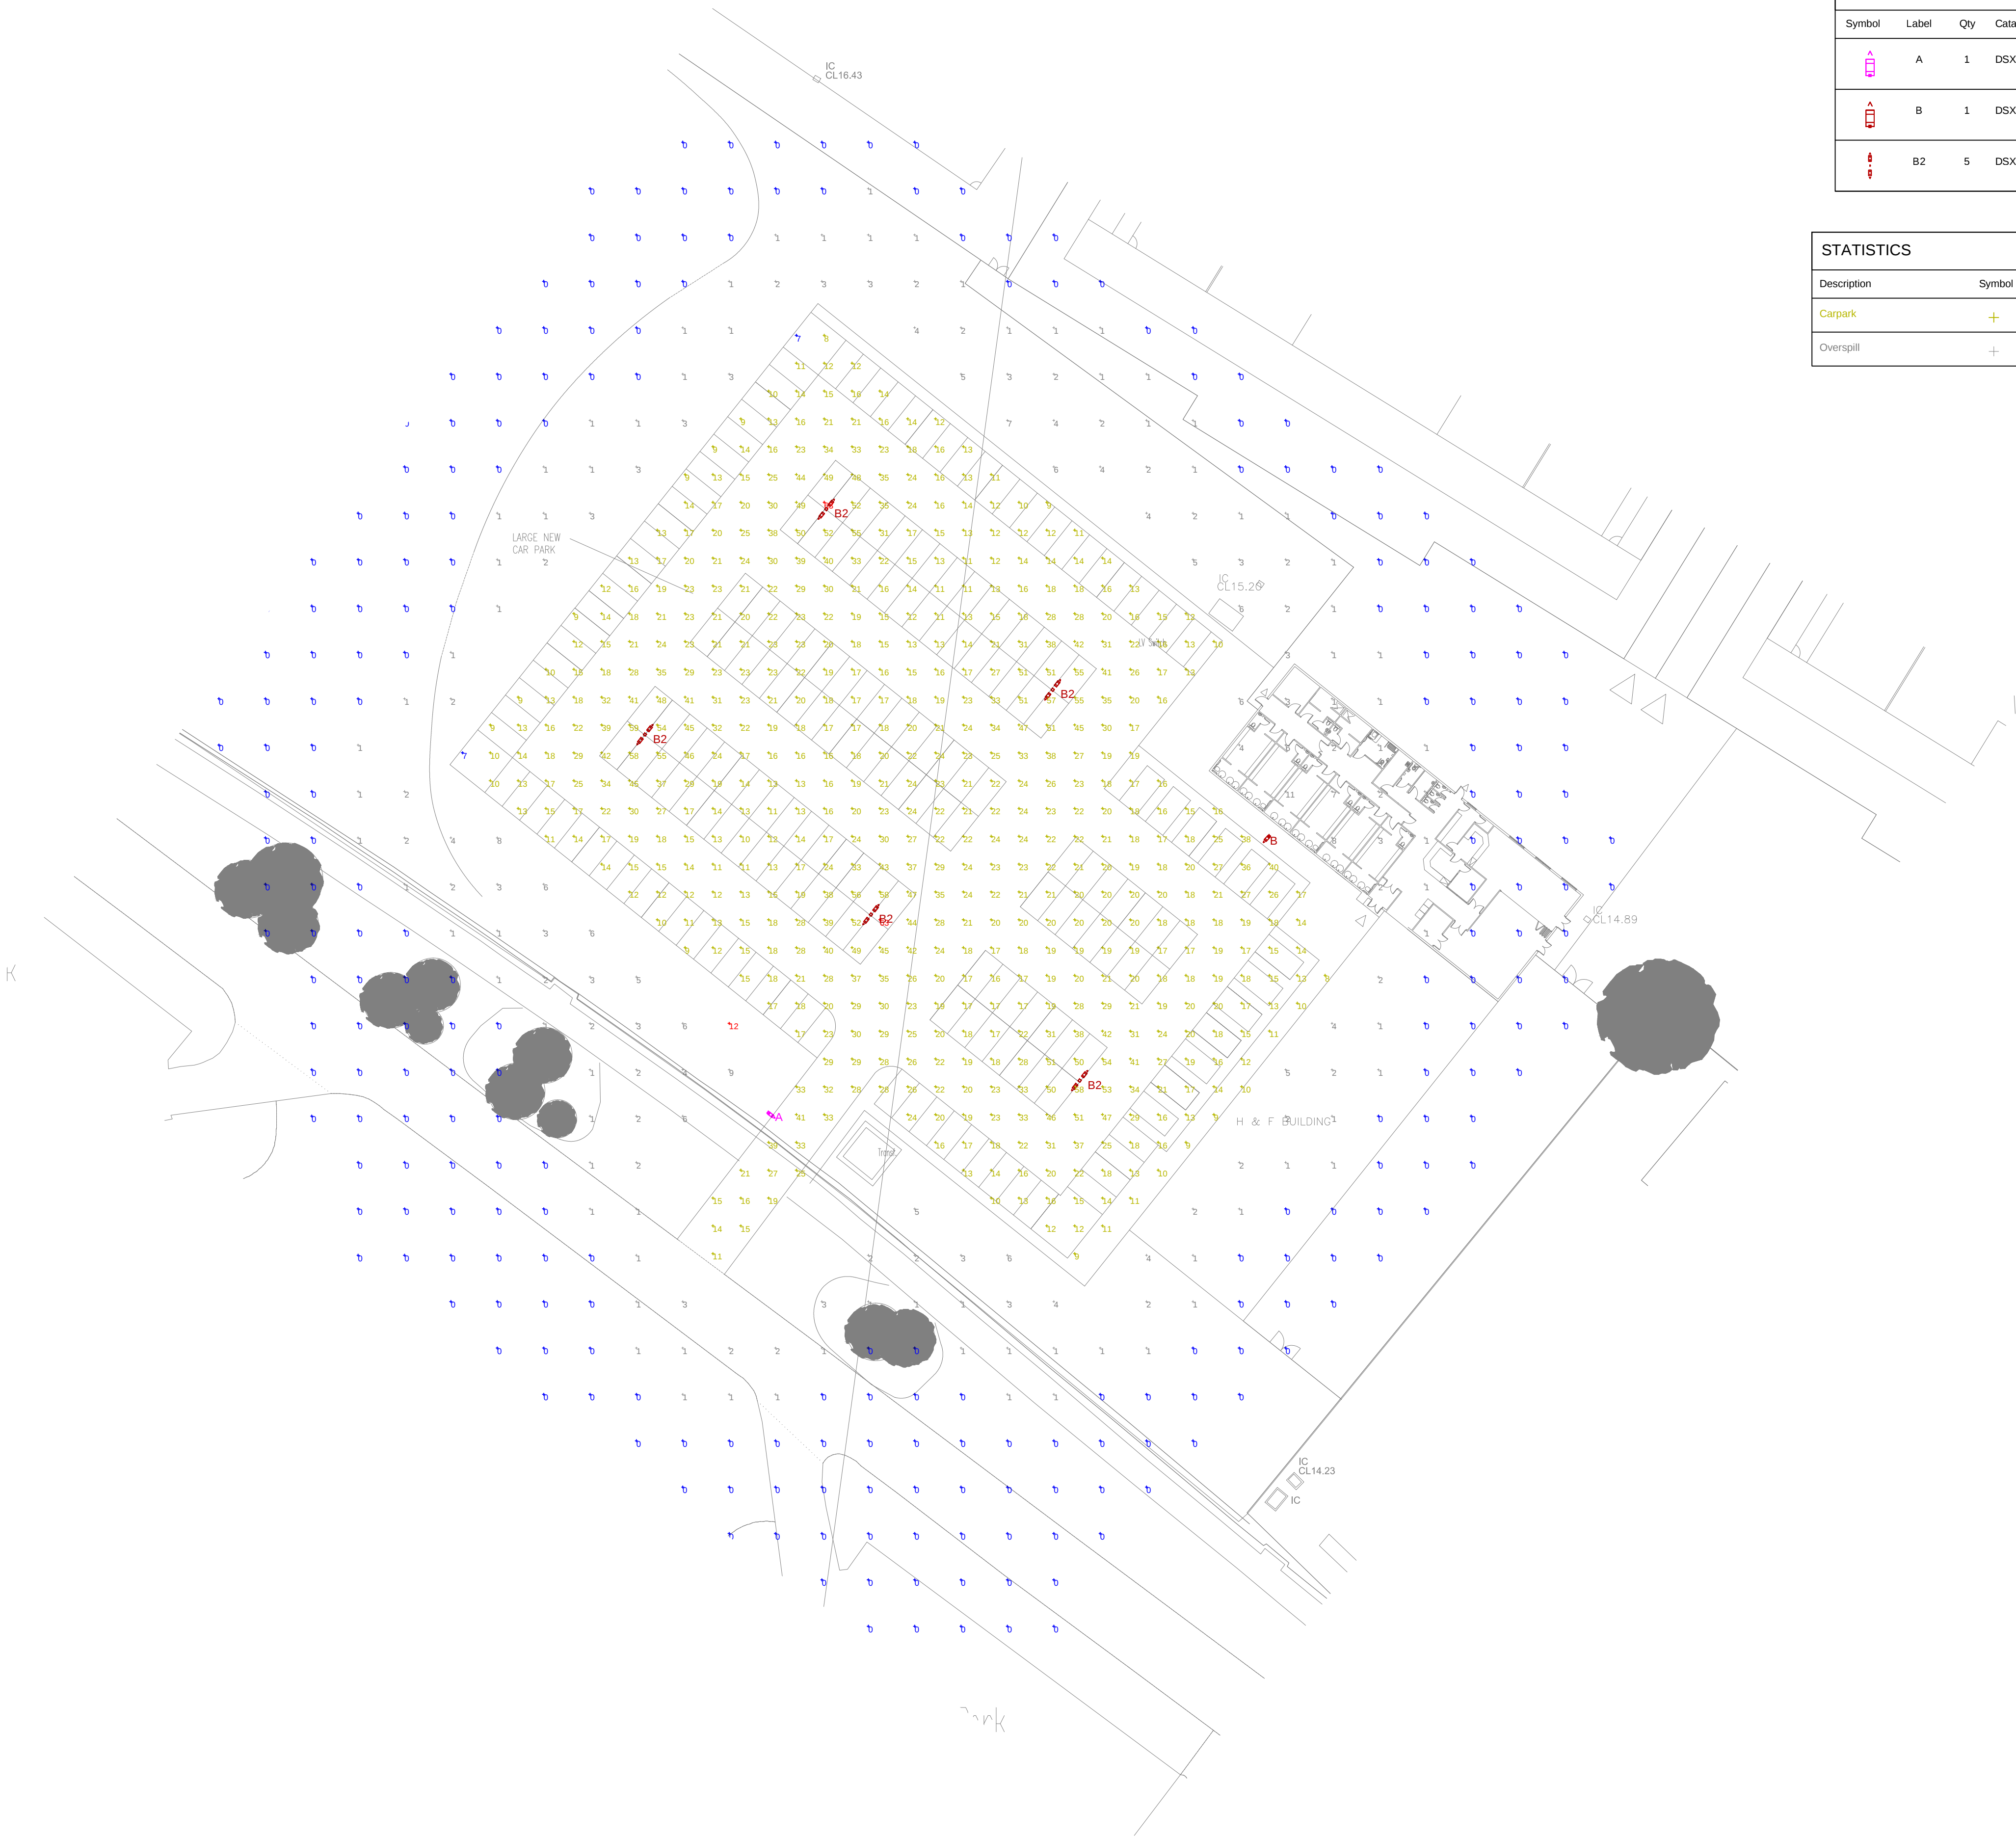

T01	ISSUED FOR PLANNING		29.02.16 MGD	29.02.16 MG	29.02.16 SH
Version	Amendment		Drawn & Date	Checked & Date	Approved & Date
 building great relationships					
Issuing Office Exchange Station Liverpool			Telephone 0151 600 5500		
E-mail mark.gardiner@mouchel.com					
Internal Project Number 1070311-060-001					
Client Liverpool City Council					
Project Name Jerricho Lane Playing Fields					
Drawing Title Proposed Car Park Lighting Scheme					
Scale 1:400	Original Size A1	Purpose of Issue Planning Application			
Date of First Issue 29.02.16	Author MGD	Checked MG	Approved SH	Status S4	
1070311-MOU-01-03-DR-E-0001					Revision T01
Project	Originator	System	Level	Type	Issue Number