

LEGEND


-  VENT AXIA MULTI-VENT MDO-CMS FAN.
-  1500 EXTRACT GRILLE. (FIRE RATED WITH INTUMESCENT CORE)
-  EXTRACT DUCT.
-  NON-RETURN DAMPER
-  SMOKE DAMPER

NOTE

1. SMOKE DAMPER CONTROL PANEL TO BE LOCATED IN RECEPTION AREA ON GROUND FLOOR.
2. ALL SMOKE DAMPERS IN COMMUNAL AREAS TO BE LINKED TO MAIN PANEL.

* SMOKE DAMPERS MARKED AS THIS ARE TO BE CONFIRMED WHETHER FIRE DAMPERS ARE ACCEPTABLE AT TENDER STAGE SMOKE DAMPERS TO BE ALLOWED AND LINKED IN TO APARTMENT FIRE ALARM PANEL

600 X 400 EXHAUST DUCT TO TERMINATE AT ROOF LEVEL WITH COWL CW BRD GUARD. RISING DUCT TO LOCATE DAMPERS WITHIN THE FLOOR AT EVERY LEVEL.

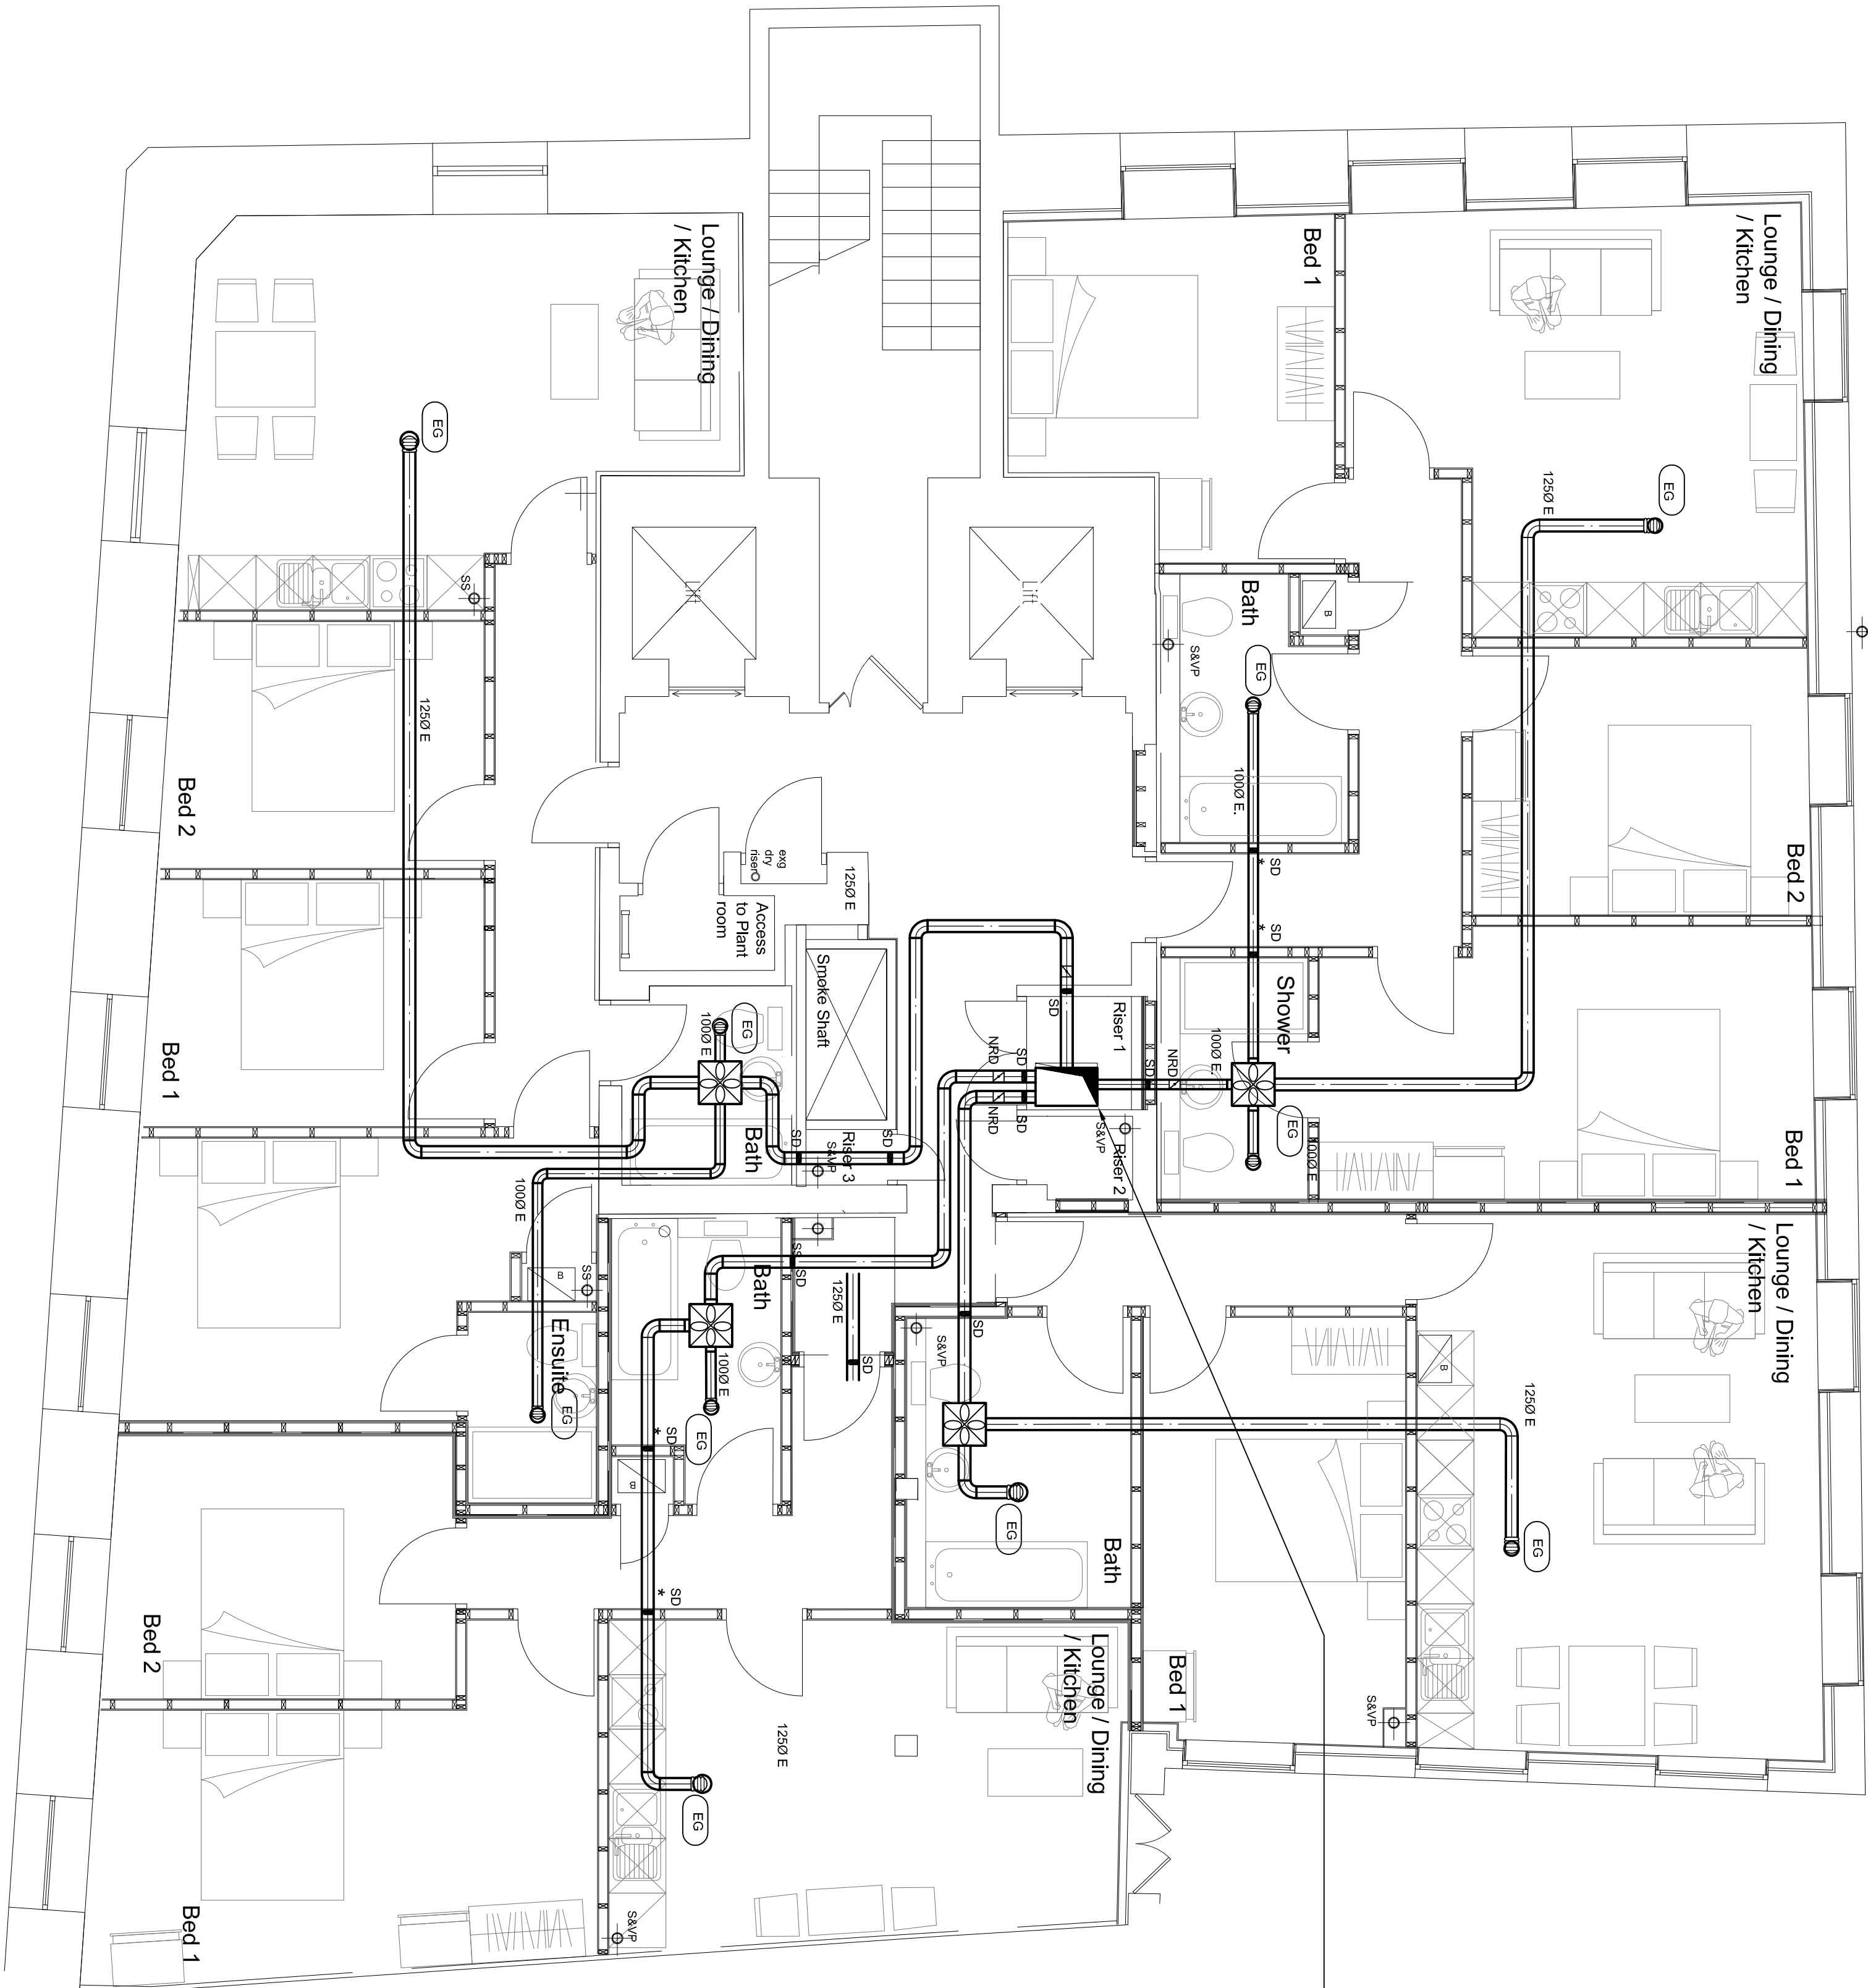

Proposed 7th floor plan @ 1:50

0 0.5 1 2 3 4 5

Rev.	Description	Date
T1	TENDER ISSUE	18.09.15

Rev.	Description	Date
T1	TENDER ISSUE	18.09.15

PROGRESSIVE SERVICES	27 Argyle Street Glasgow G3 7JF
CHARTERED	0141 247 9927
DESIGN LTD	01753 647069
	Email: sales@psd.co.uk

Client:	DAMIAN SILVERBECK
Project:	CITRUS HOUSE LIVERPOOL

Drawn:	P.J.	Checked:	C.F.
Scale:	1:50 (A1)	Date:	April 2015
Title:	7th Floor Typical Ventilation Layout		

Drawing Number:	15-1301-M11	Rev:	T1
-----------------	-------------	------	----