


- LL Wall-Mounted Lighting  
Product: Delphi w/ Wall Attachment  
Total Units: 0 (phase 2 only)
- LC Linear In-Ground Lighting  
Product: Linealuce  
Total Units: 6
- LC Lighting Column  
Product: Delphi on 8m Column w/ Linear Arm  
Total Units: 8
- GL In-Ground Up-Lighter  
Product: Light Up - Earth  
Total Units: 4
- CL Catenary Lighting  
Product: Argo Span-Wire Installation  
Total Units: 6
- LLM Linear In-Ground Lighting  
Product: Linealuce mini  
Total Units: 14
- (final details to be agreed with LCC highway and lighting to adoptable standard)

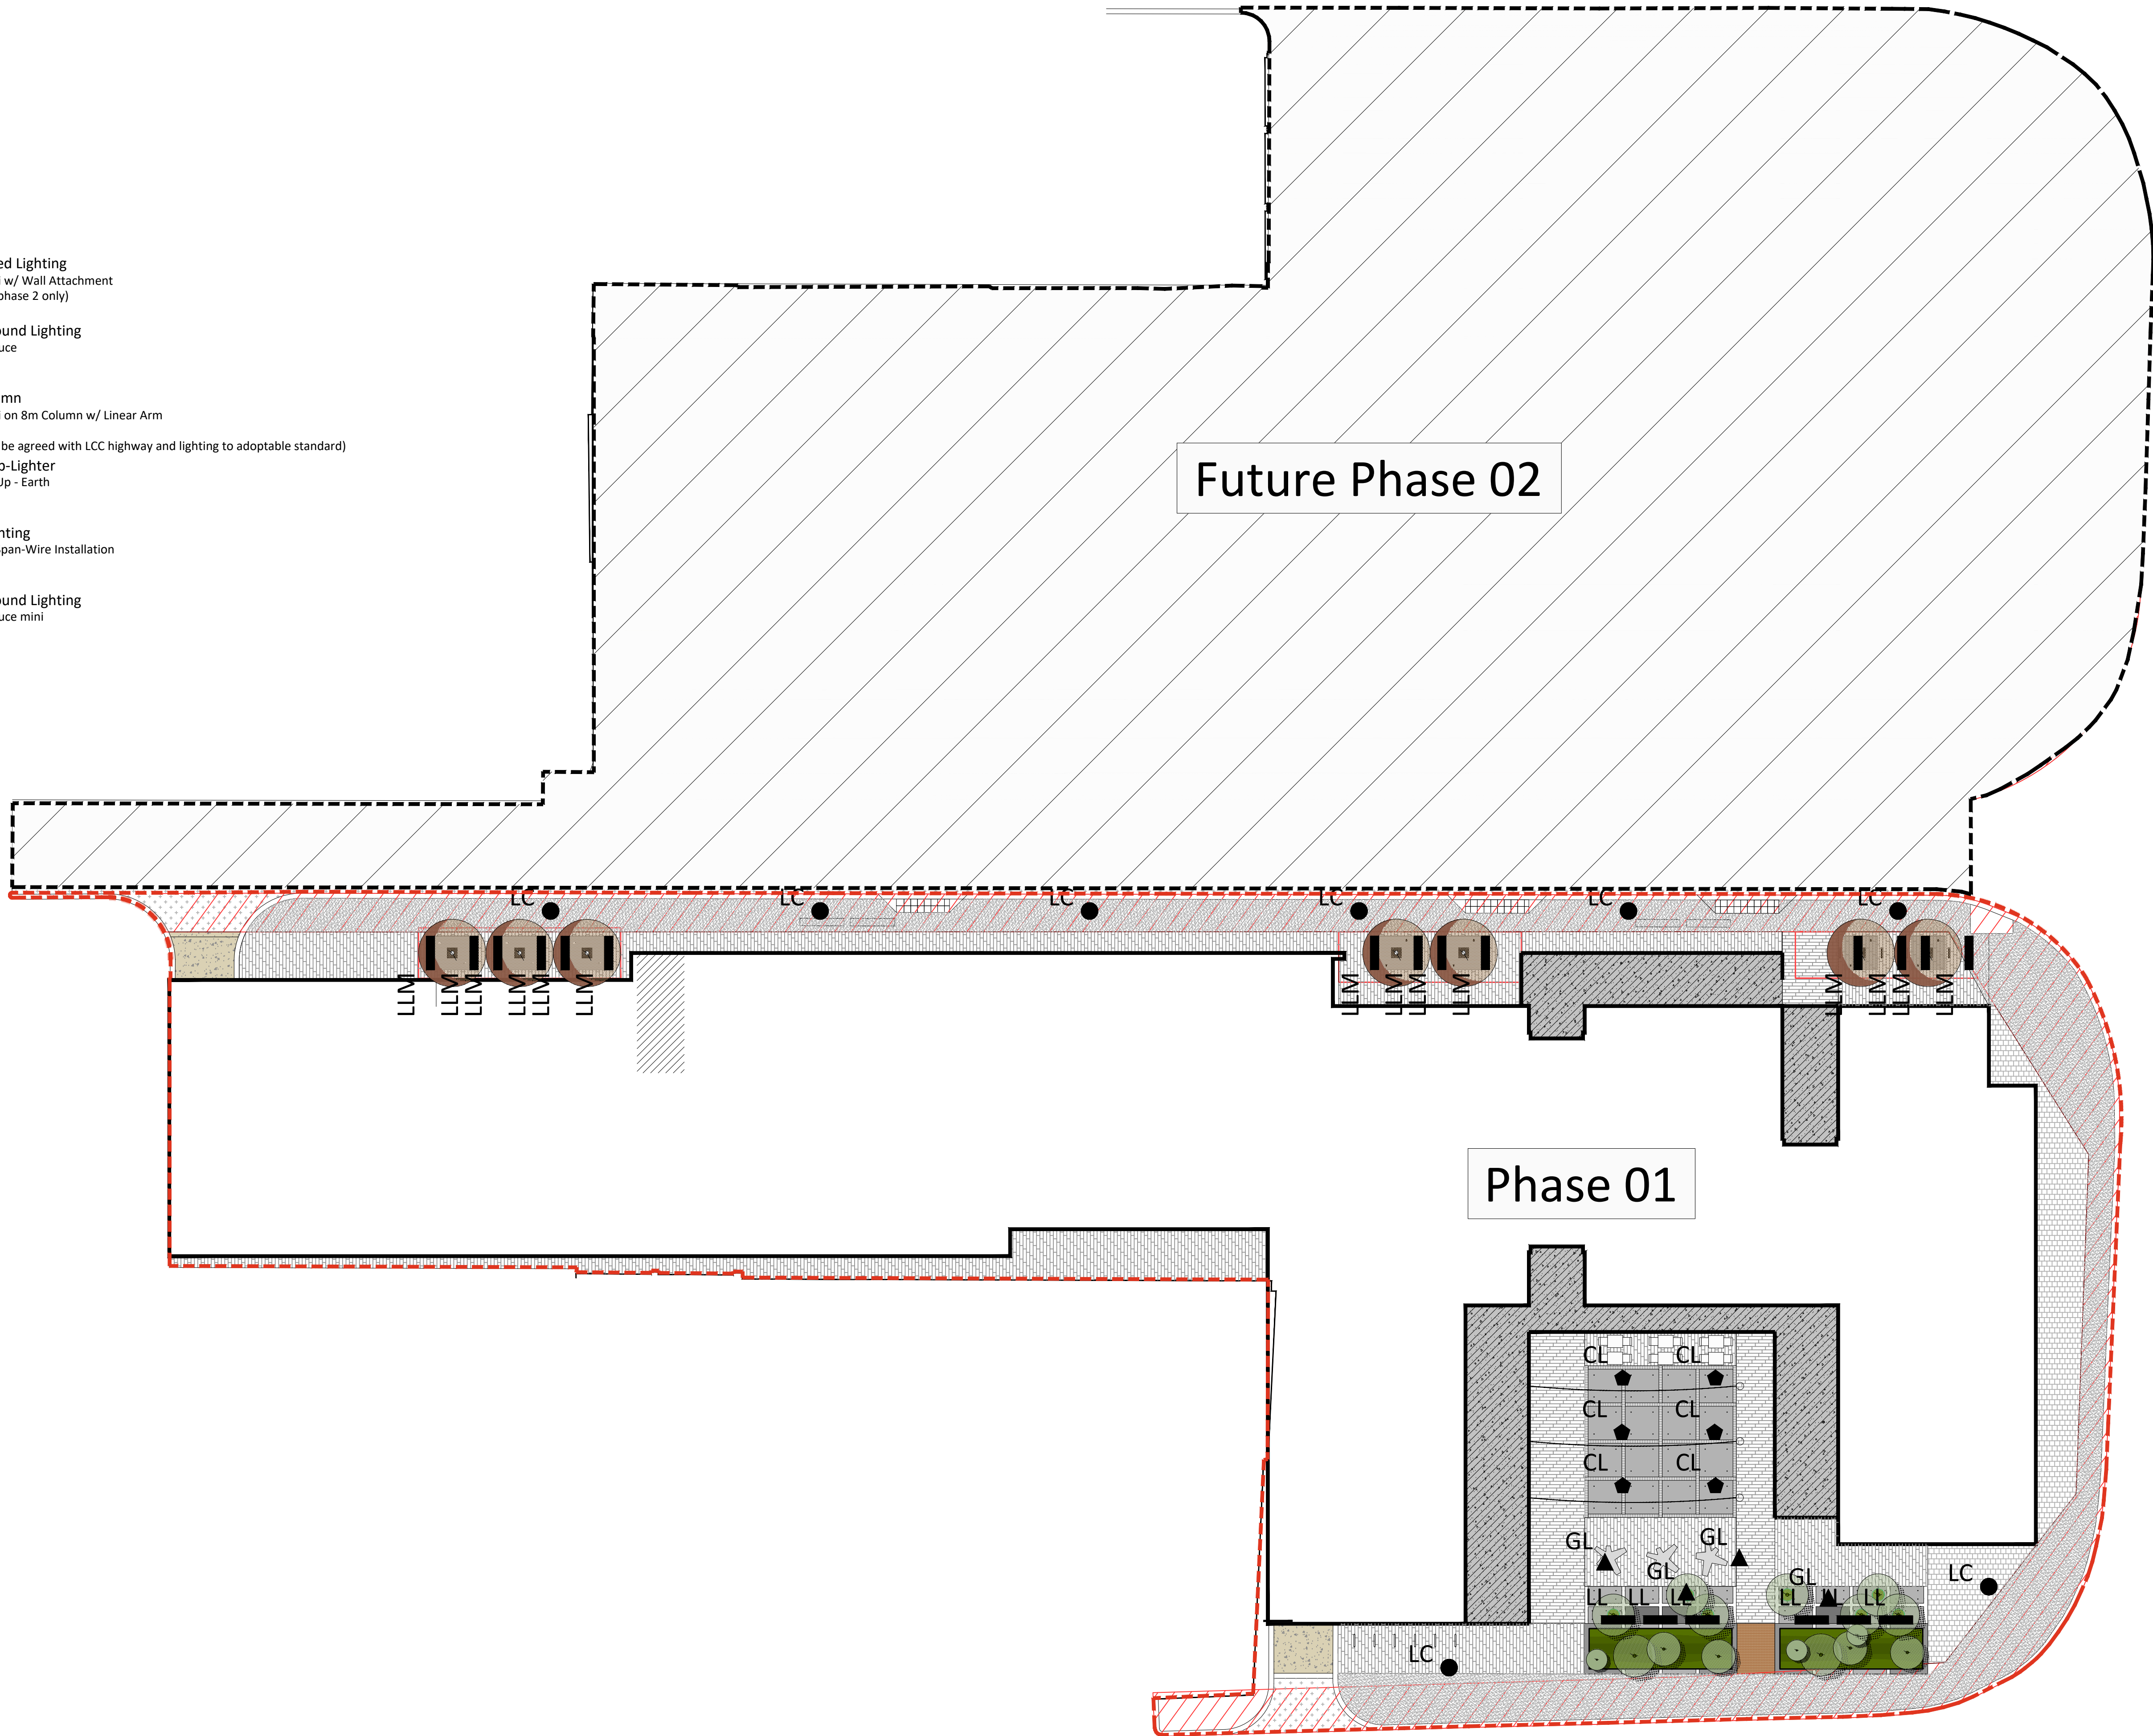

PLANNING

Client	Smith Young Architecture Ltd.	Scale	1:200 @ A1	Created by	KG	Last edited by	MITCHELL.C	Date	March 2018
Job title	Naylor Street	Project number	17.543	Drawing number	200	Issue	P 4	Checked	AT
Drawing title	External Lighting Plan - Phase 01								