
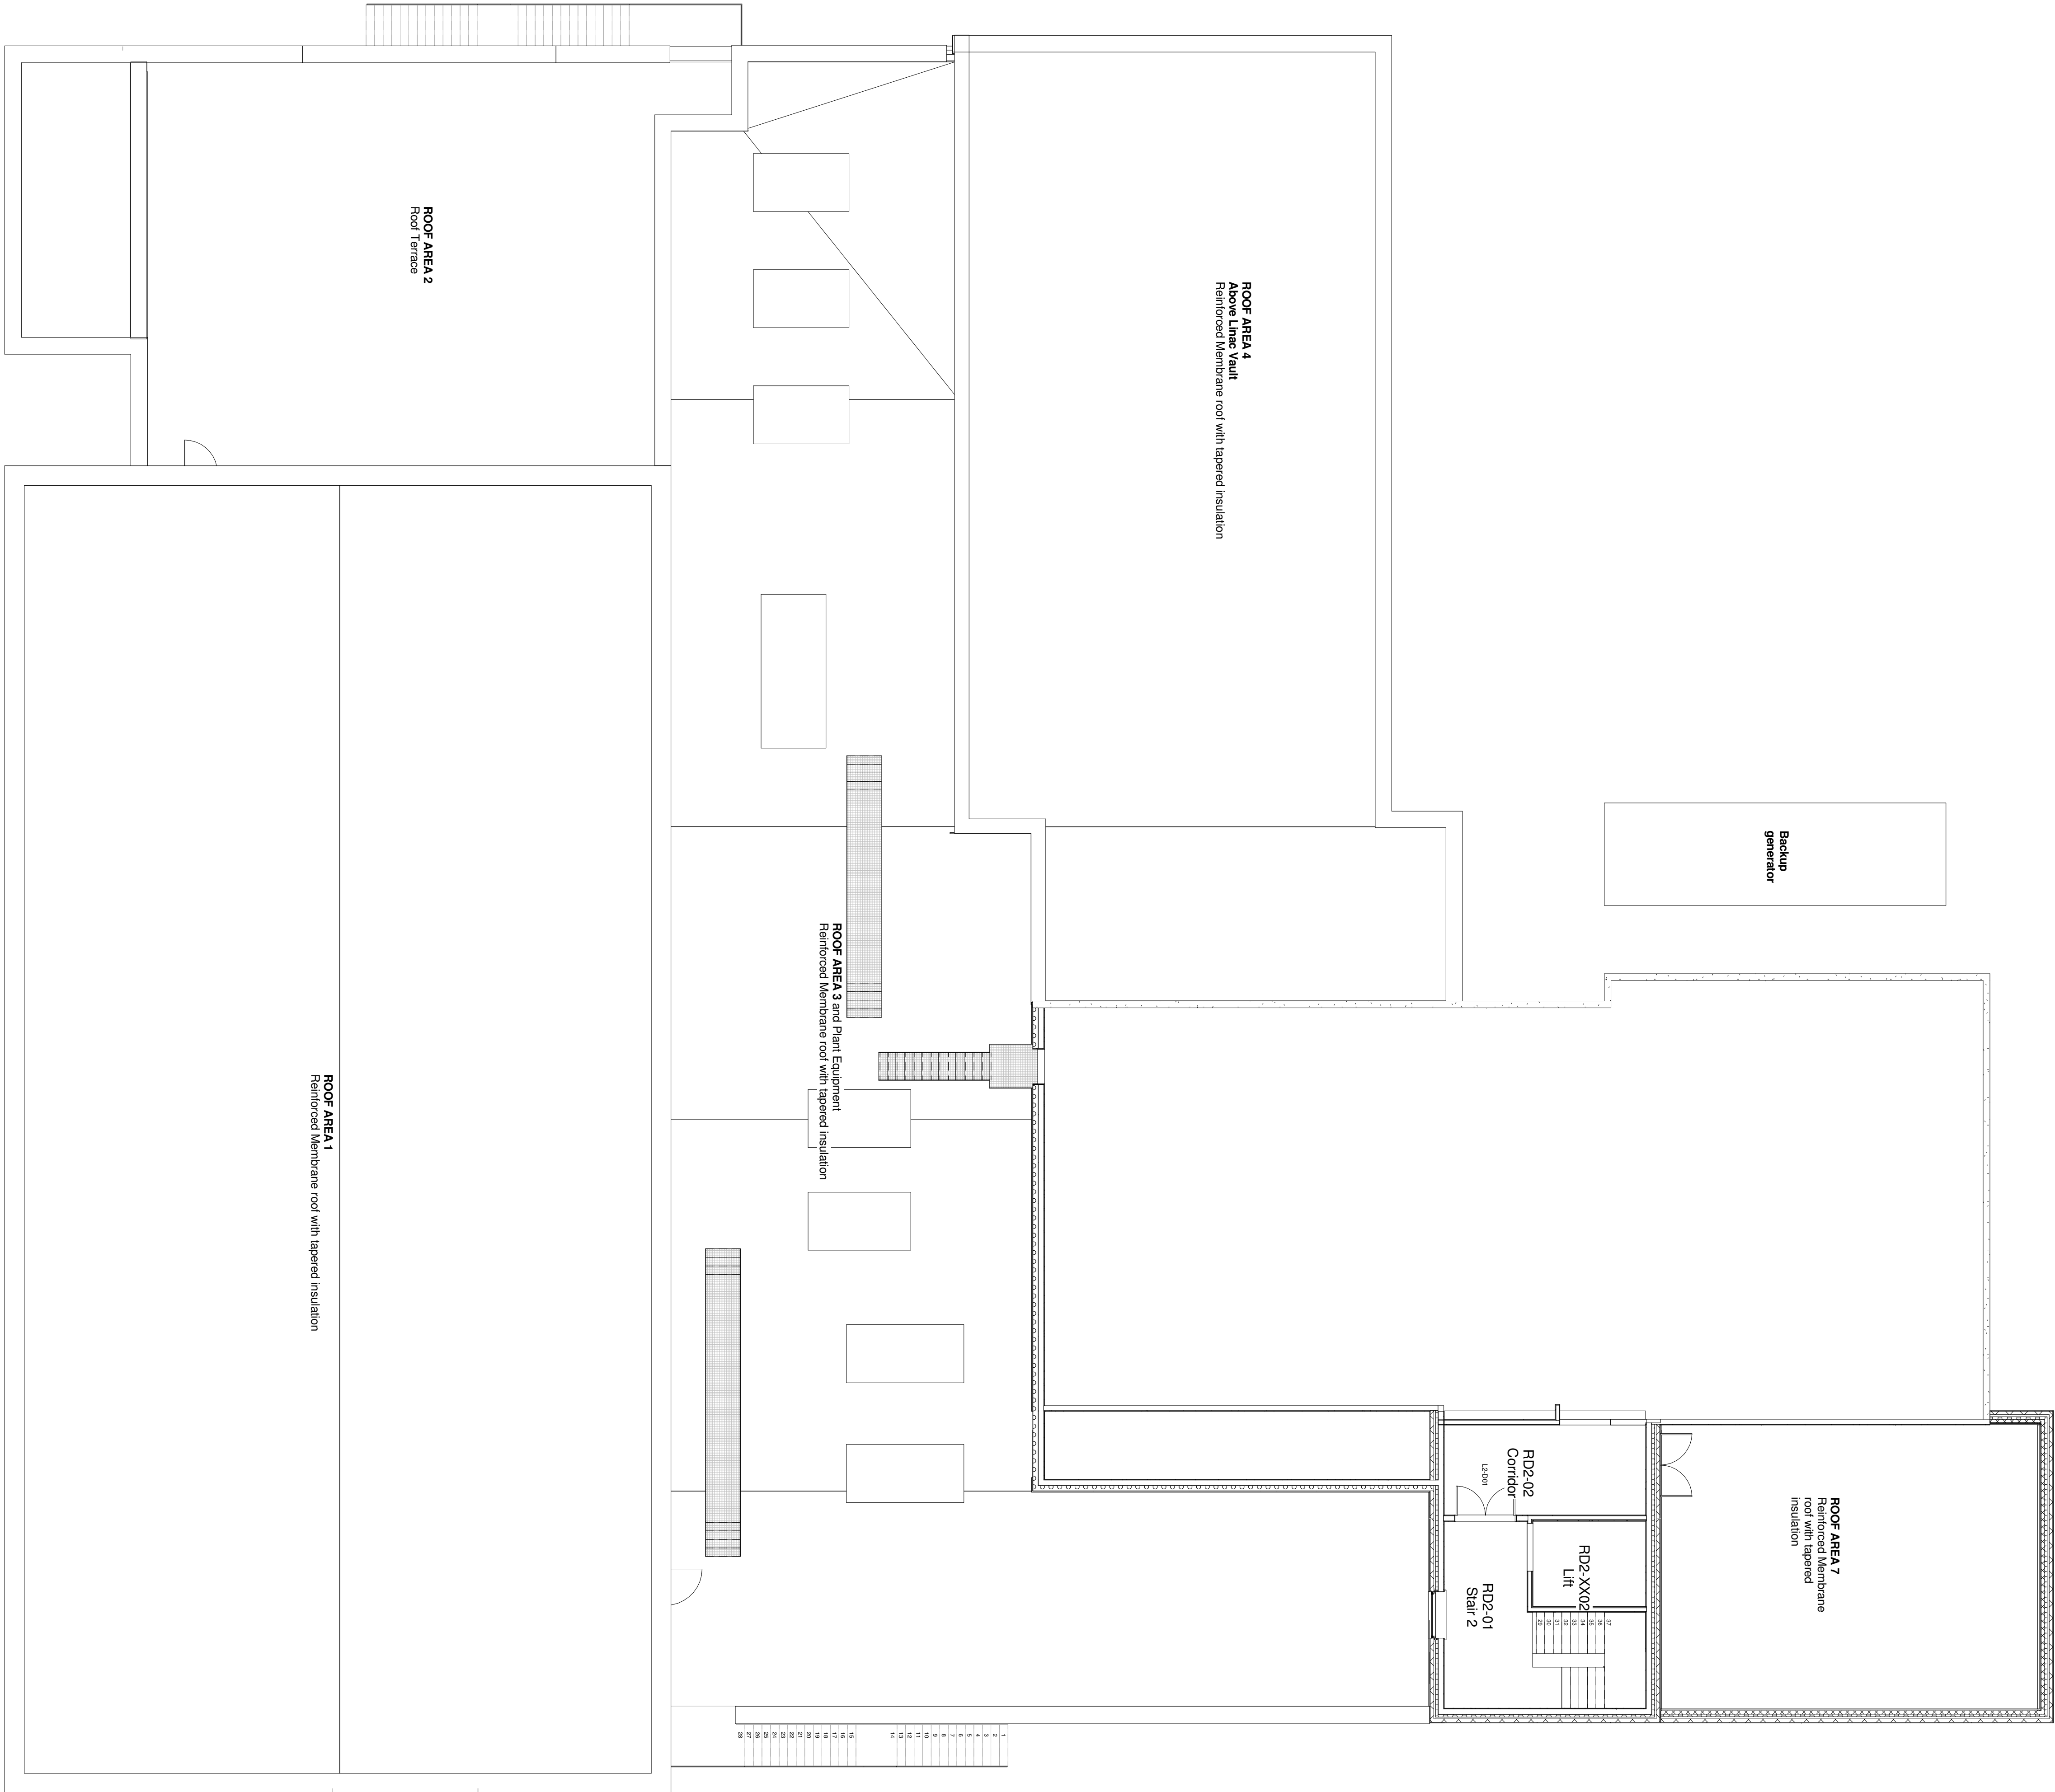


- NOTES:
1. DO NOT SCALE from the drawing
 2. Further dimensions required to be requested from the project technical team
 3. Report discrepancies to JDDK project team immediately.
 4. This model file contains the following consultants model files:-

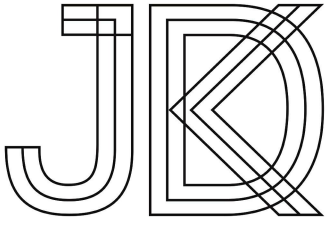

Level 0 - Working Second Floor Plan - Planning

REV	ISSUED BY	DATE	DESCRIPTION
REVISION LOG			
		JDDK Architects Millmount Ponteland Road Newcastle upon Tyne NE5 3AL t. 0191 286 0811 f. 0191 286 3870 e. millmount@jddk.co.uk jddk.co.uk	
CLIENT		PPI	
PROJECT TITLE		PPI Liverpool Cancer Centre	
TITLE		Level 2 - Second Floor Plan	
MAIN CONTRACTOR			
QUANTITY SURVEYOR		M&E CONSULTANT Desco	
STRUCTURAL CONSULTANT Fairhurst		OTHER CONSULTANT	
DRAWING No. 3746-JDDK-A-12104			REV
JDDK INTERNAL REF: 3746		JDDK REF NO:	121.04
SCALE: 1 : 100 @ A1		ISSUE DATE:	29.29.2017
DRAWN BY: OM		CHECKED BY:	KT
STATUS: Preliminary	PURPOSE OF ISSUE: Planning		