

Appendix A

Existing Site Layout

Proposed Layout

Existing Hardstanding Layout


Proposed Hardstanding Layout

United Utilities Sewer Records


Existing Drainage Layout

Proposed Drainage Layout


Microdrainage Calculations

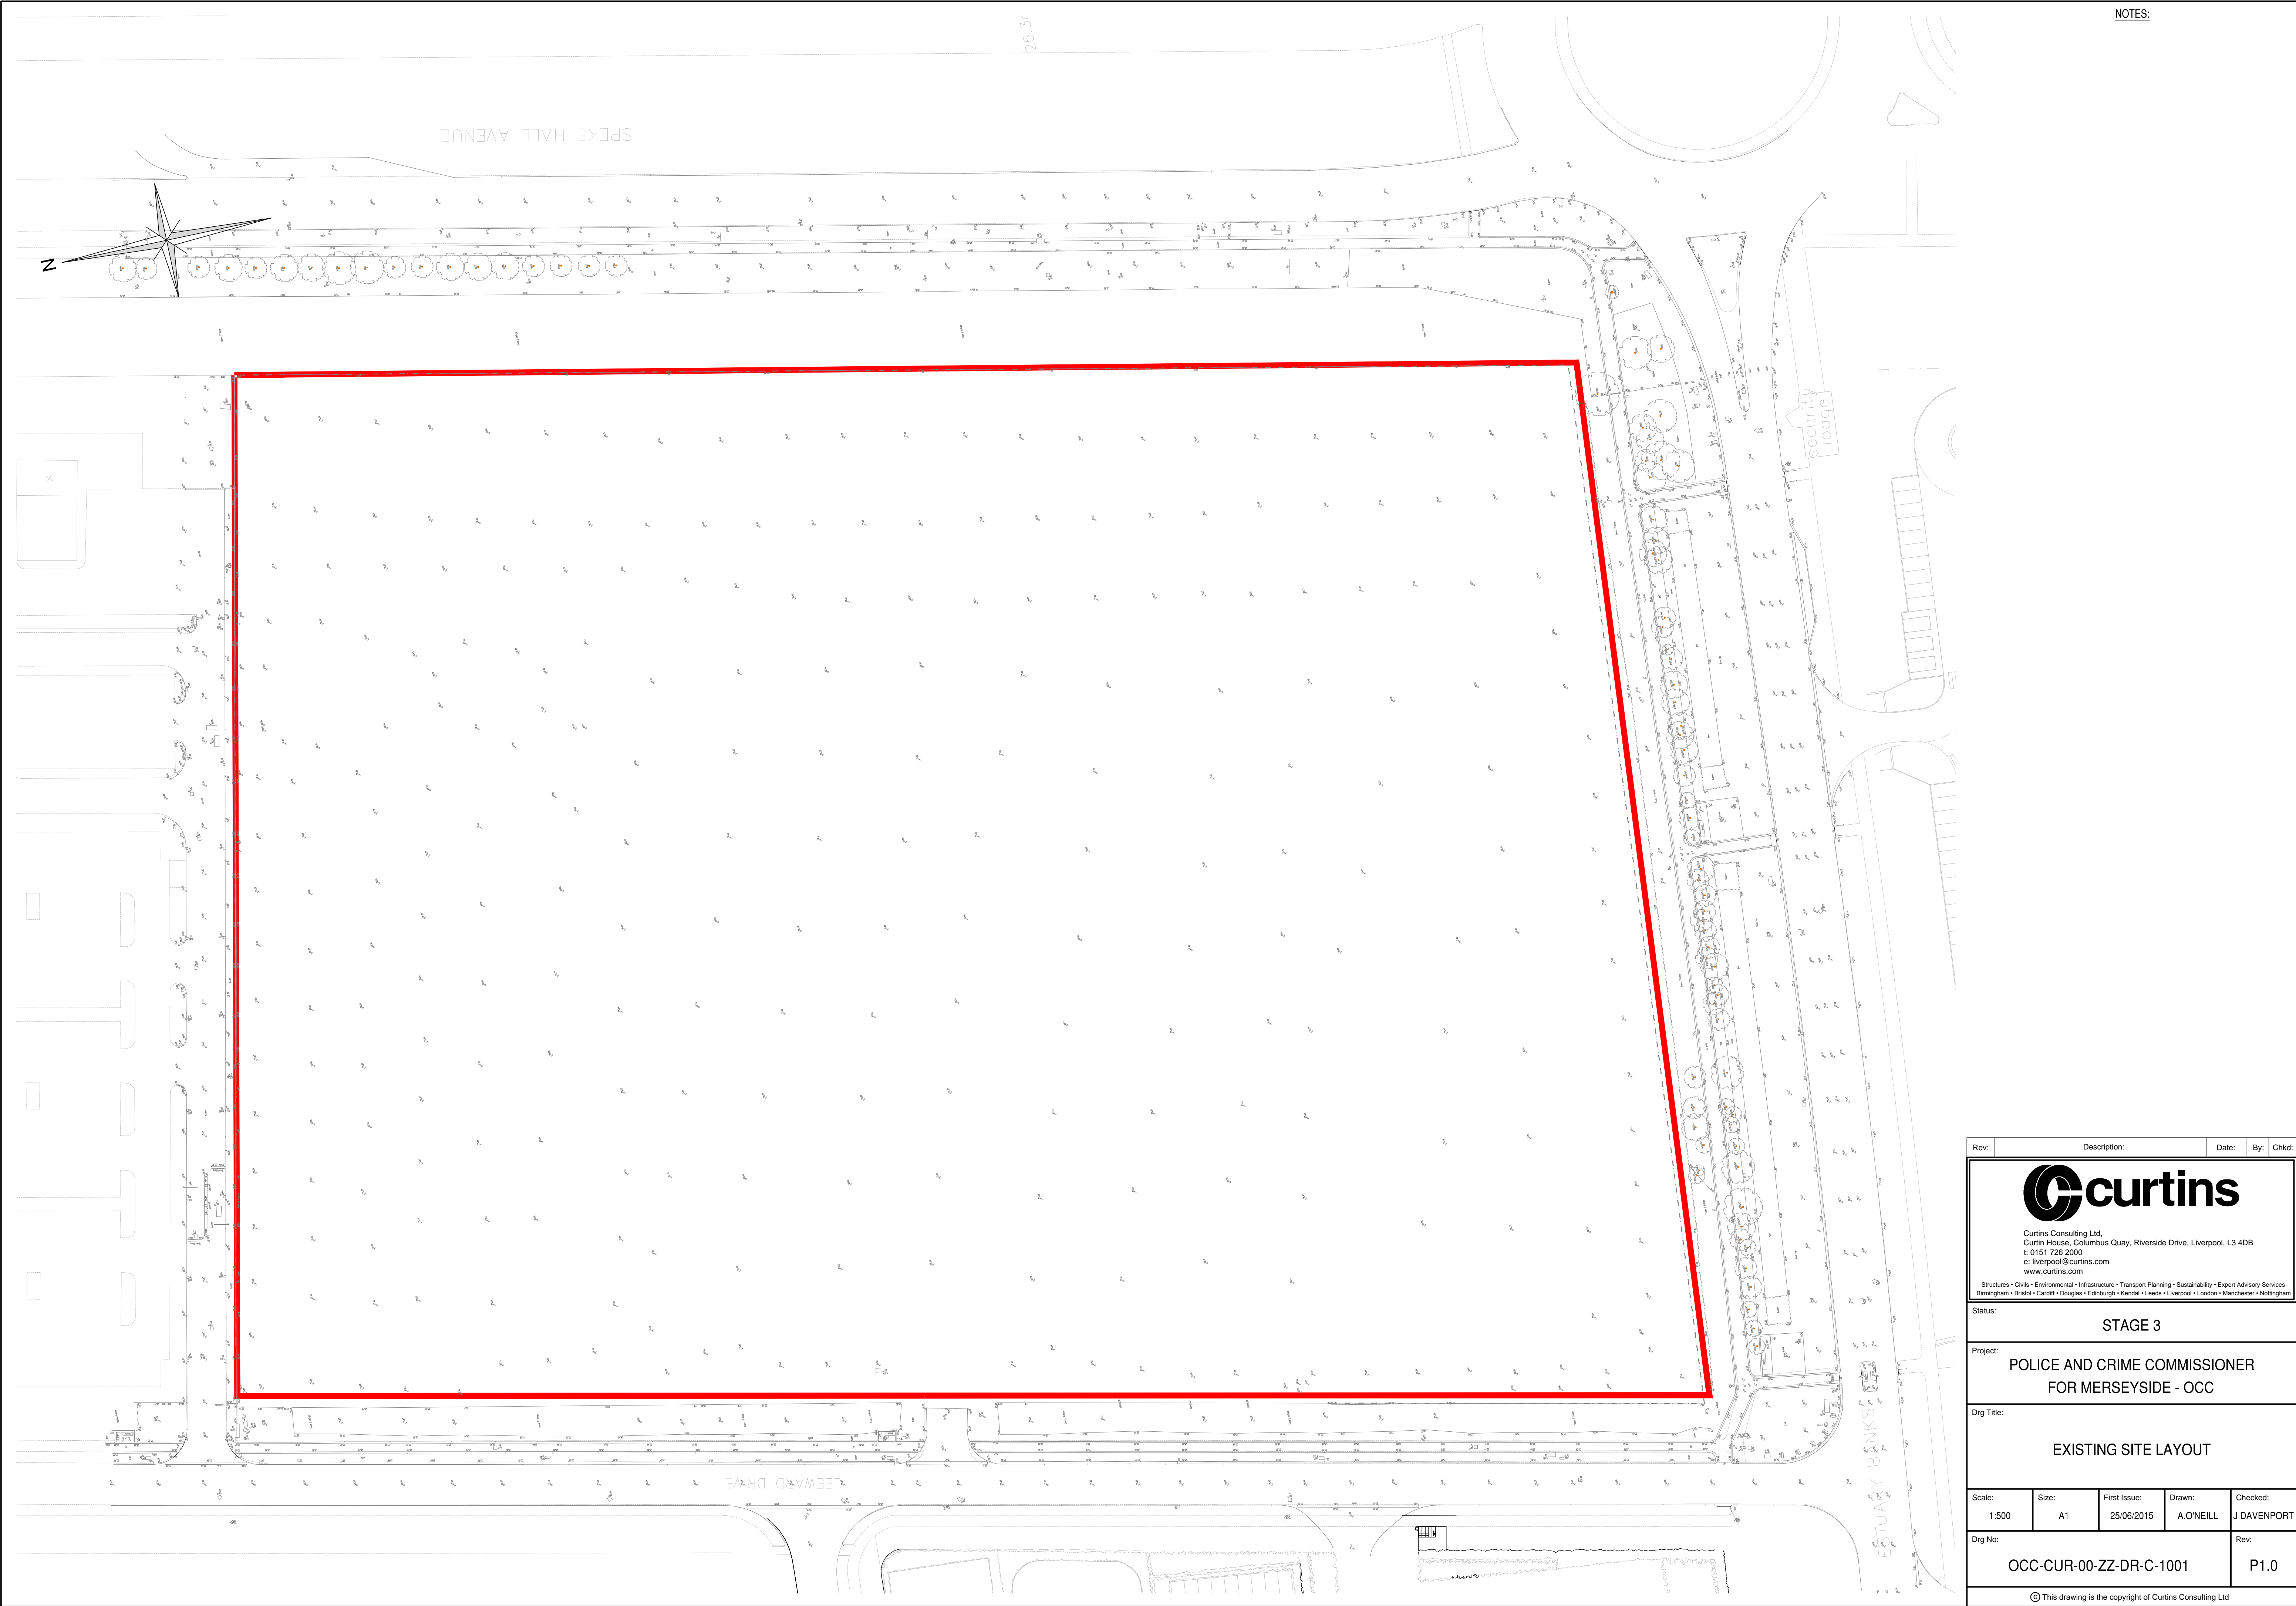

NOTES:

Rev:	Description:	Date:	By:	Chkd:
<div><p>Curtins Consulting Ltd, Curtin House, Columbus Quay, Riverside Drive, Liverpool, L3 4DB t: 0151 726 2000 e: liverpool@curtins.com www.curtins.com</p><p>Structures • Civils • Environmental • Infrastructure • Transport Planning • Sustainability • Expert Advisory Services Birmingham • Bristol • Cardiff • Douglas • Edinburgh • Kendal • Leeds • Liverpool • London • Manchester • Nottingham</p></div>				
Status: STAGE 3				
Project: POLICE AND CRIME COMMISSIONER FOR MERSEYSIDE - OCC				
Drg Title: EXISTING SITE LAYOUT				
Scale: 1:500	Size: A1	First Issue: 25/06/2015	Drawn: A.O'NEILL	Checked: J DAVENPORT
Drg No: OCC-CUR-00-ZZ-DR-C-1001				Rev: P1.0
© This drawing is the copyright of Curtins Consulting Ltd				



Rev:	Description:	Date:	By:	Chkd:
 <p>Curtins Consulting Ltd, Curtin House, Columbus Quay, Riverside Drive, Liverpool, L3 4DB t: 0151 726 2000 e: liverpool@curtins.com www.curtins.com</p> <p>Structures • Civils • Environmental • Infrastructure • Transport Planning • Sustainability • Expert Advisory Services Birmingham • Bristol • Cardiff • Douglas • Edinburgh • Kendal • Leeds • Liverpool • London • Manchester • Nottingham</p>				
Status:				
STAGE 3				
Project:				
POLICE AND CRIME COMMISSIONER FOR MERSEYSIDE POLICE				
Drg Title:				
PROPOSED SITE LAYOUT				
Scale:	Size:	First Issue:	Drawn:	Checked:
1:500	A1	25/06/2015	A.O'NEILL	J DAVENPORT
Drg No:				Rev:
OCC-CUR-00-ZZ-DR-C-1002				P1.0
© This drawing is the copyright of Curtins Consulting Ltd				