



DO NOT SCALE

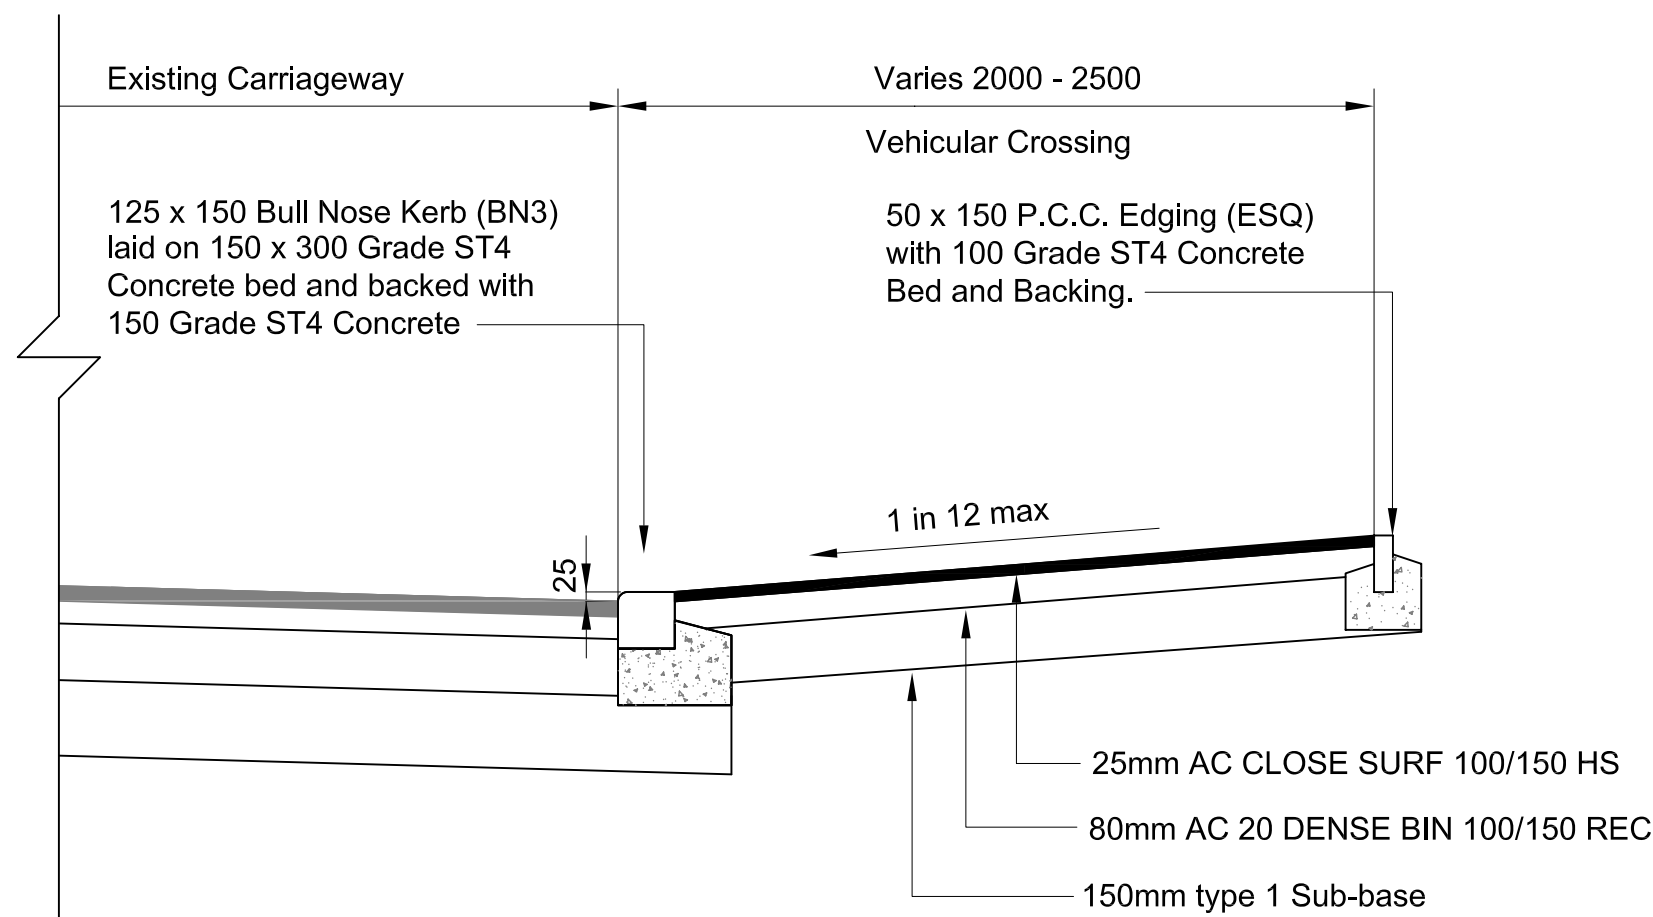


VEHICULAR CROSSING DETAIL

SCALE 1:20

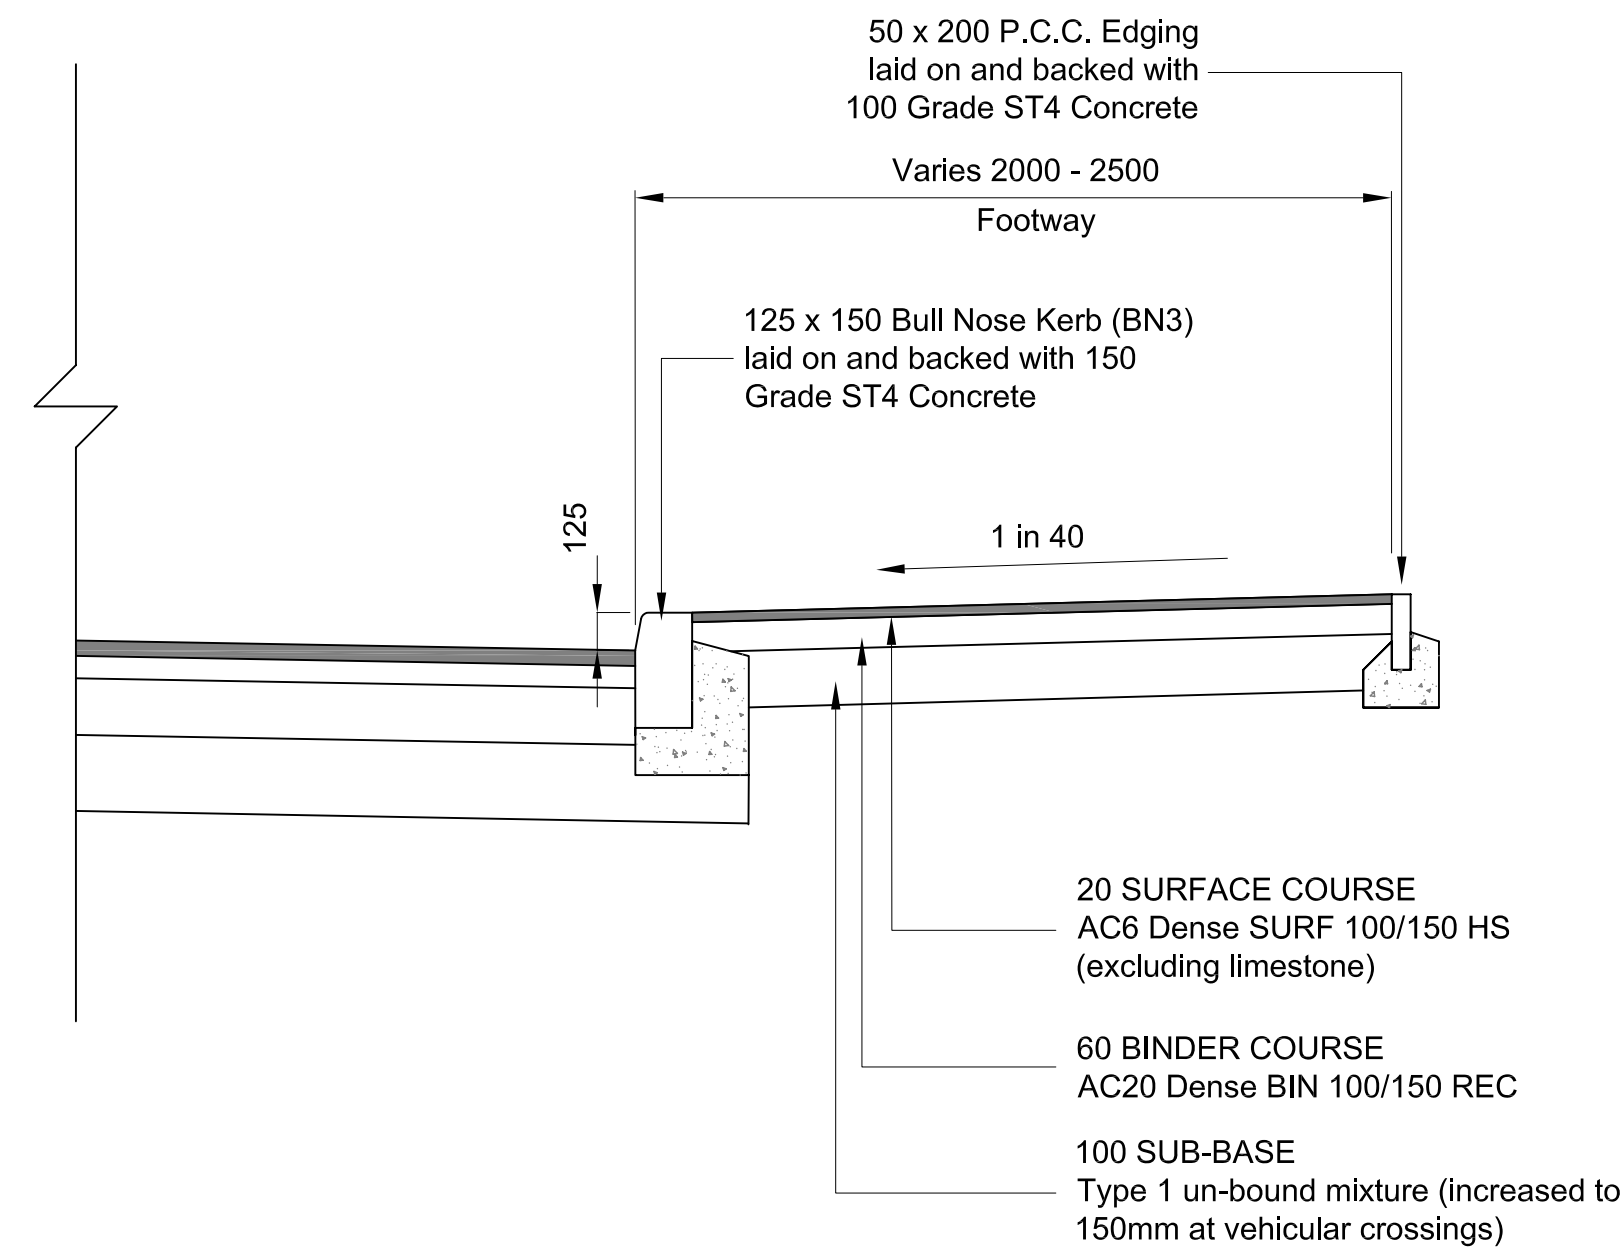


FOOTPATH DETAIL

SCALE 1:20

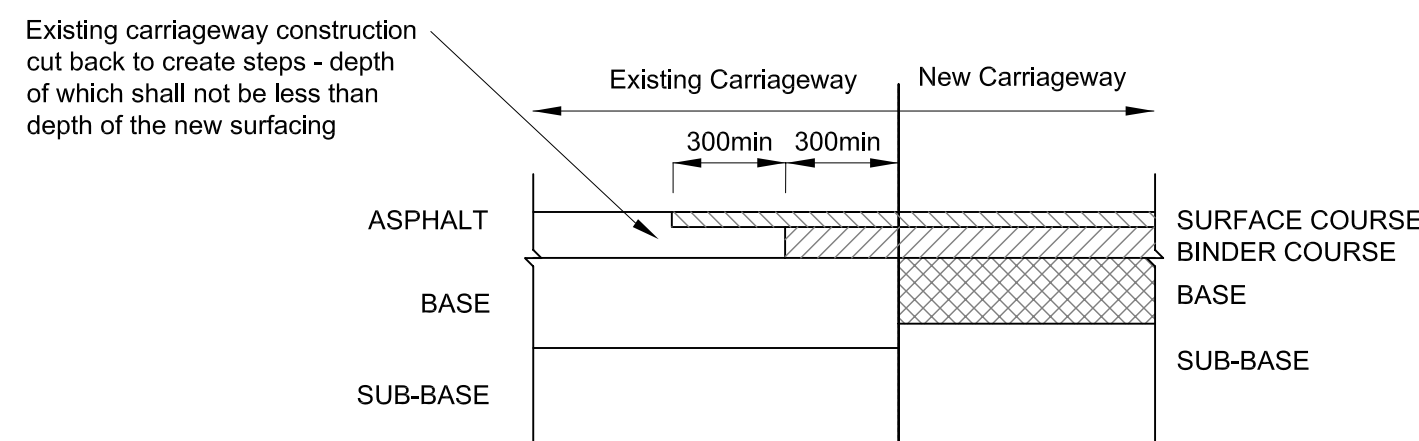

DETAIL OF TRANSVERSE JOINT BETWEEN
NEW AND EXISTING CARRIAGEWAY


NTS

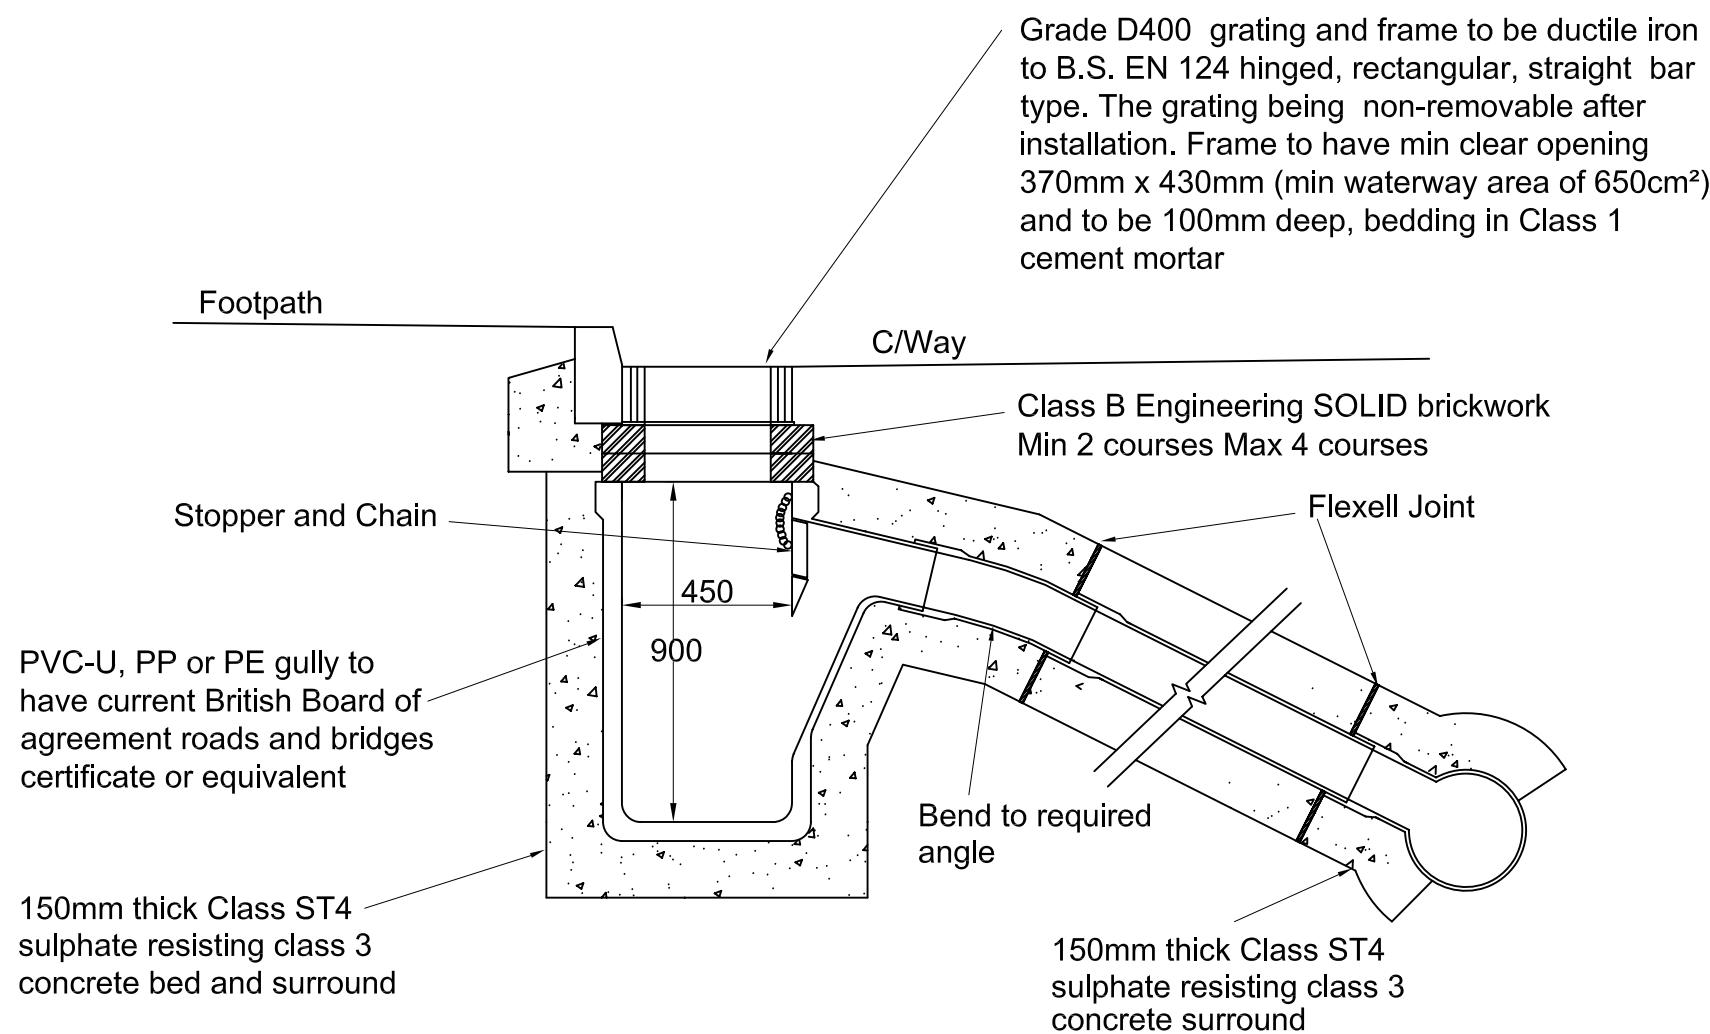

STREET GULLY TYPE 1


(to suit Liverpool 2020 Drg No: HD/D5)

SCALE 1:20

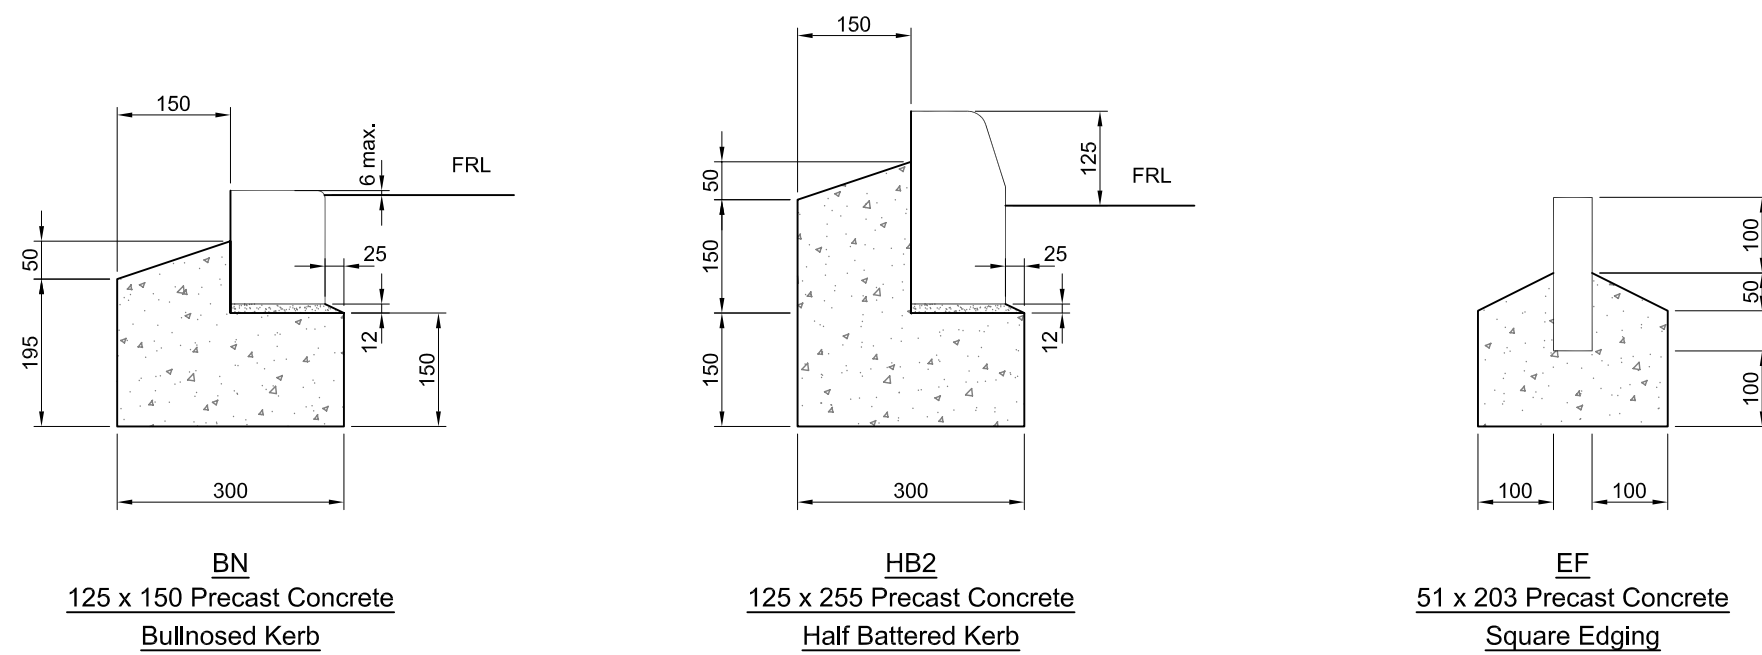

KERBING AND EDGING DETAILS

Scale 1:10

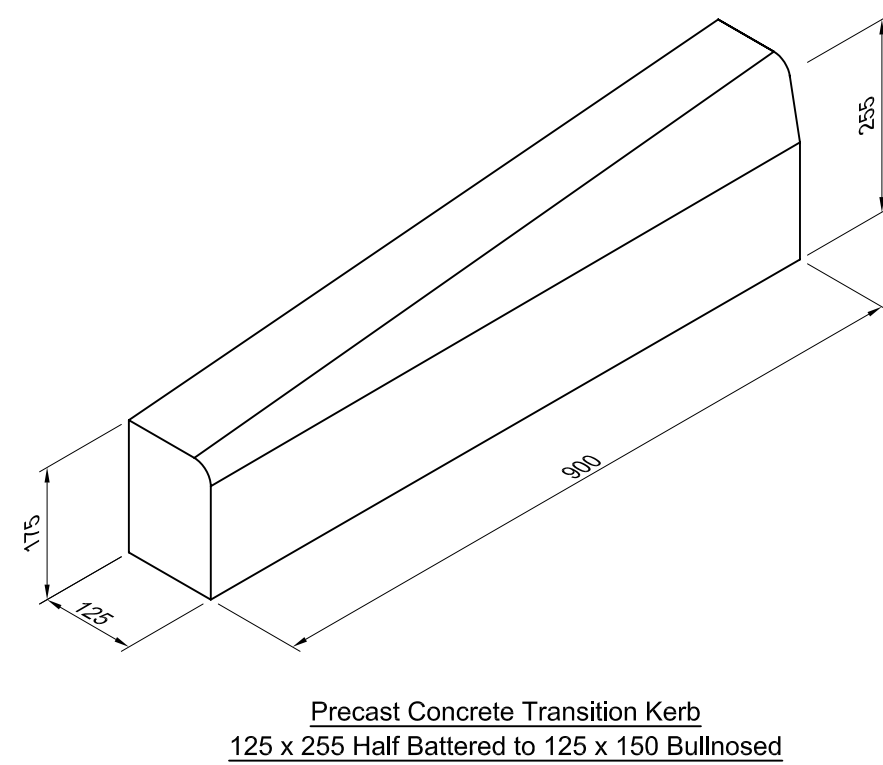

Precast Concrete Transition Kerb
125 x 255 Half Battered to 125 x 150 Bullnosed

Notes

1. All dimensions are in millimetres unless otherwise shown
2. All works to be in accordance with Liverpool City Council's / 2020 Liverpool's Standard Details, and as agreed with Liverpool City Council's representative.
3. The final thickness of sub-base materials required shall be determined by on site tests to the approval of the Engineer. Soft spots below formation and unsatisfactory sub-grade materials shall be excavated and replaced with selected filling Type 1 material to formation level
4. Kerb and edging details must conform with Liverpool City council standard details 2020 std Detail/HD/R10
5. Bitumen Materials shall comply with BS EN 13108-1
6. Where possible with the constraints of technical performance, recycled materials to be used, i.e recycled Type 1 sub base, recycled macadam base course.


Coopers Drawing List:

- | | |
|---------|------------------------------|
| 6292/01 | Proposed Drainage Layout |
| 6292/02 | Proposed Highway Layout |
| 6292/03 | Highway Construction Details |
| 6292/04 | Drainage Details |
| 6292/05 | Flow Control Manhole Details |
| 6292/06 | External Works Plan |

TENDER



chartered consulting engineers
Tel: 01244 684910
Fax: 01244 684911
Email: admin@coopers.co.uk
Web: http://coopers.co.uk
Park House
Sandpiper Court
Chester Business Park
Chester
CH4 9QU

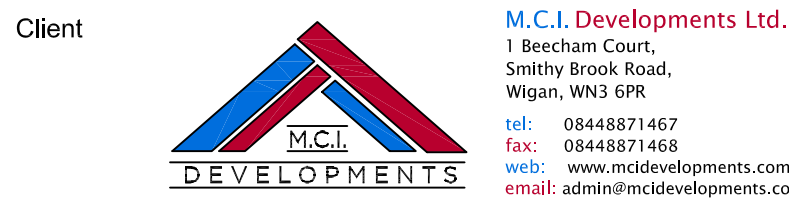

Client
Project
Bedford Road,
Liverpool.

Title
Highway Construction Details

DRAWING NUMBER	SCALE at A1		
	DATE	August 2015	REVISION
	DRAWN	PJN	-
	CHECKED	AJ	-

6292 / 03