


Basement floor plan key:

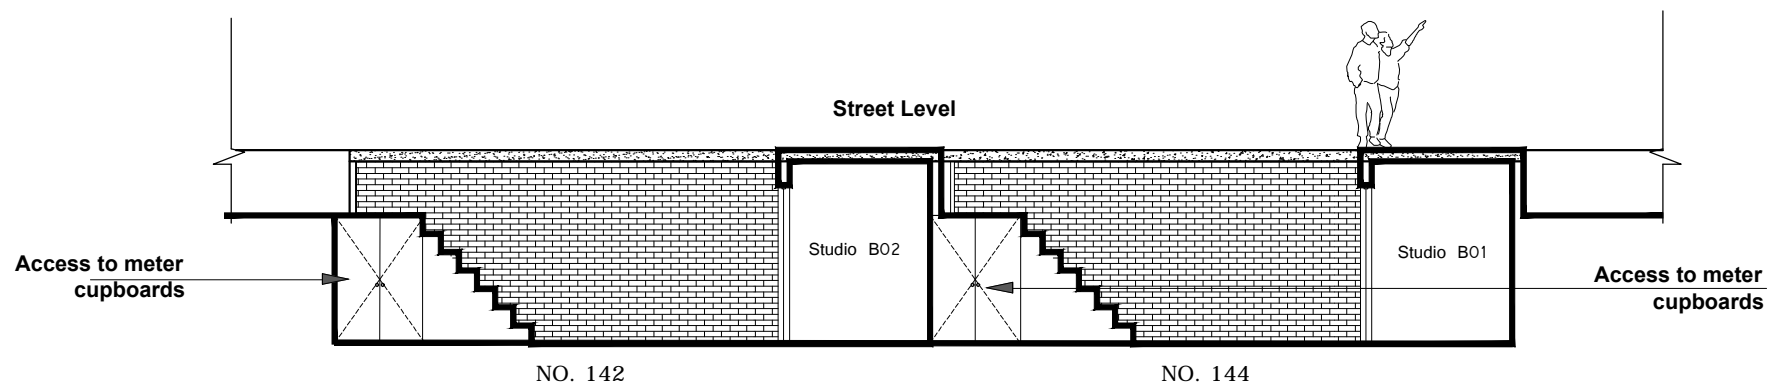

schematic section R-R
showing meter cupboards

Note: Pursuant to condition 10

			Project	Drawing Name	<div> <div> Suburban Studios </div> <div> COOMBE FARM, CR0 5HL 020-8654-2310 info@suburbanstudios.co.uk </div> </div>	Job No	090502	Date	12/06/15
			Jamaica Hotel	Proposed detail of meter cupboards		Drawing Number	AP208	Rev	
			142-144 Upper Parliament Street			Scale	1:100 @ A3		
			Liverpool L8 7LG			Drawn:	SNR	Checked:	DV, AS
Revision	Description	Date				DO NOT SCALE FROM THIS DRAWING: Any drawing errors or divergences should be brought to the attention of SubUrban Studios at the address shown.			