


PHASE 3

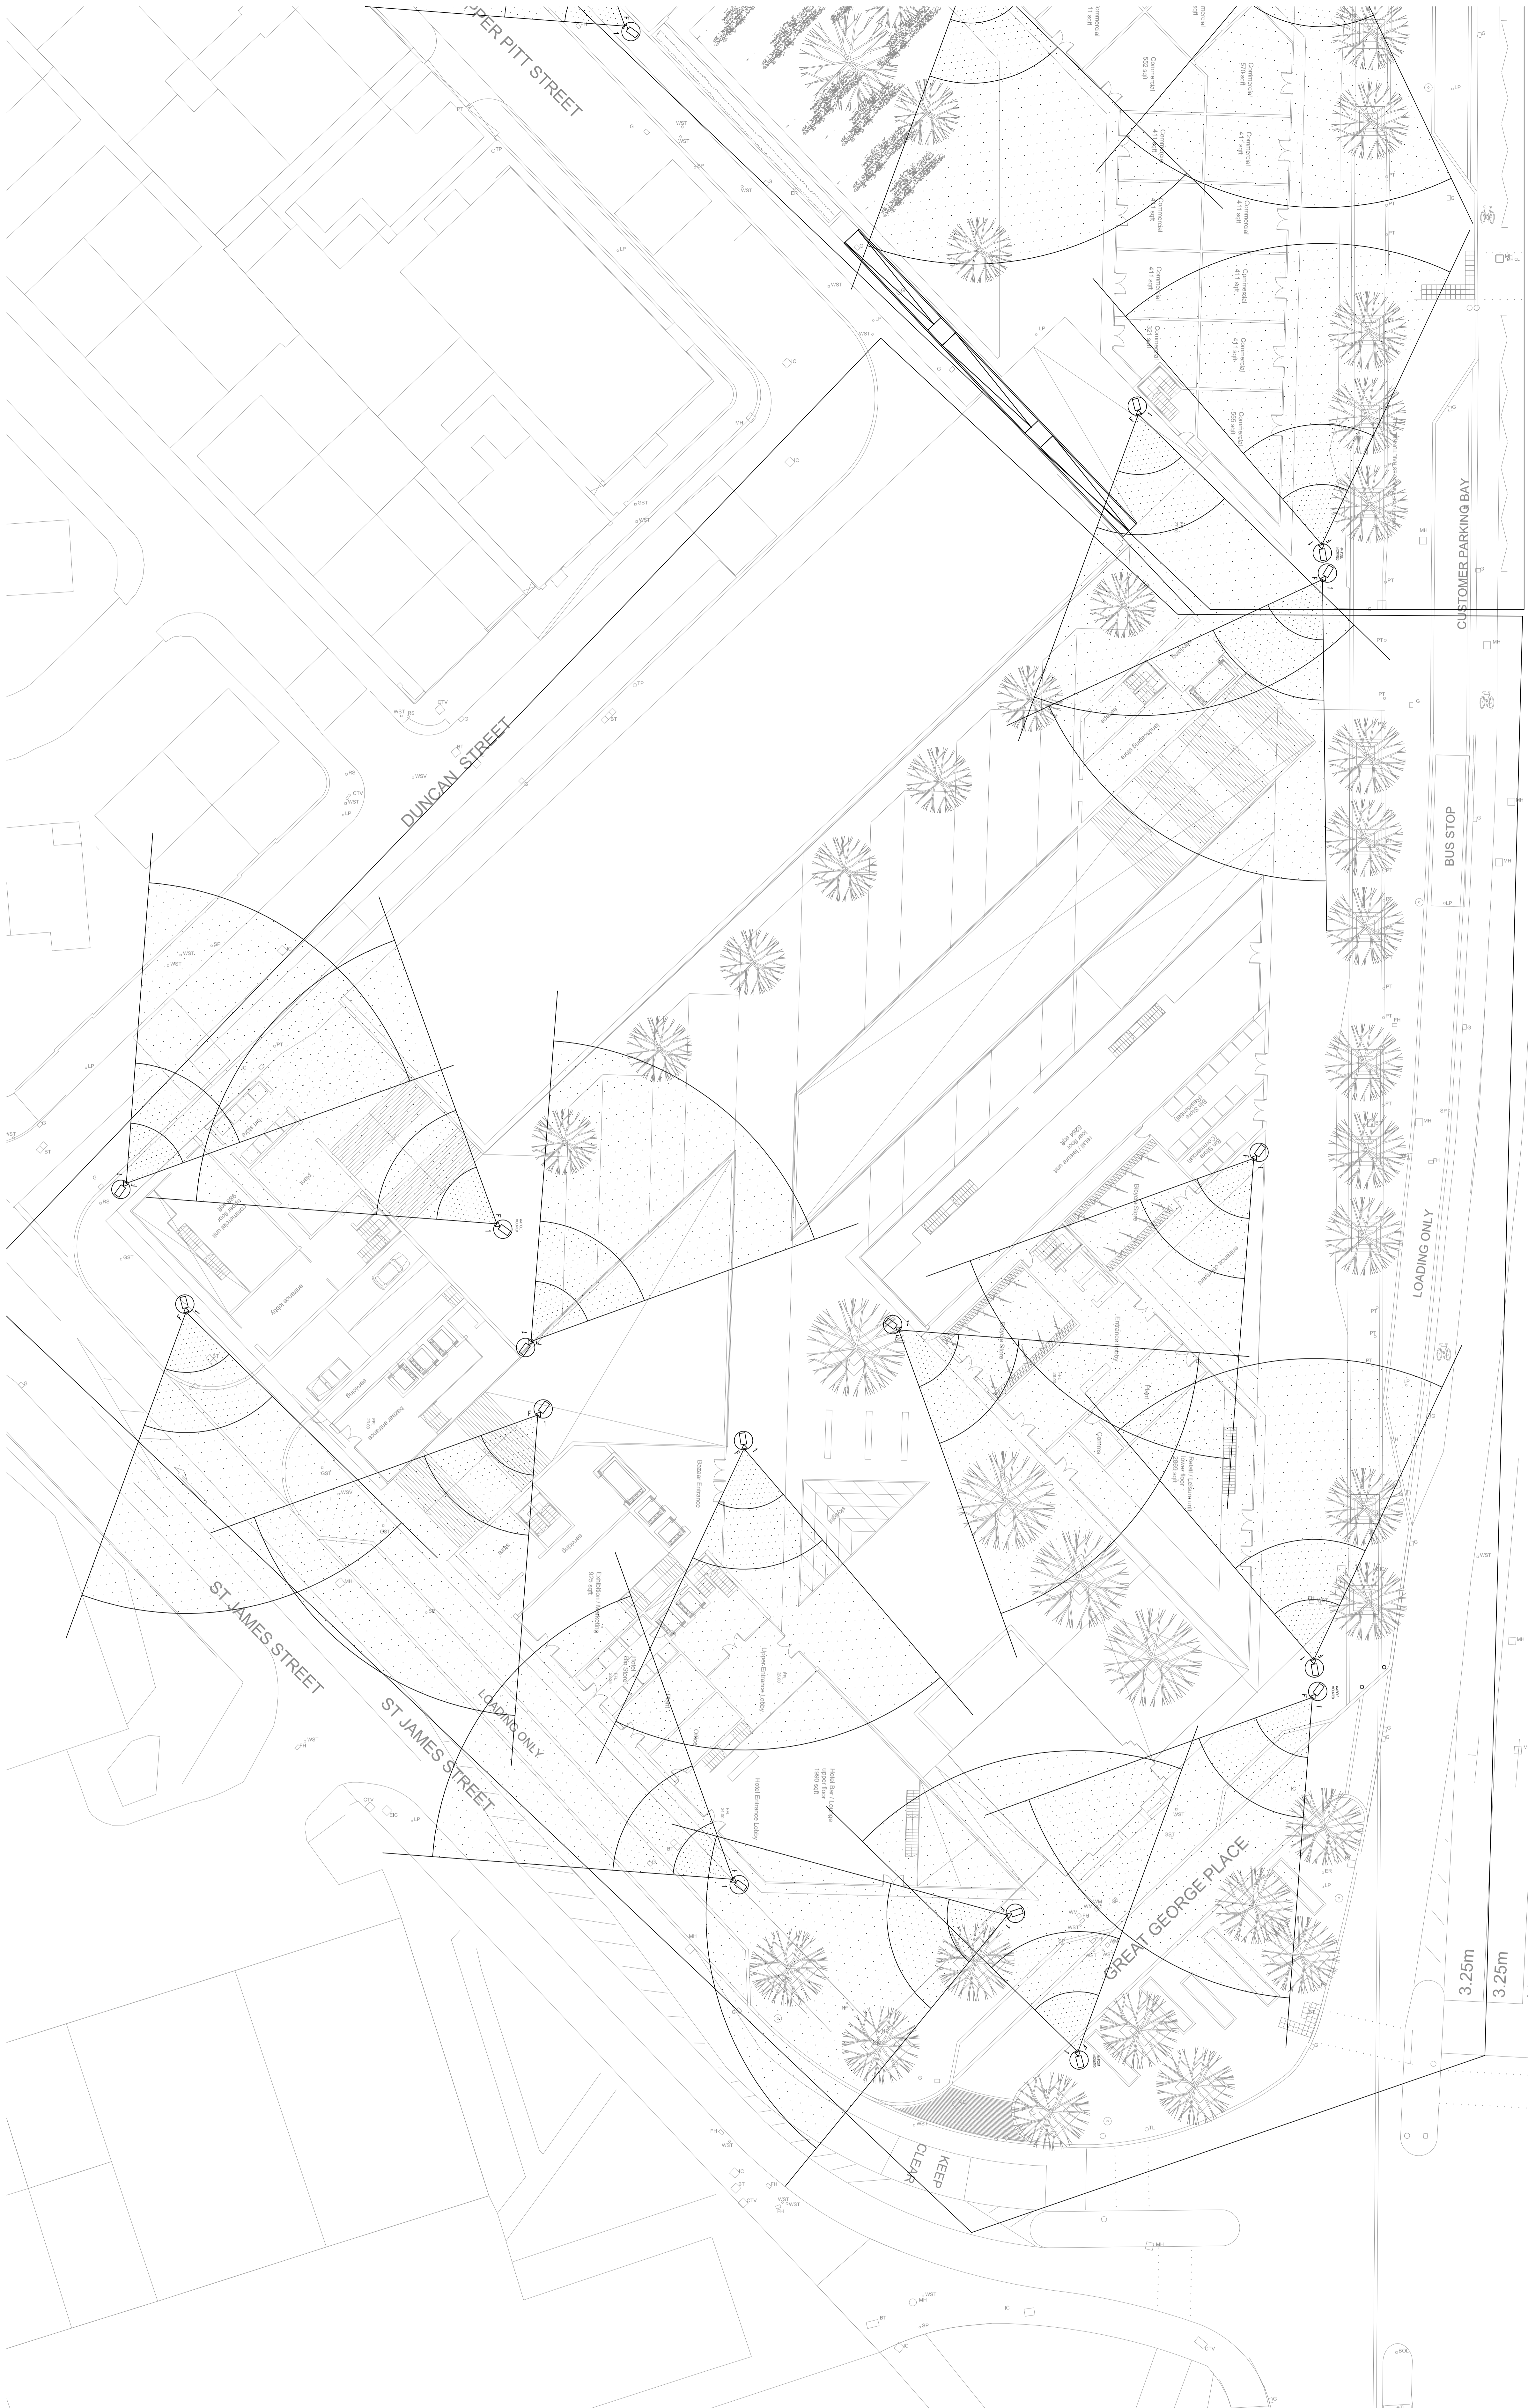

- NOTES
1. THIS DRAWING SHALL BE READ IN CONJUNCTION WITH ANY RELEVANT STRUCTURAL, ARCHITECTURAL AND CONSULTANTS DRAWINGS.
2. THIS DRAWING SHALL BE READ IN CONJUNCTION WITH THE SERVICES SPECIFICATION.
3. DO NOT SCALE FROM THIS DRAWING.
4. WHERE EXISTING CCTV CAMERAS ARE MOUNTED ON EXTERNAL LIGHTING COLUMNS THE CONTRACTOR SHALL ENSURE THAT THE EXTERNAL LIGHTING COLUMNS ARE SUITABLE FOR CCTV CAMERA MOUNTING (USE THE VARIATION / WIND RESISTANT).
5. ALL WALL MOUNTED / BUILDING MOUNTED CCTV CAMERAS SHALL BE SET OUT IN ACCORDANCE WITH THE ARCHITECTS ELEVATION DETAILS.
6. THIS DRAWING SHOULD BE PRINTED AND READ IN COLOUR.
7. CCTV CAMERAS DEVELOPED IN LINE WITH EXTERNAL MOUNTED - REDISIGN NOTES -
8. EXTERNAL CCTV LAYOUT INCLUDES:
 - EXISTING AND FEEDBACK GATES
9. EXTERNAL DETECTION CCTV MAY TO BE DEVELOPED SHOULD BRISQITE MONITORING BE REQUIRED.


ARCHITECTS DRAWING USED AS XREF

[illegible]

P0	MG	WJ	23/09/15	PRELIMINARY ISSUE	
Rev	CMd	App	Date	Description	
Architecture X-ref Drawings: - Downloading File X-ref Drawings:					

PRELIMINARY ISSUE

PRELIMINARY ISSUE

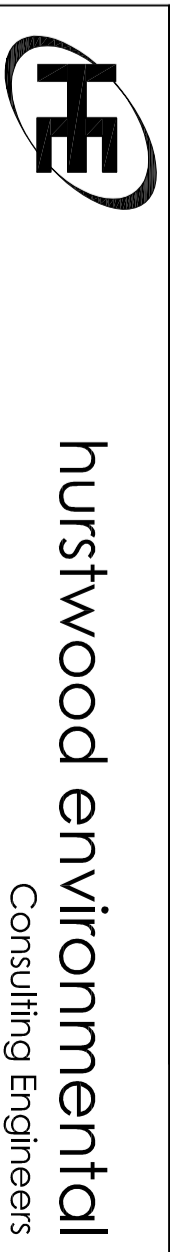

<input checked="" type="checkbox"/>	Liverpool Office 23 Coronado Road Speke Liverpool L24 9JH T: 0151 728 3360 E: liverpool@unimwood-eng.co.uk
<input type="checkbox"/>	London Office 344 Chryl'm Road Bromsbury London WC1X 8BP T: 0203 755 9771 E: london@unimwood-eng.co.uk
	Boston Office A110 Spa Road Belton BU1 4NG T: 01204 707 041 E: boston@unimwood-eng.co.uk

Drawn:	S. BOWMAN	Crkd:	D. CLARKSON	App:	M. JORDAN
Date:	SEPT 2015	Score:	1:200	A0	

PHD1 CONSTRUCTION

NEW CHINA TOWN PHASE 3

Drawing Title:
EXTERNAL SECURITY CCTV, DOOR ACCESS
SITE PLAN SHEET 4 OF 4

Project No:	Series:	Drawing No:	Rev:
-------------	---------	-------------	------