


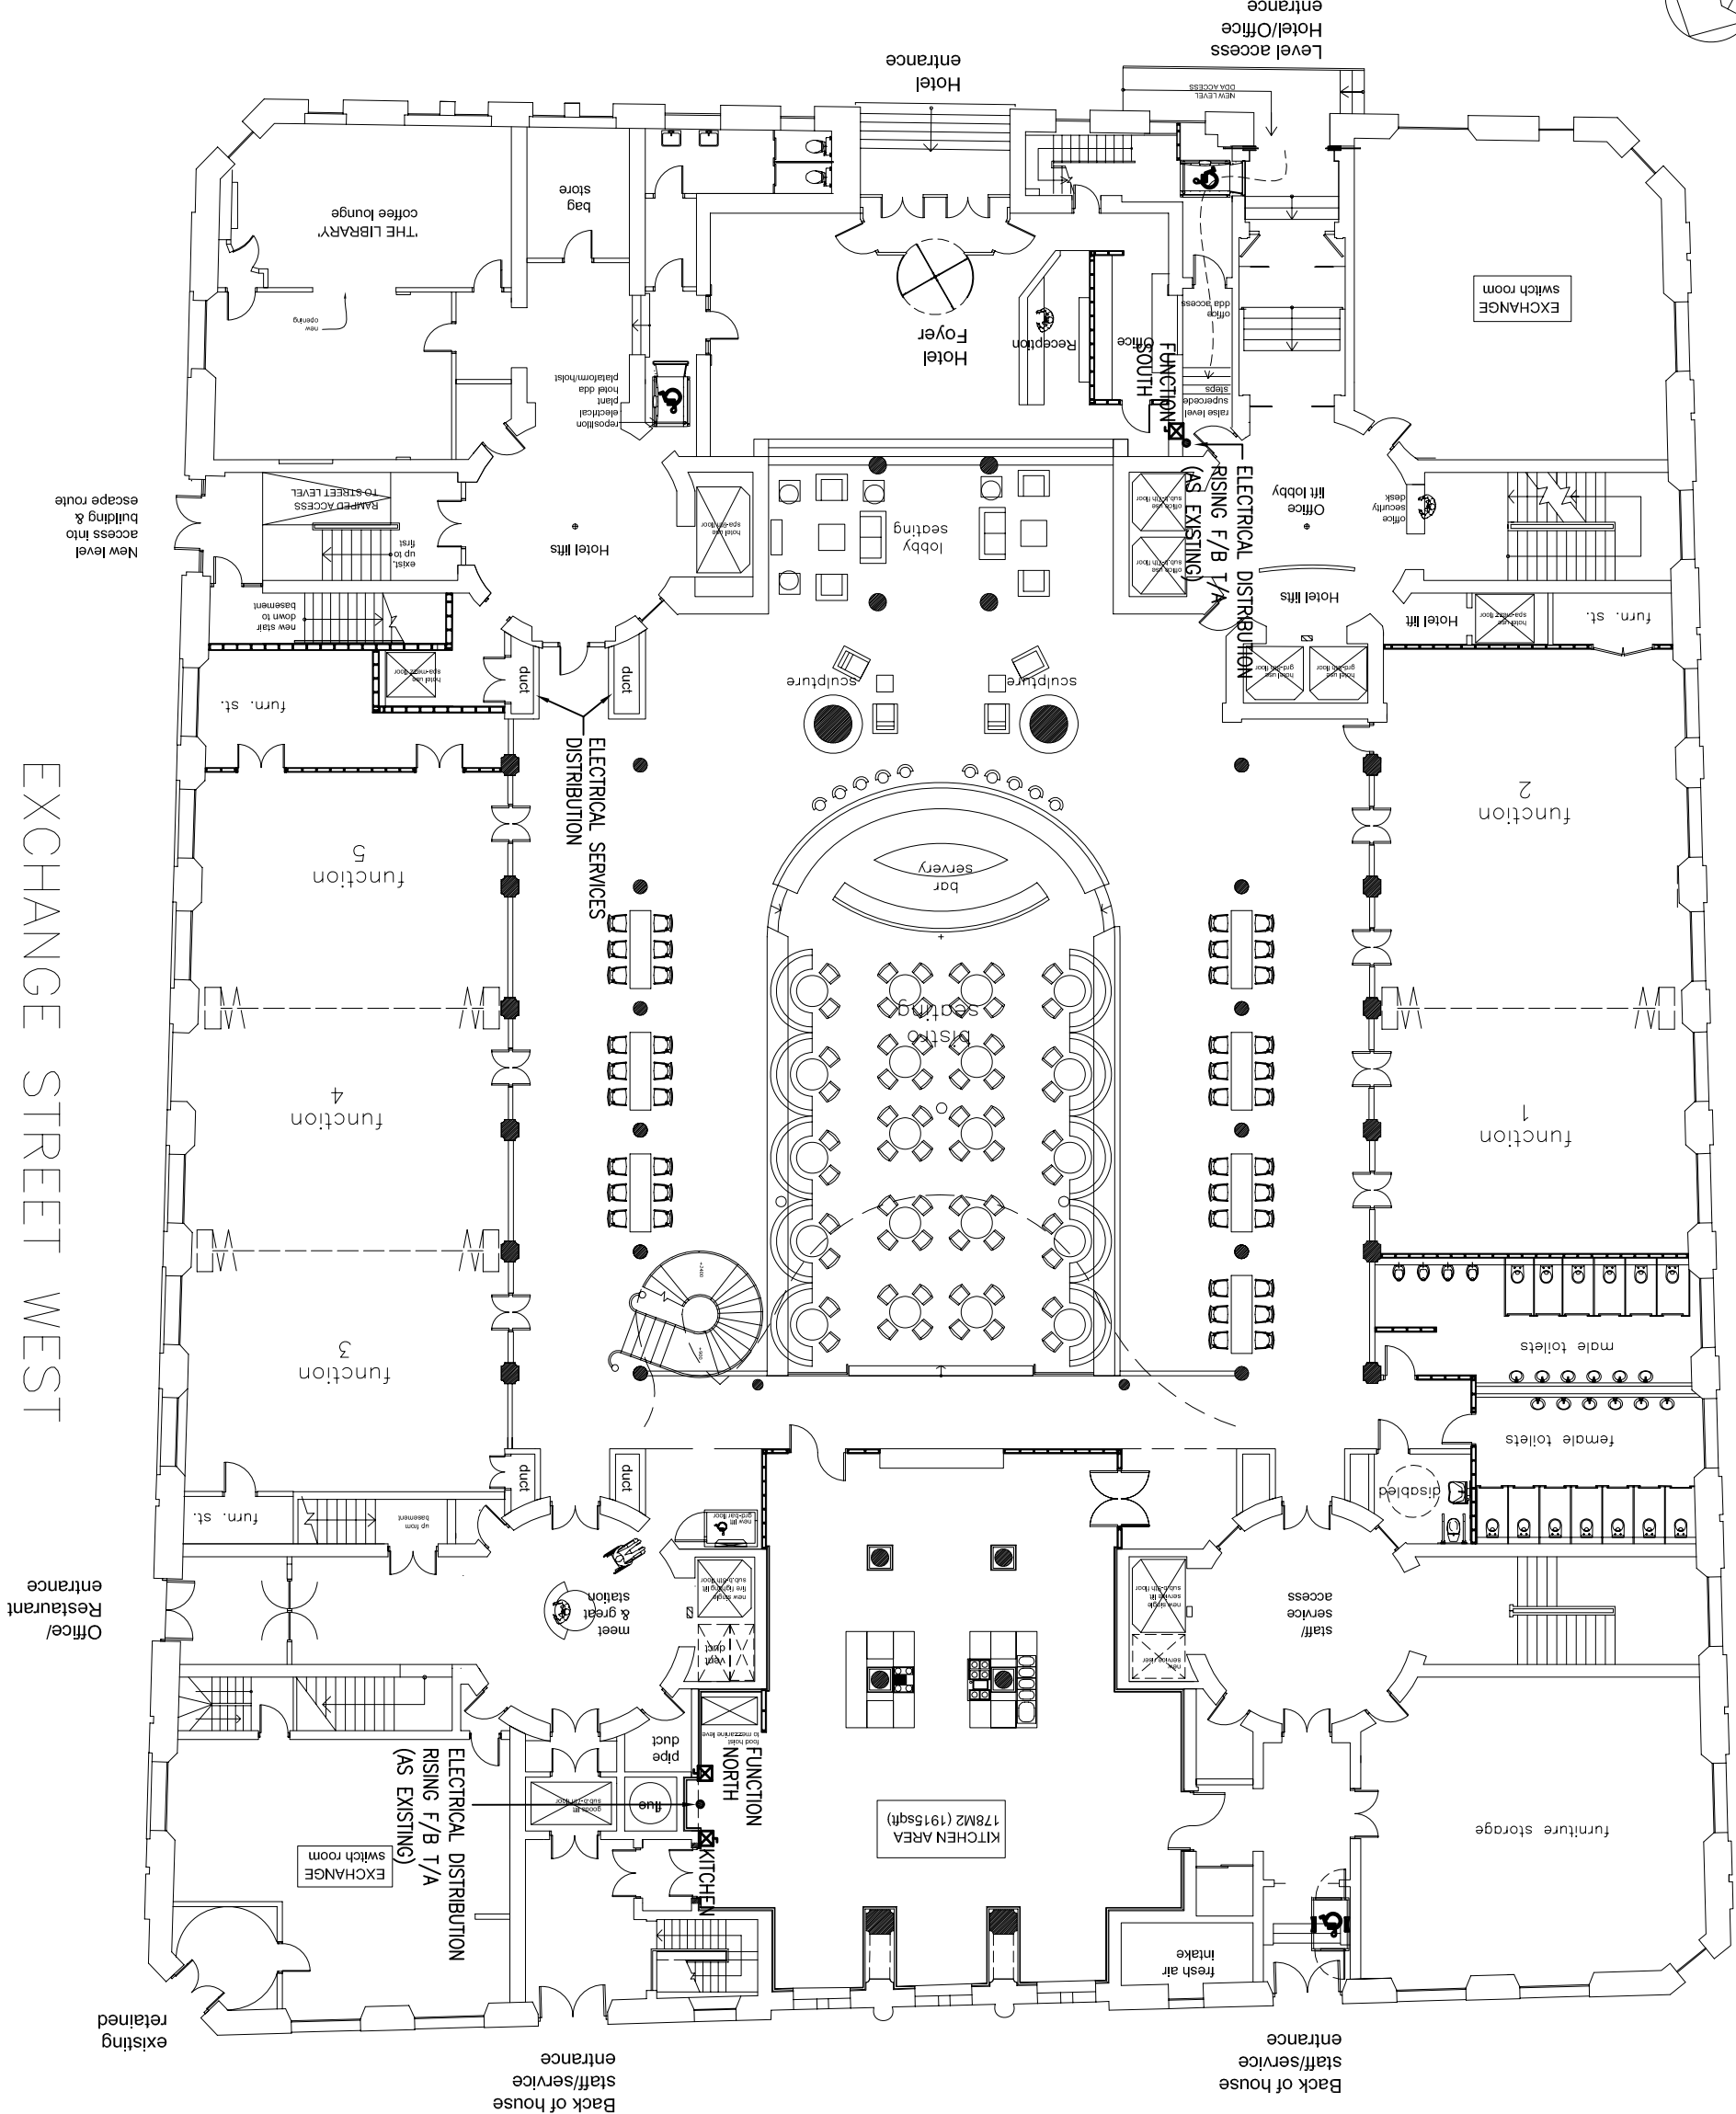

RUMFORD STREET

EXCHANGE STREET WEST



NOTES.

LEGEND.

P2	15.01.10	REVISED IN LINE WITH ARCHITECTS COMMENTS	
P1		PRELIMINARY ISSUE. FOR COMMENT	
Rev	Date	Description	Chkd

HFM Consulting Engineers

1st Floor,
Courtiels House,
38 King Street West,
Manchester
M3 2WZ
Tel: 0161 833 1410
Fax: 0161 833 1412



Also At:
Second Floor, Century Buildings, 31, North John Street, Liverpool, L2 6RG
Tel: 0151 255 2700 Fax: 0151 255 2701

Project
MARTINS BANK BUILDING
LIVERPOOL

Title
GROUND FLOOR INDICATIVE ELECTRICAL LAYOUT

Engineer	PH	Checked	
Job No	L/1247	Date	04.12.09
Drawing No.		Rev.	P2
L /1247/E /202		Scale	1:200 @A3