


RUMFORD STREET

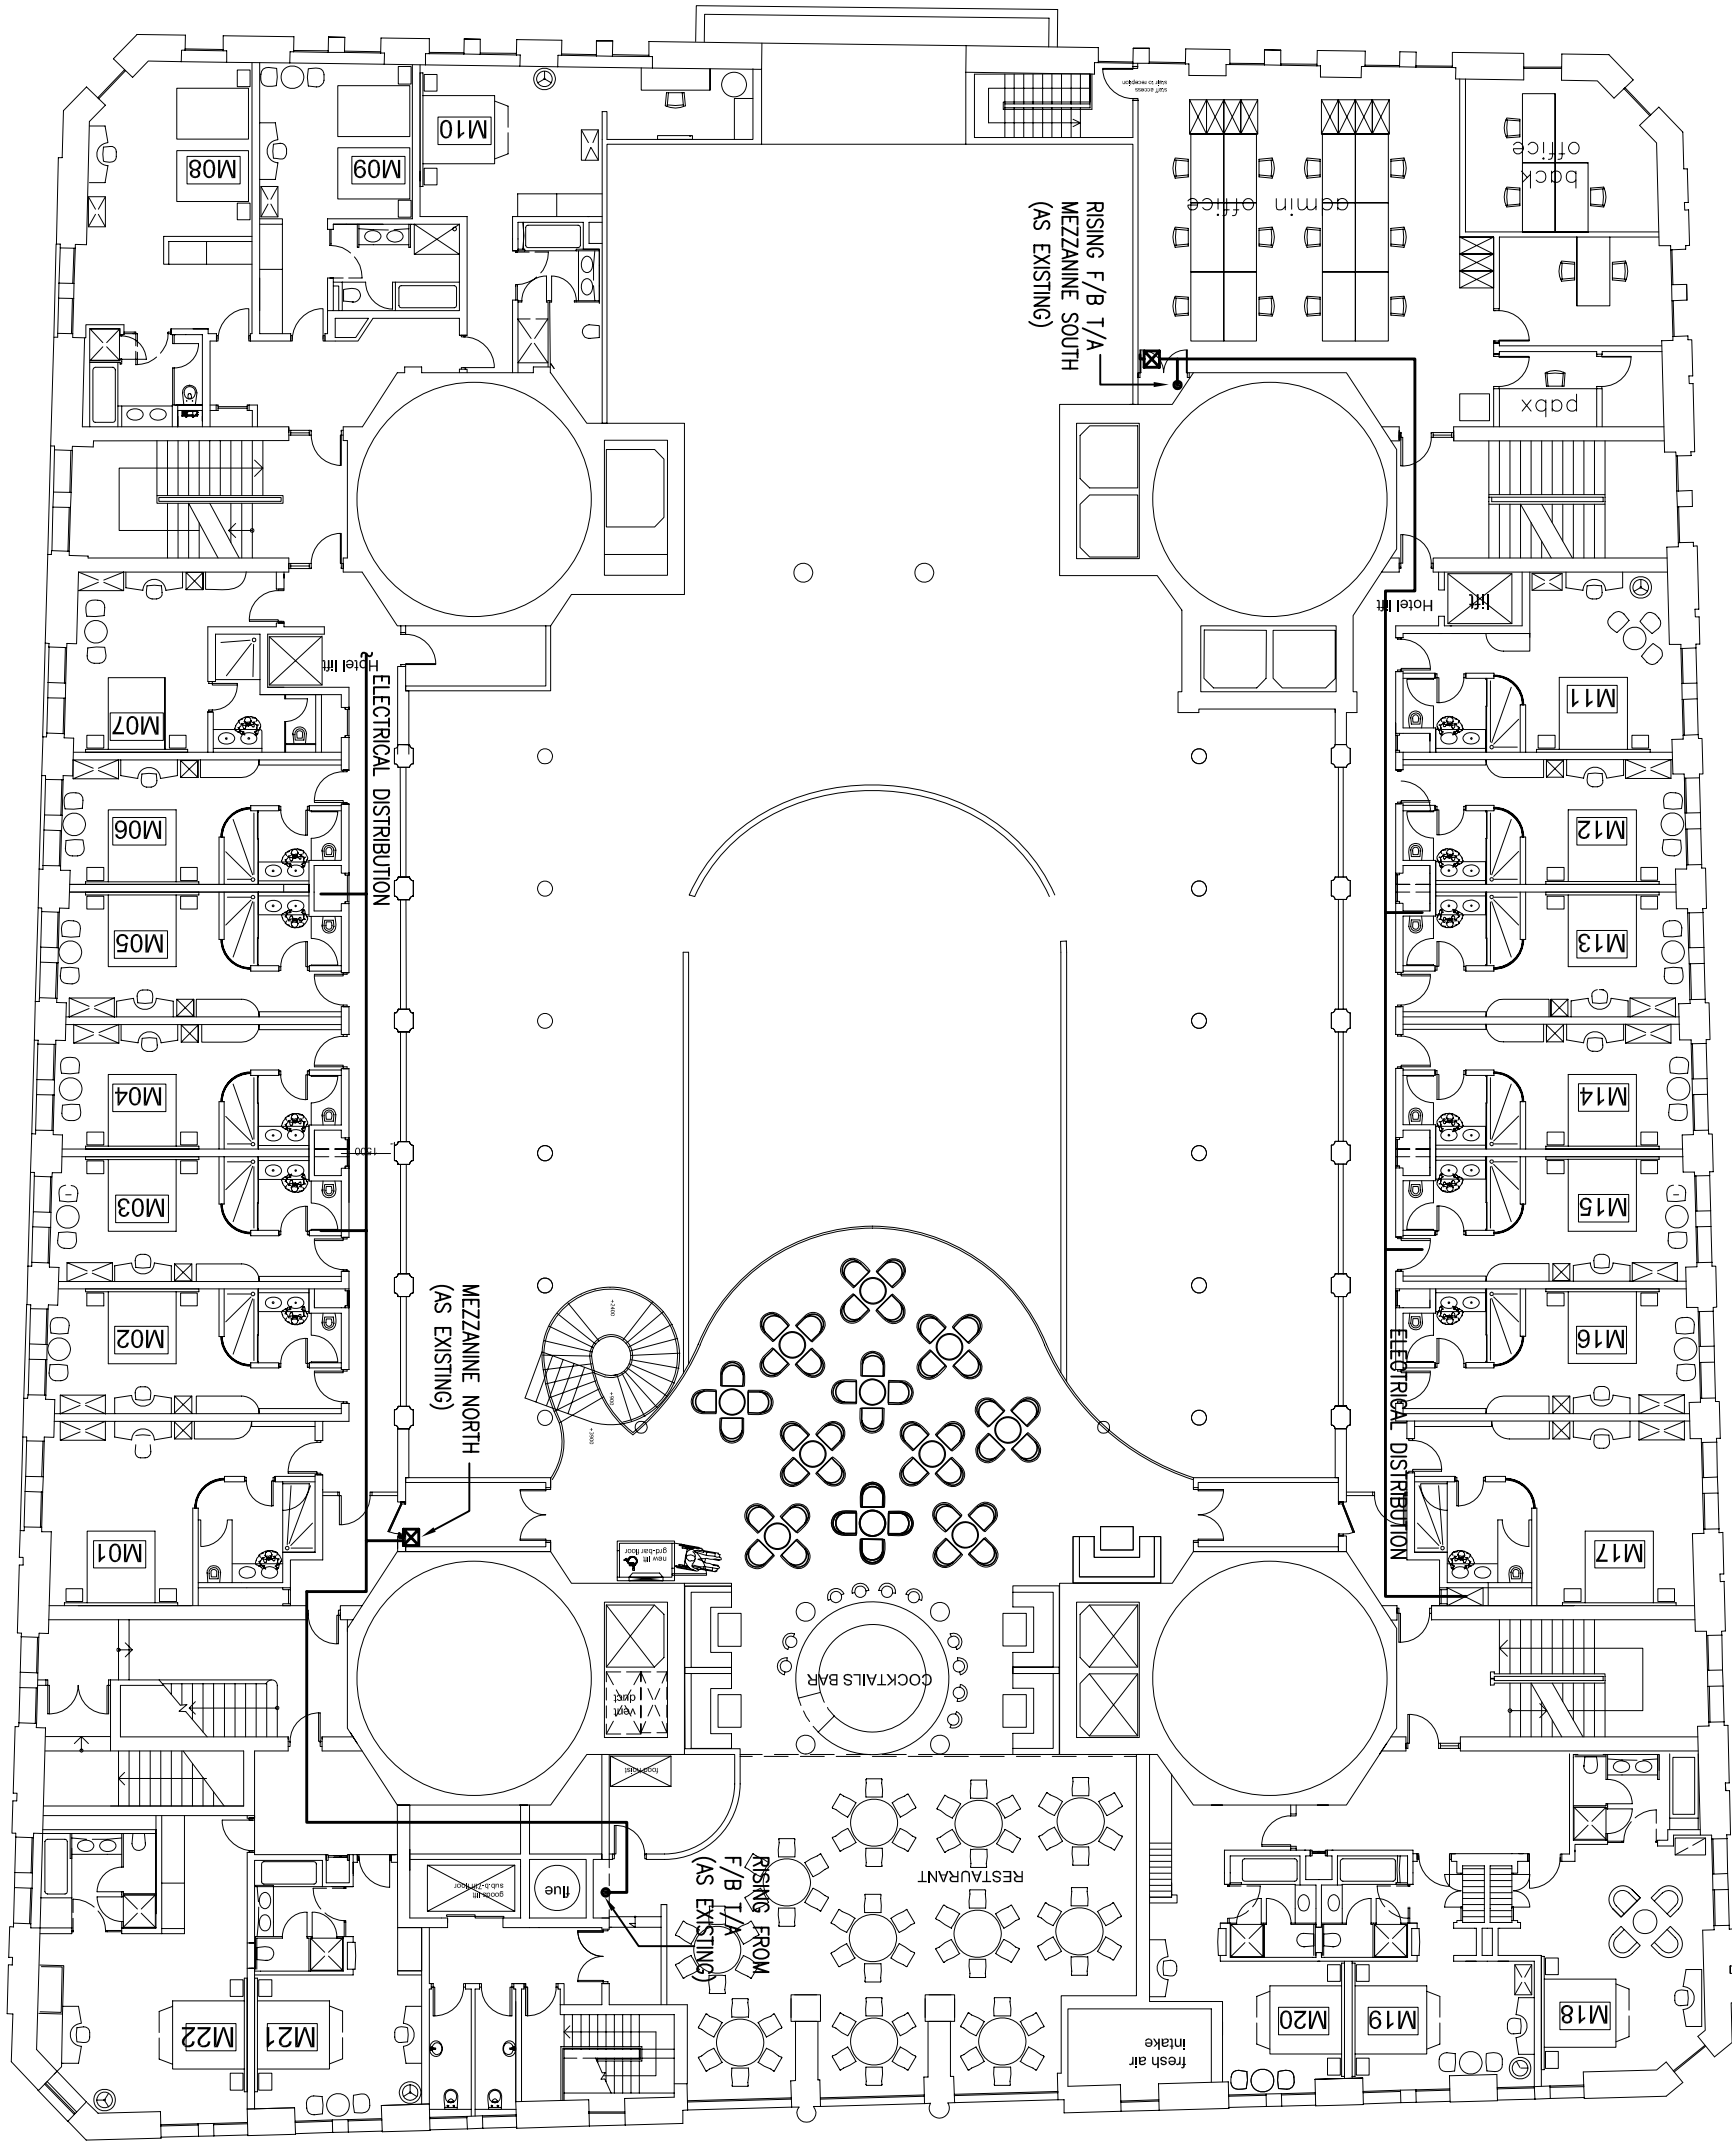

EXCHANGE STREET WEST

EXCHANGE PASSAGE WEST

NOTES.

LEGEND.

P2	15.01.10	REVISED IN LINE WITH ARCHITECTS COMMENTS
P1		PRELIMINARY ISSUE. FOR COMMENT
Rev	Date	Description
Chkd		

HFM Consulting Engineers

1st Floor,  
Courtiels House,  
38 King Street West,  
Manchester  
M3 2WZ

Tel: 0161 833 1410  
Fax: 0161 833 1412



Also At:  
Second Floor, Century Buildings, 31, North John Street, Liverpool, L2 6RG  
Tel: 0151 255 2700 Fax: 0151 255 2701

Project  
MARTINS BANK BUILDING  
LIVERPOOL

Title  
MEZZANINE FLOOR INDICATIVE ELECTRICAL LAYOUT

Engineer	PH	Checked	
Job No	L/1247	Date	04.12.09
Drawing No.		Rev.	P2
L / 1247 / E / 203		Scale	1:200 @A3