




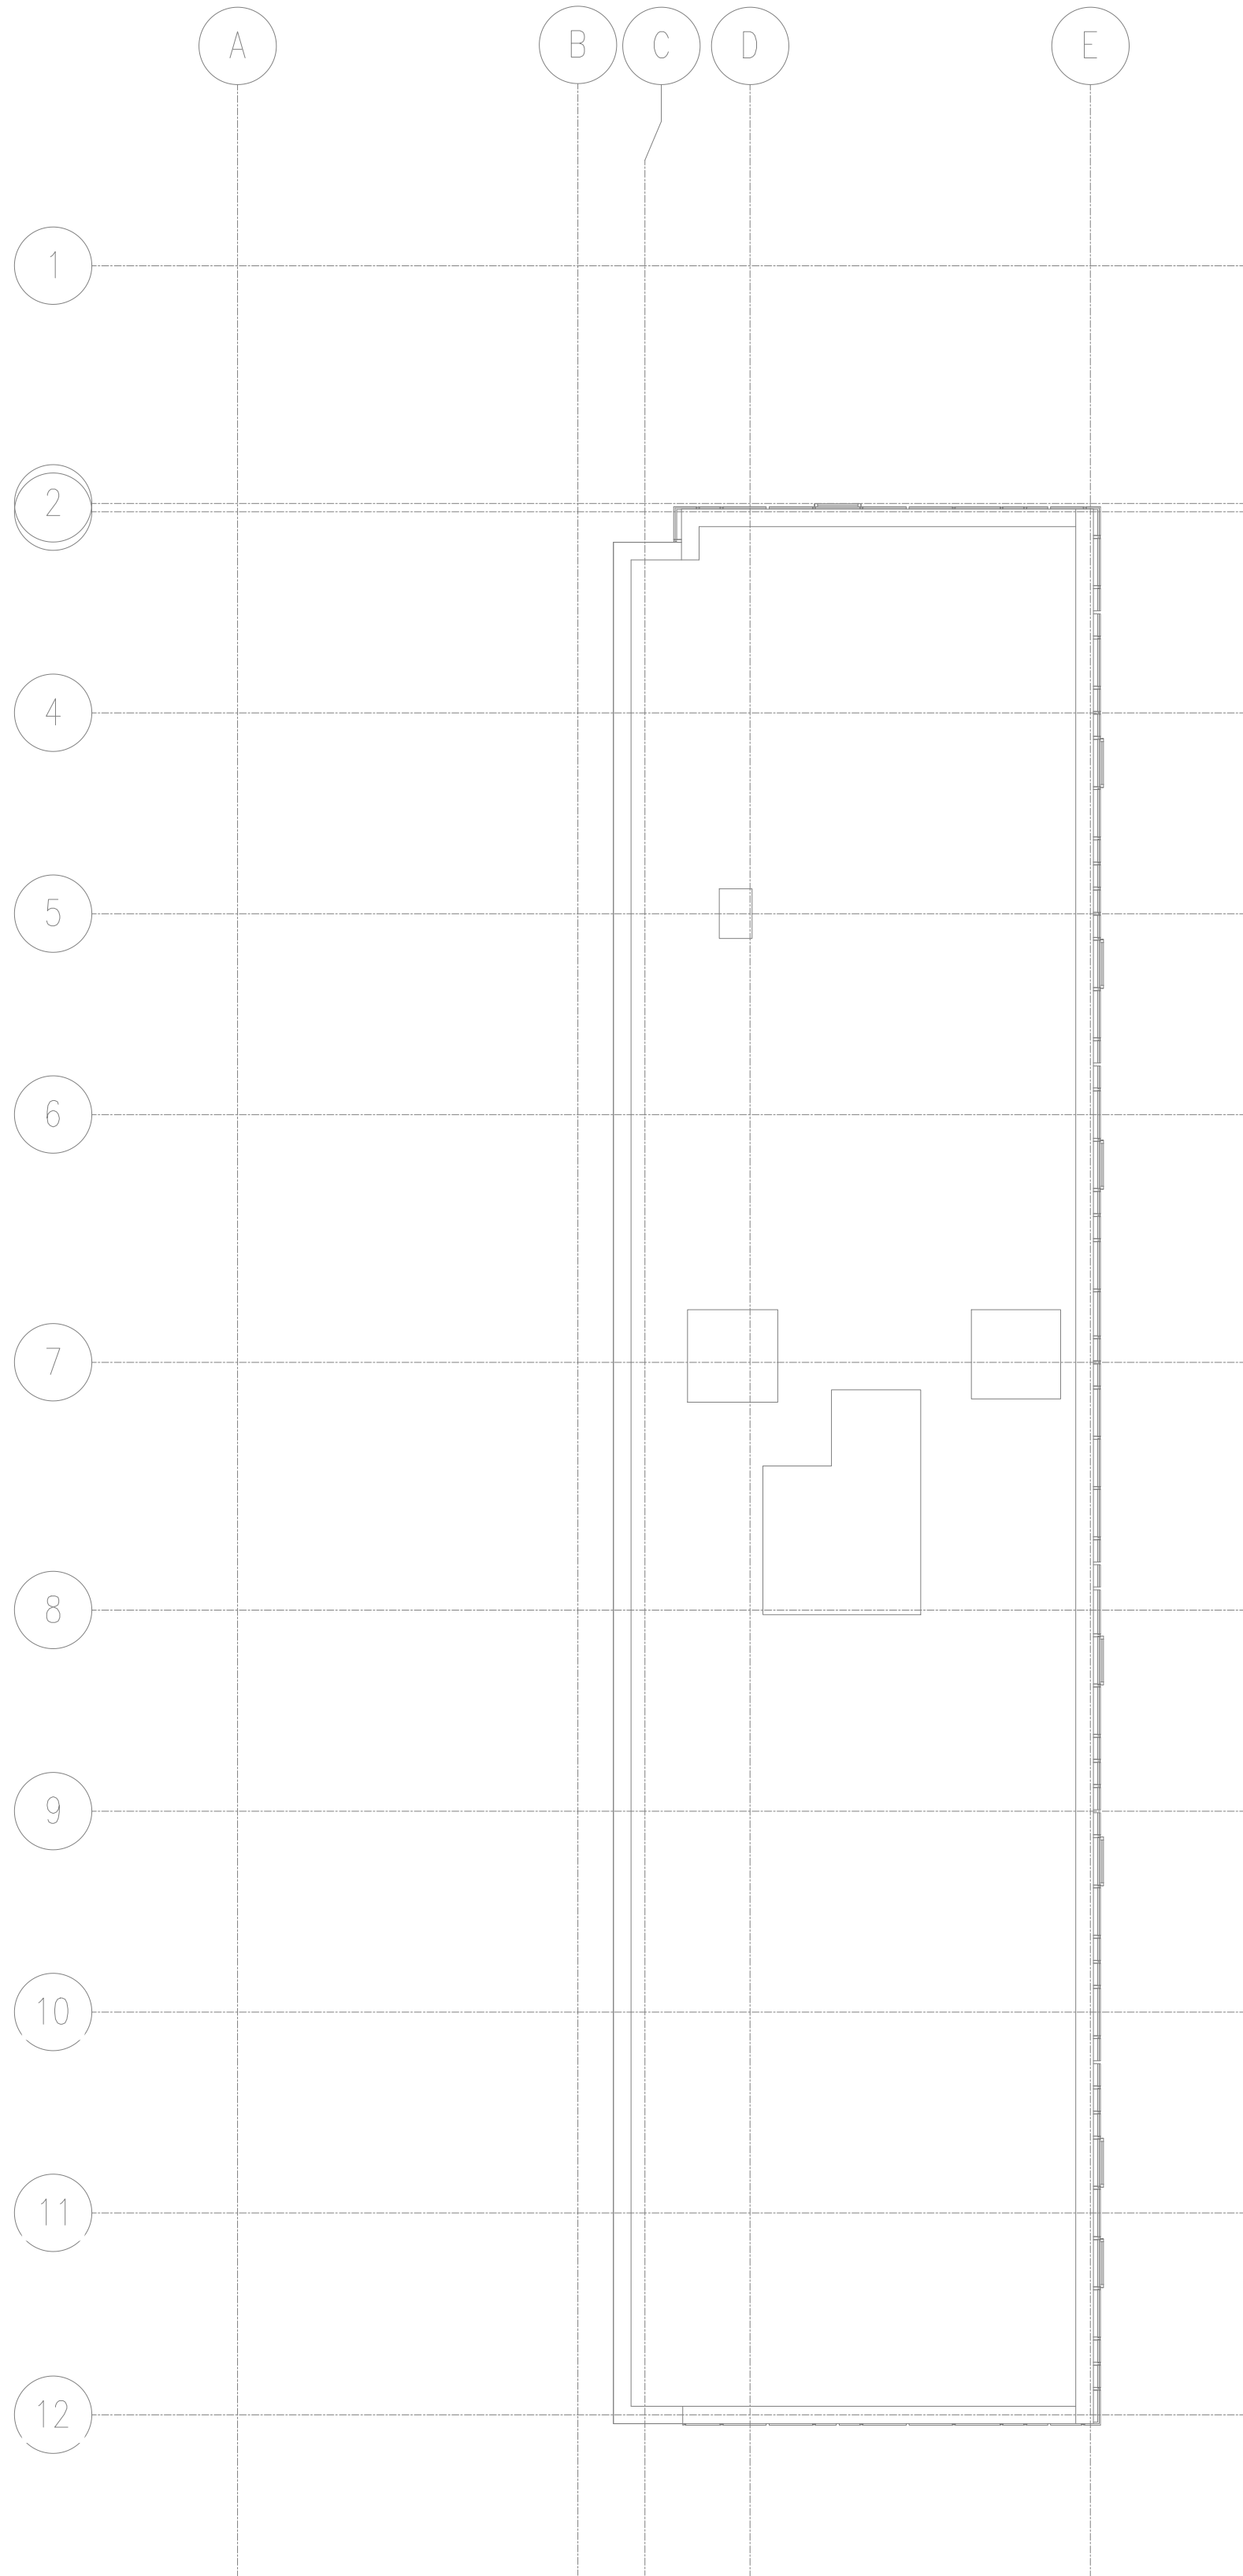

BLOCK 'C'

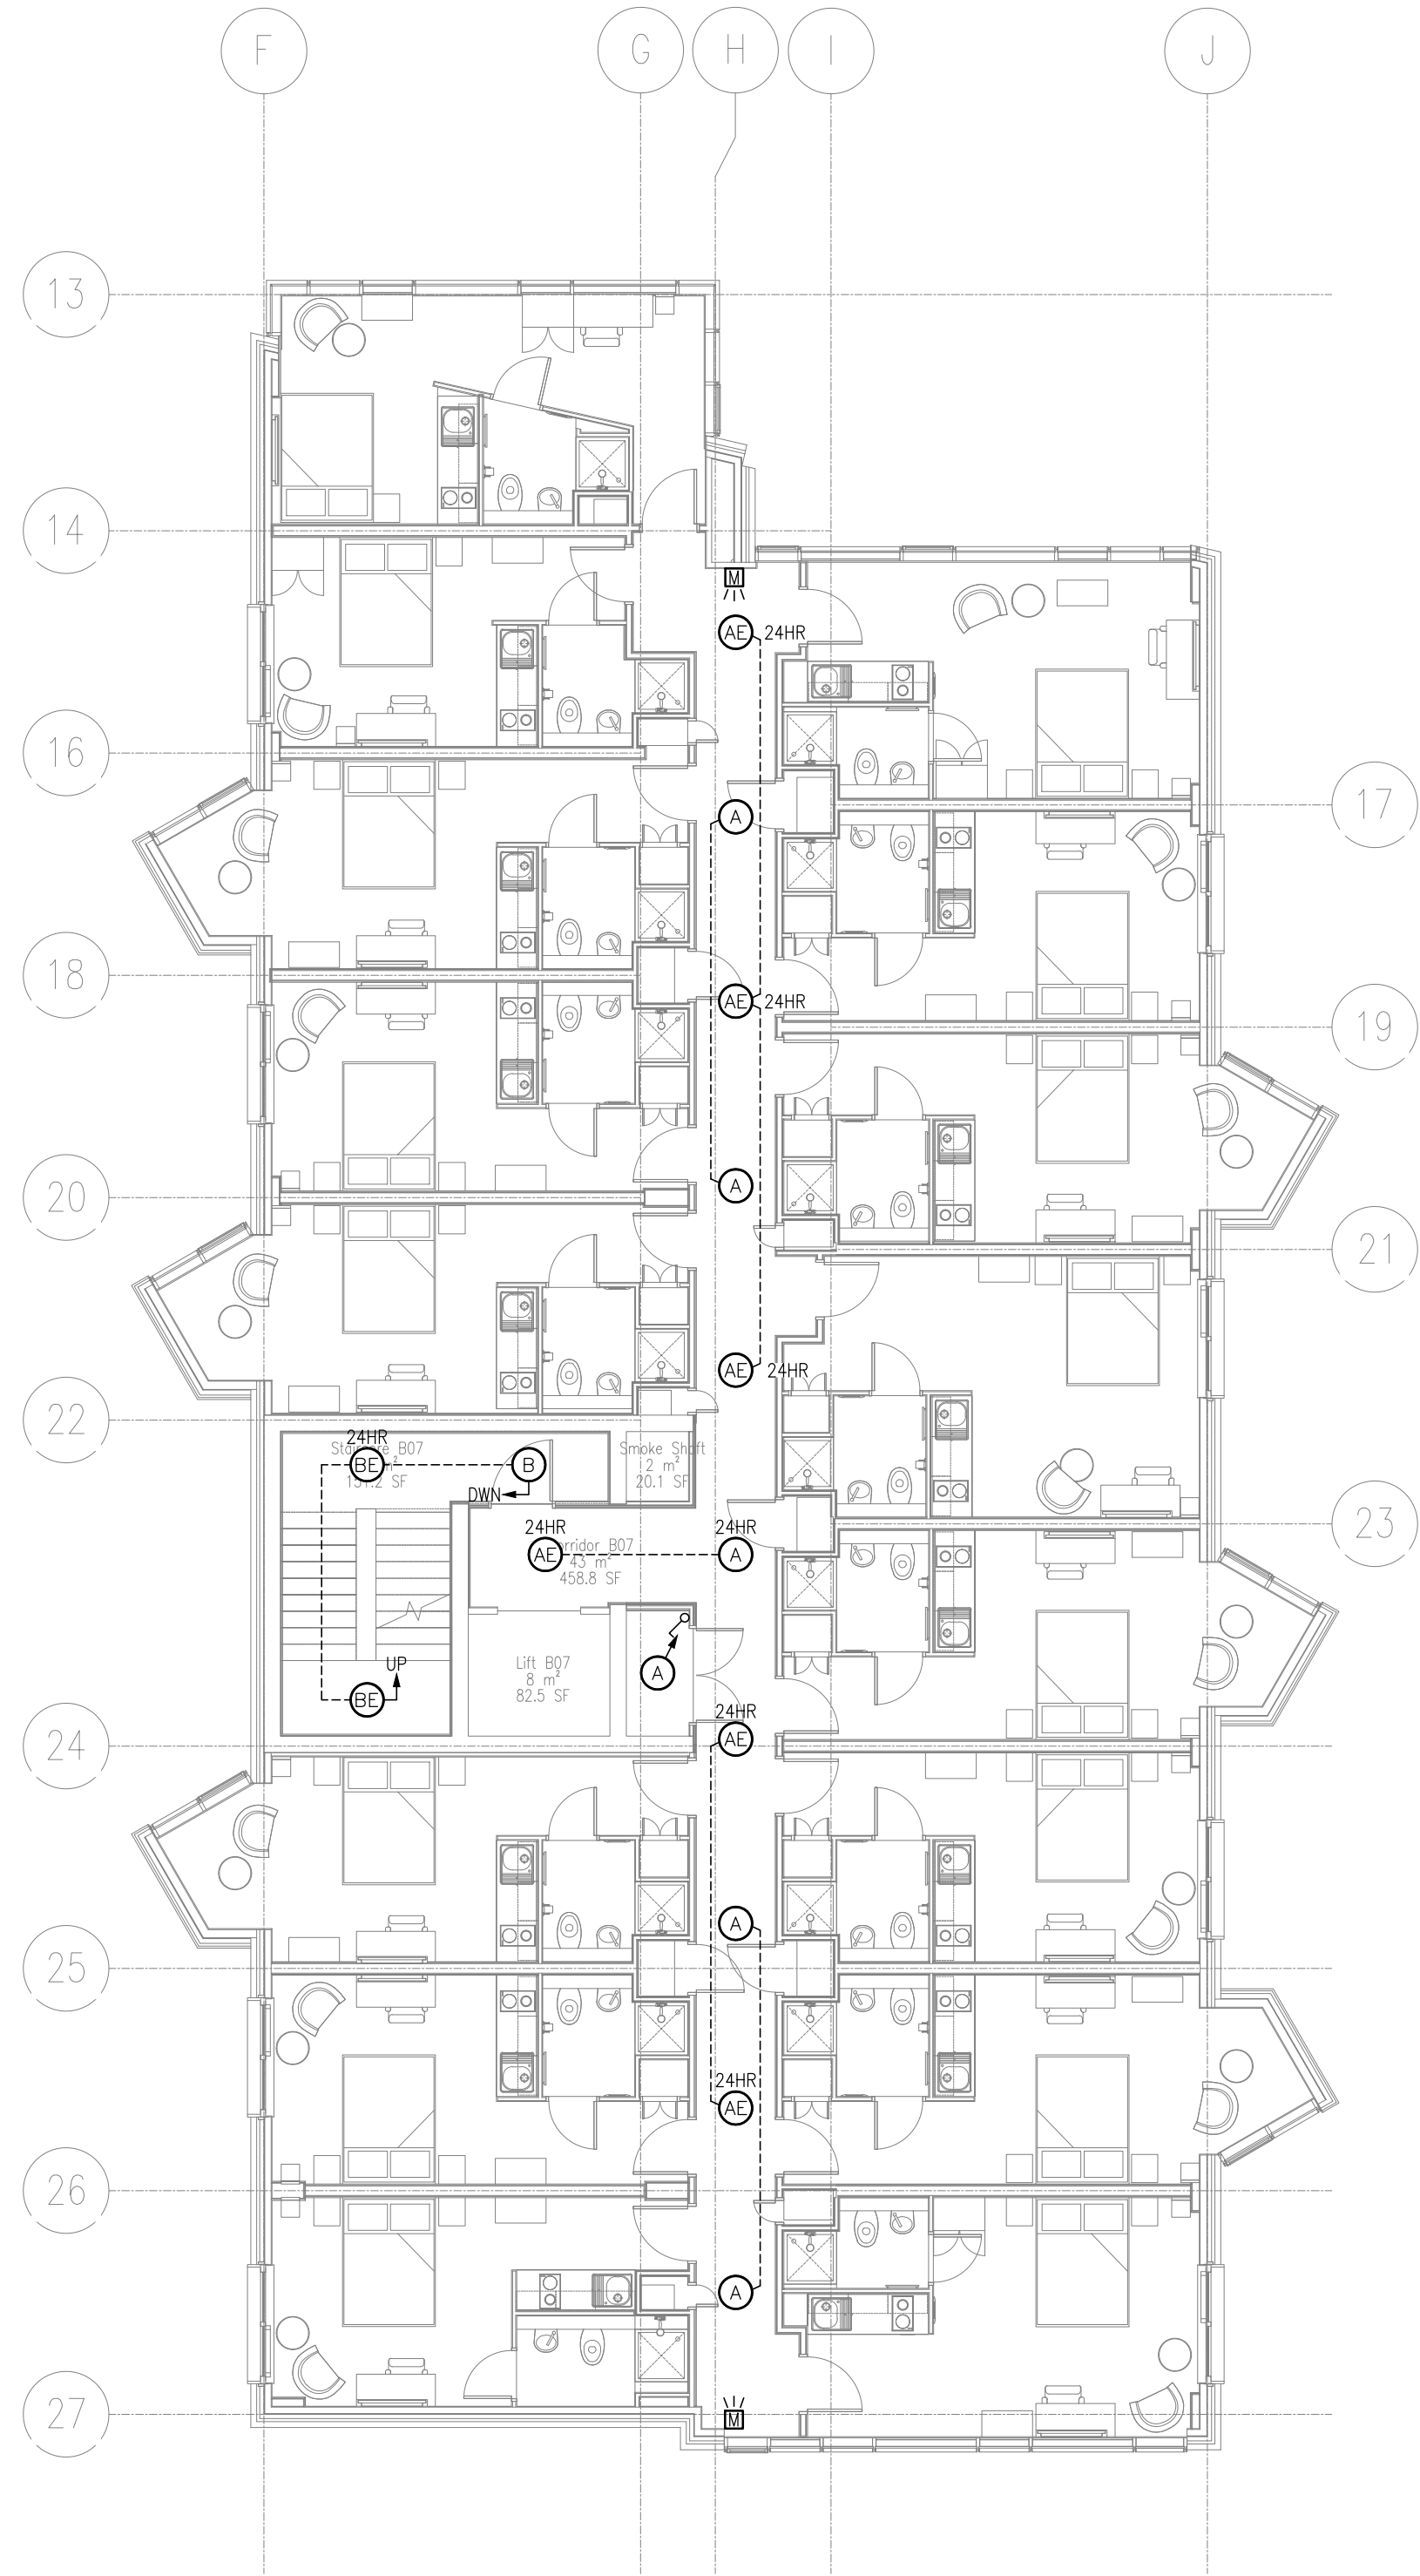

BLOCK 'B'

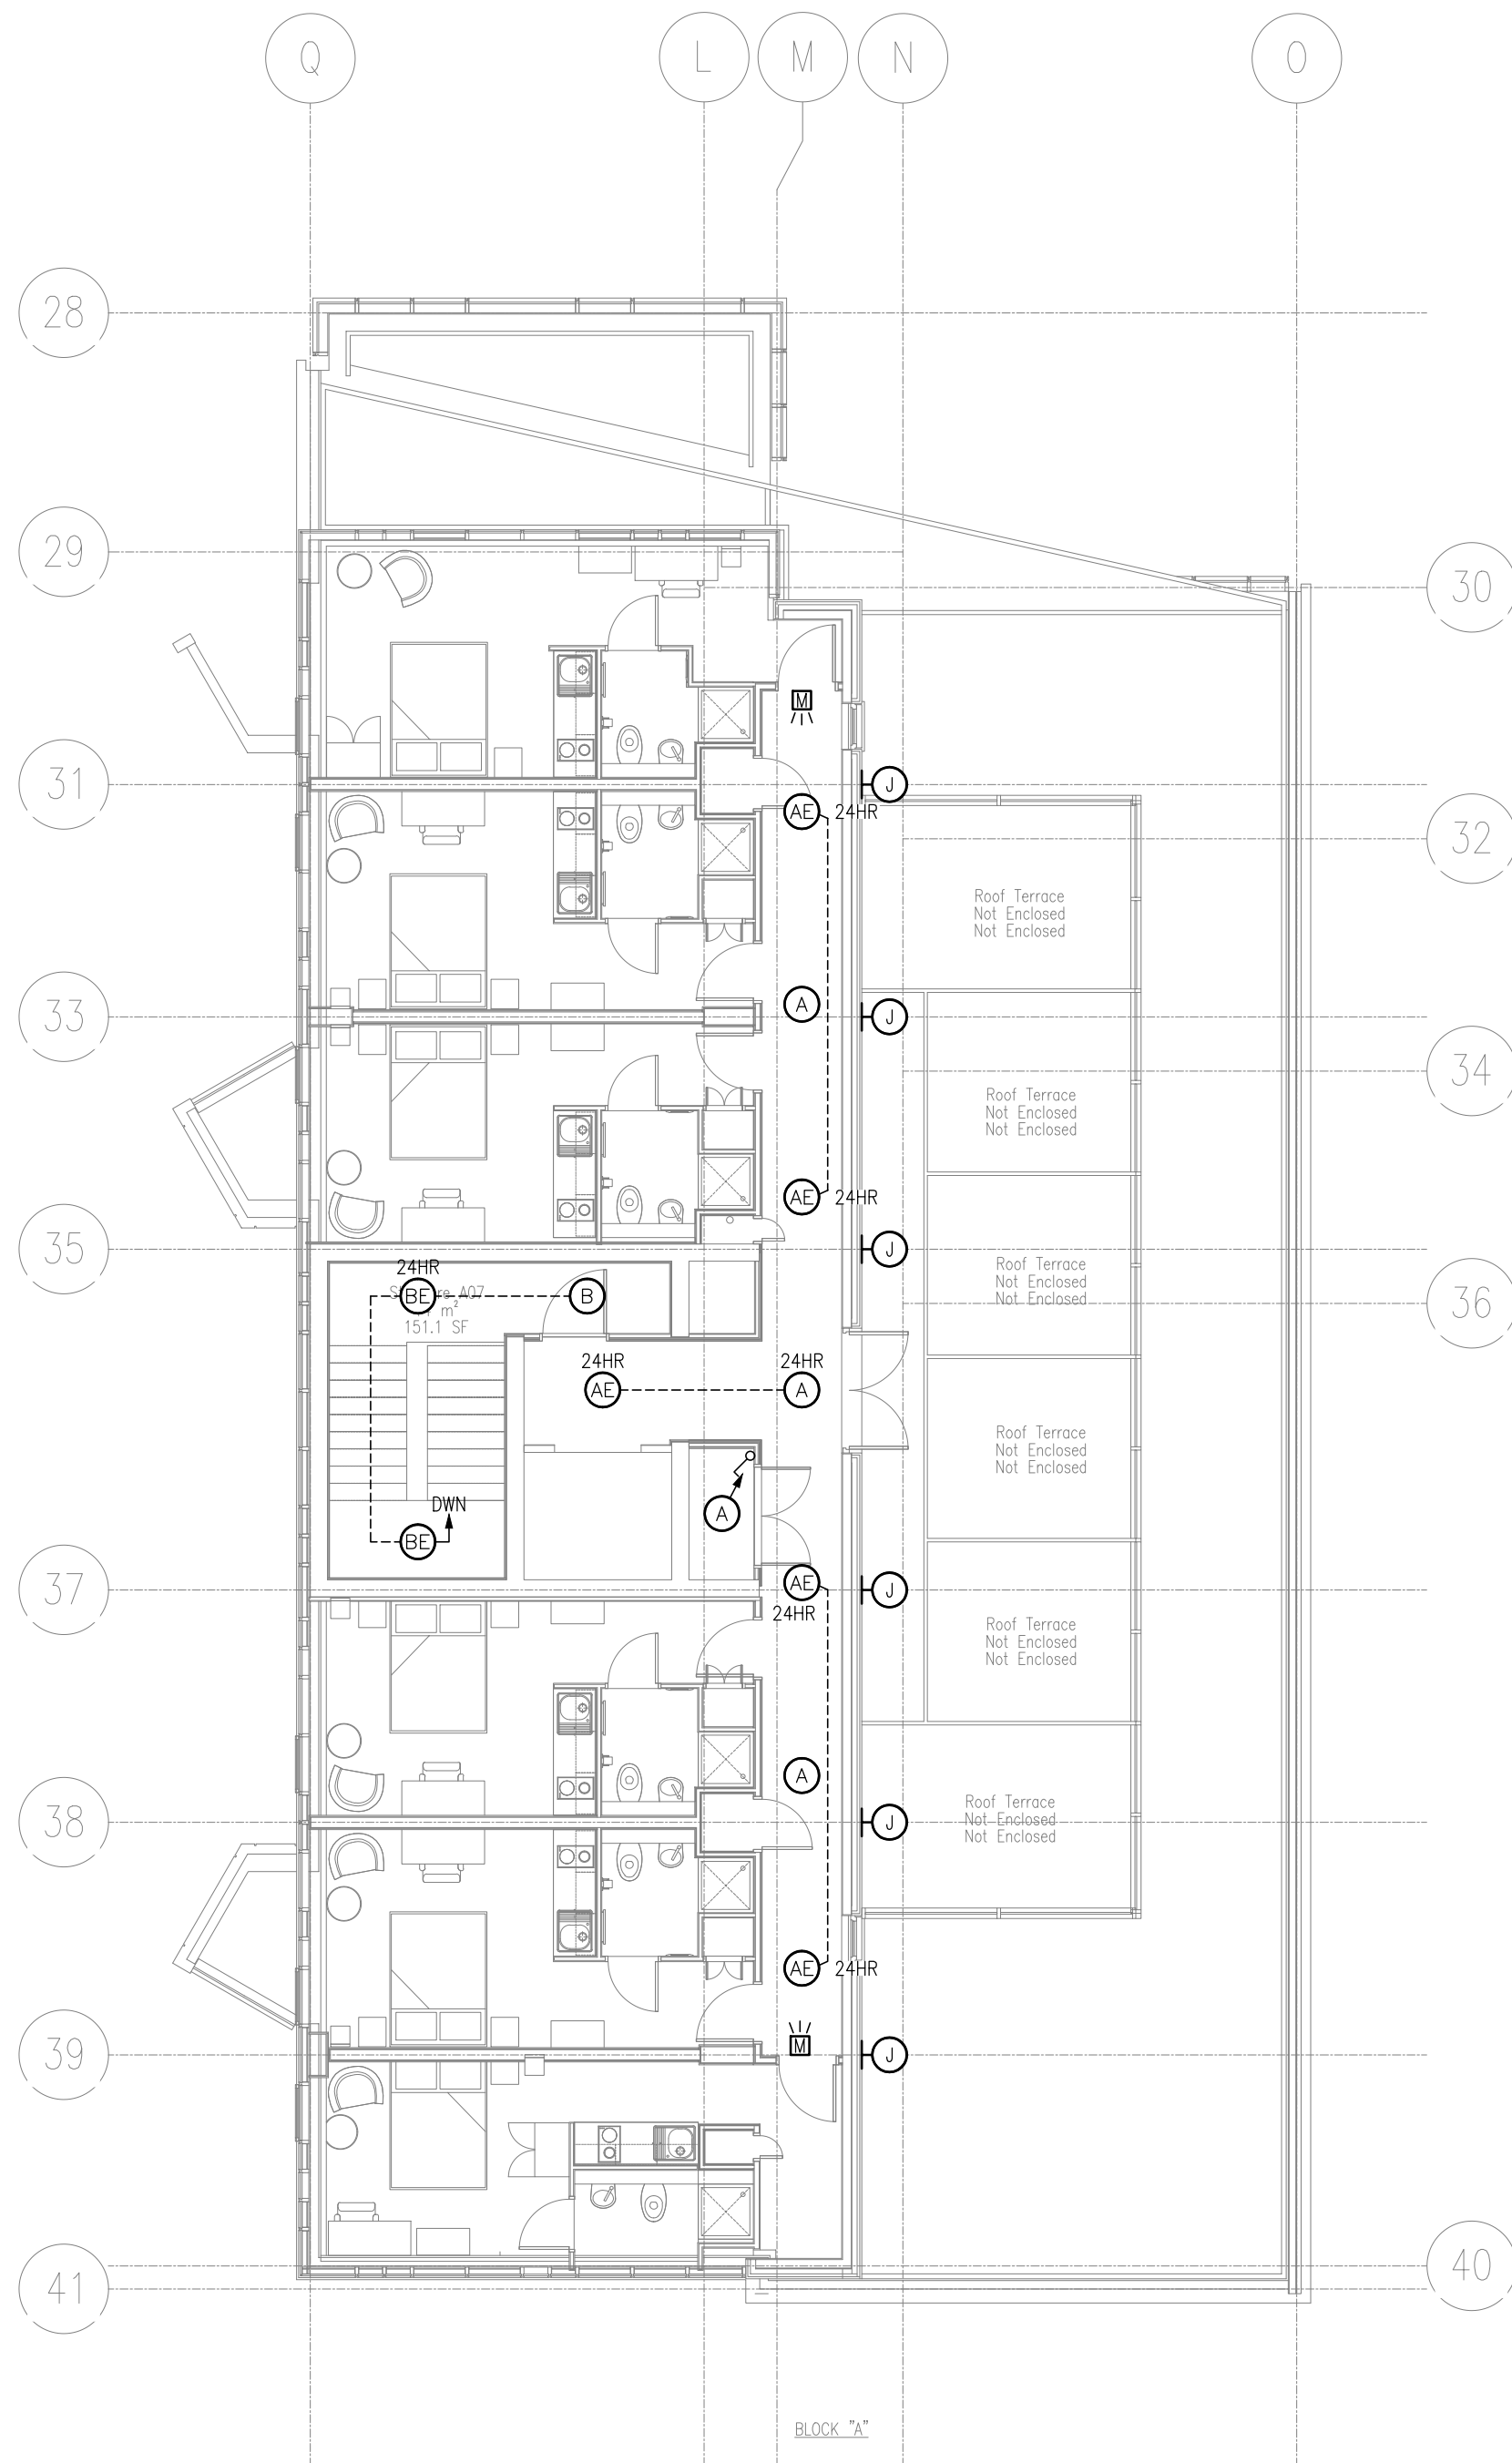

BLOCK 'A'

CDM NOTES:

1. WORKING FROM HEIGHT – USE OF SAFE WORKING PLATFORMS TO BE USED.
2. WORKING AT HEIGHT – RISK OF TOOLS OR EQUIPMENT BEING DROPPED ONTO OPERATIVES BELOW – RESTRICT ACCESS TO AREAS DIRECTLY BELOW WHERE WORKS ARE BEING CARRIED OUT.
3. INSTALL SERVICES WITHIN CEILING AND CEILING/SERVICE VOIDS – RISK OF FALL, INHALATION OF DUST FIBRES – SUITABLE USE OF SAFE PLATFORMS AND USE ADDITIONAL PPE IE DUST MASKS, GLOVES ETC.
4. USE OF HAZARDOUS MATERIALS – HAZARDOUS MATERIALS HAVE NOT BEEN SPECIFIED IN THE NEW WORKS. COSHH SHEETS TO BE PROVIDED WHERE APPLICABLE AND SUITABLE PPE TO BE USED BY STAFF.
5. MANUAL HANDLING OF PLANT AND EQUIPMENT – EQUIPMENT IS GENERALLY SMALL ENOUGH TO BE SUITABLE FOR MANUAL HANDLING. MECHANICAL MEANS TO BE USED TO LIFT LARGER ITEMS
6. CUTTING, DRILLING ETC, OF METALWORKS SUCH AS TRAY CONDUIT TRUNKING ETC – NORMAL SAFETY PROCEDURES TO BE USED, PROVIDE PROTECTIVE CLOTHING GOGGLES ETC.

Materials/Installation Notes

Legend

- A NVC PORTLAND 18W LED OPAL AMENITY FITTING
- B NVC 22W LED ADDISON SURFACE MOUNTED WHITE OPAL CIRCULAR FITTING
- C NVC 49W HF ALASKA V2 T5 SURFACE MOUNTED LINEAR FITTING
- D NVC 4x14W RUSHMORE RECESSED MODULAR FITTING
- D1 AS FITTING 'D' BUT 2x14W
- F NVC WINCHESTER 1100LUMENS RECESSED DOWNLIGHT
- F1 NVC WINCHESTER 2300LUMENS RECESSED DOWNLIGHT
- G NVC DALLAS 2x55W T5 SUSPEND MOUNTED FITTING
- H WHITECROFT 35W BOARDWALK BOLLARD C/W ROOT MOUNT.
- J LIGHTING MOTION UP/DOWNLIGHT
- M RECESSED NON MAINTAINED LED EMERGENCY FITTING
- E SUFFIX 'E' DENOTES FITTING WITH 3HR EMERGENCY FACILITY
- EXIT WALL MOUNTED EMERGENCY EXIT FITTING WITH RUNNING MAIN LOGO & EXIT LEGEND
- EL EXTERNAL WALL MOUNTED EMERGENCY BULKHEAD FITTING
- CEILING MOUNTED 360° PIR LIGHT SENSOR
- CEILING MOUNTED MICROWAVE SENSOR
- WALL MOUNTED LIGHT SWITCH MOUNTED AT 1100mm AFLL (GANGED AS INDICATED)

Revisions

Rev.	Date.	Description	Init
P1	23-12-14	ISSUED FOR COMMENT/APPROVAL	L.S.
C1	06-02-15	ISSUED FOR CONSTRUCTION	L.H.
C2	24-04-15	EXTERNAL FITTINGS ADDED	L.H.

Status

CONSTRUCTION

Project

**SEEL STREET
LIVERPOOL ONE**

Title

LEVEL 07

LIGHTING LAYOUT

HE Simm
Engineering Services

Spinnaker House
141 Sefton Street
Liverpool L8 5SN
Tel: 0151-707 3222 Fax: 0151-707 3223
E-Mail: info@hesimm.co.uk

Scale:	Drawn:	Date:
1:100	L.S.	OCT 2014
Paper:	Approved:	X-Ref:
@ A1	L.H.	XR-0251_03_007-SeventhFloorPlan-14-10-28
Drawing No	Rev	

C5135-E-X-(63)-PL-07-01

C2