

NOTES.			
LEGEND.			
E = EXTRACT WINDOW S = SUPPLY WINDOW			
p1	PRELIMINARY ISSUE. FOR COMMENT		
Rev	Date	Description	Chkd
HFM Consulting Engineers			
1st Floor, Courtlets House, 38 King Street West, Manchester M3 2WZ			
Tel: 0161 833 1410 Fax: 0161 833 1412			
Also At: Second Floor, Century Buildings, 31, North John Street, Liverpool, L2 6RG Tel: 0151 255 2700 Fax: 0151 255 2701			
Project MARTINS BANK BUILDING LIVERPOOL			
Title INDICATIVE PROPOSED VENTILATION STRATEGY PROPOSED BASEMENT LEVEL			
Engineer	RG	Checked	JH
Job No	L1245	Date	DEC 2009
Drawing No.	L / 1247 / M / SK200	Rev.	p1
		Scale	1:200 @A3

NOTES.

LEGEND.

- I DESIGNATED EXTRACT LIGHTWELL  
→ I DESIGNATED SUPPLY LIGHTWELL  
HRU1 HEATING RECOVER UNIT  
HRU2 HEATING RECOVER UNIT  
HRU3 HEATING RECOVER UNIT

p1	PRELIMINARY ISSUE. FOR COMMENT		
Rev	Date	Description	Chkd

HFM Consulting Engineers

1st Floor,  
Courtlets House,  
38 King Street West,  
Manchester  
M3 2WZ

Tel: 0161 833 1410  
Fax: 0161 833 1412



Also At:  
Second Floor, Century Buildings, 31, North John Street, Liverpool, L2 6RG  
Tel: 0151 255 2700 Fax: 0151 255 2701


Project  
MARTINS BANK BUILDING  
LIVERPOOL

Title  
INDICATIVE PROPOSED  
VENTILATION STRATEGY  
LOWER GROUND LEVEL


Engineer	RG	Checked	JH
----------	----	---------	----

Job No	L1245	Date	DEC 2009
--------	-------	------	----------

Drawing No.	L /1247 / M /SK201	Rev.	p1
		Scale	1:200 @A3

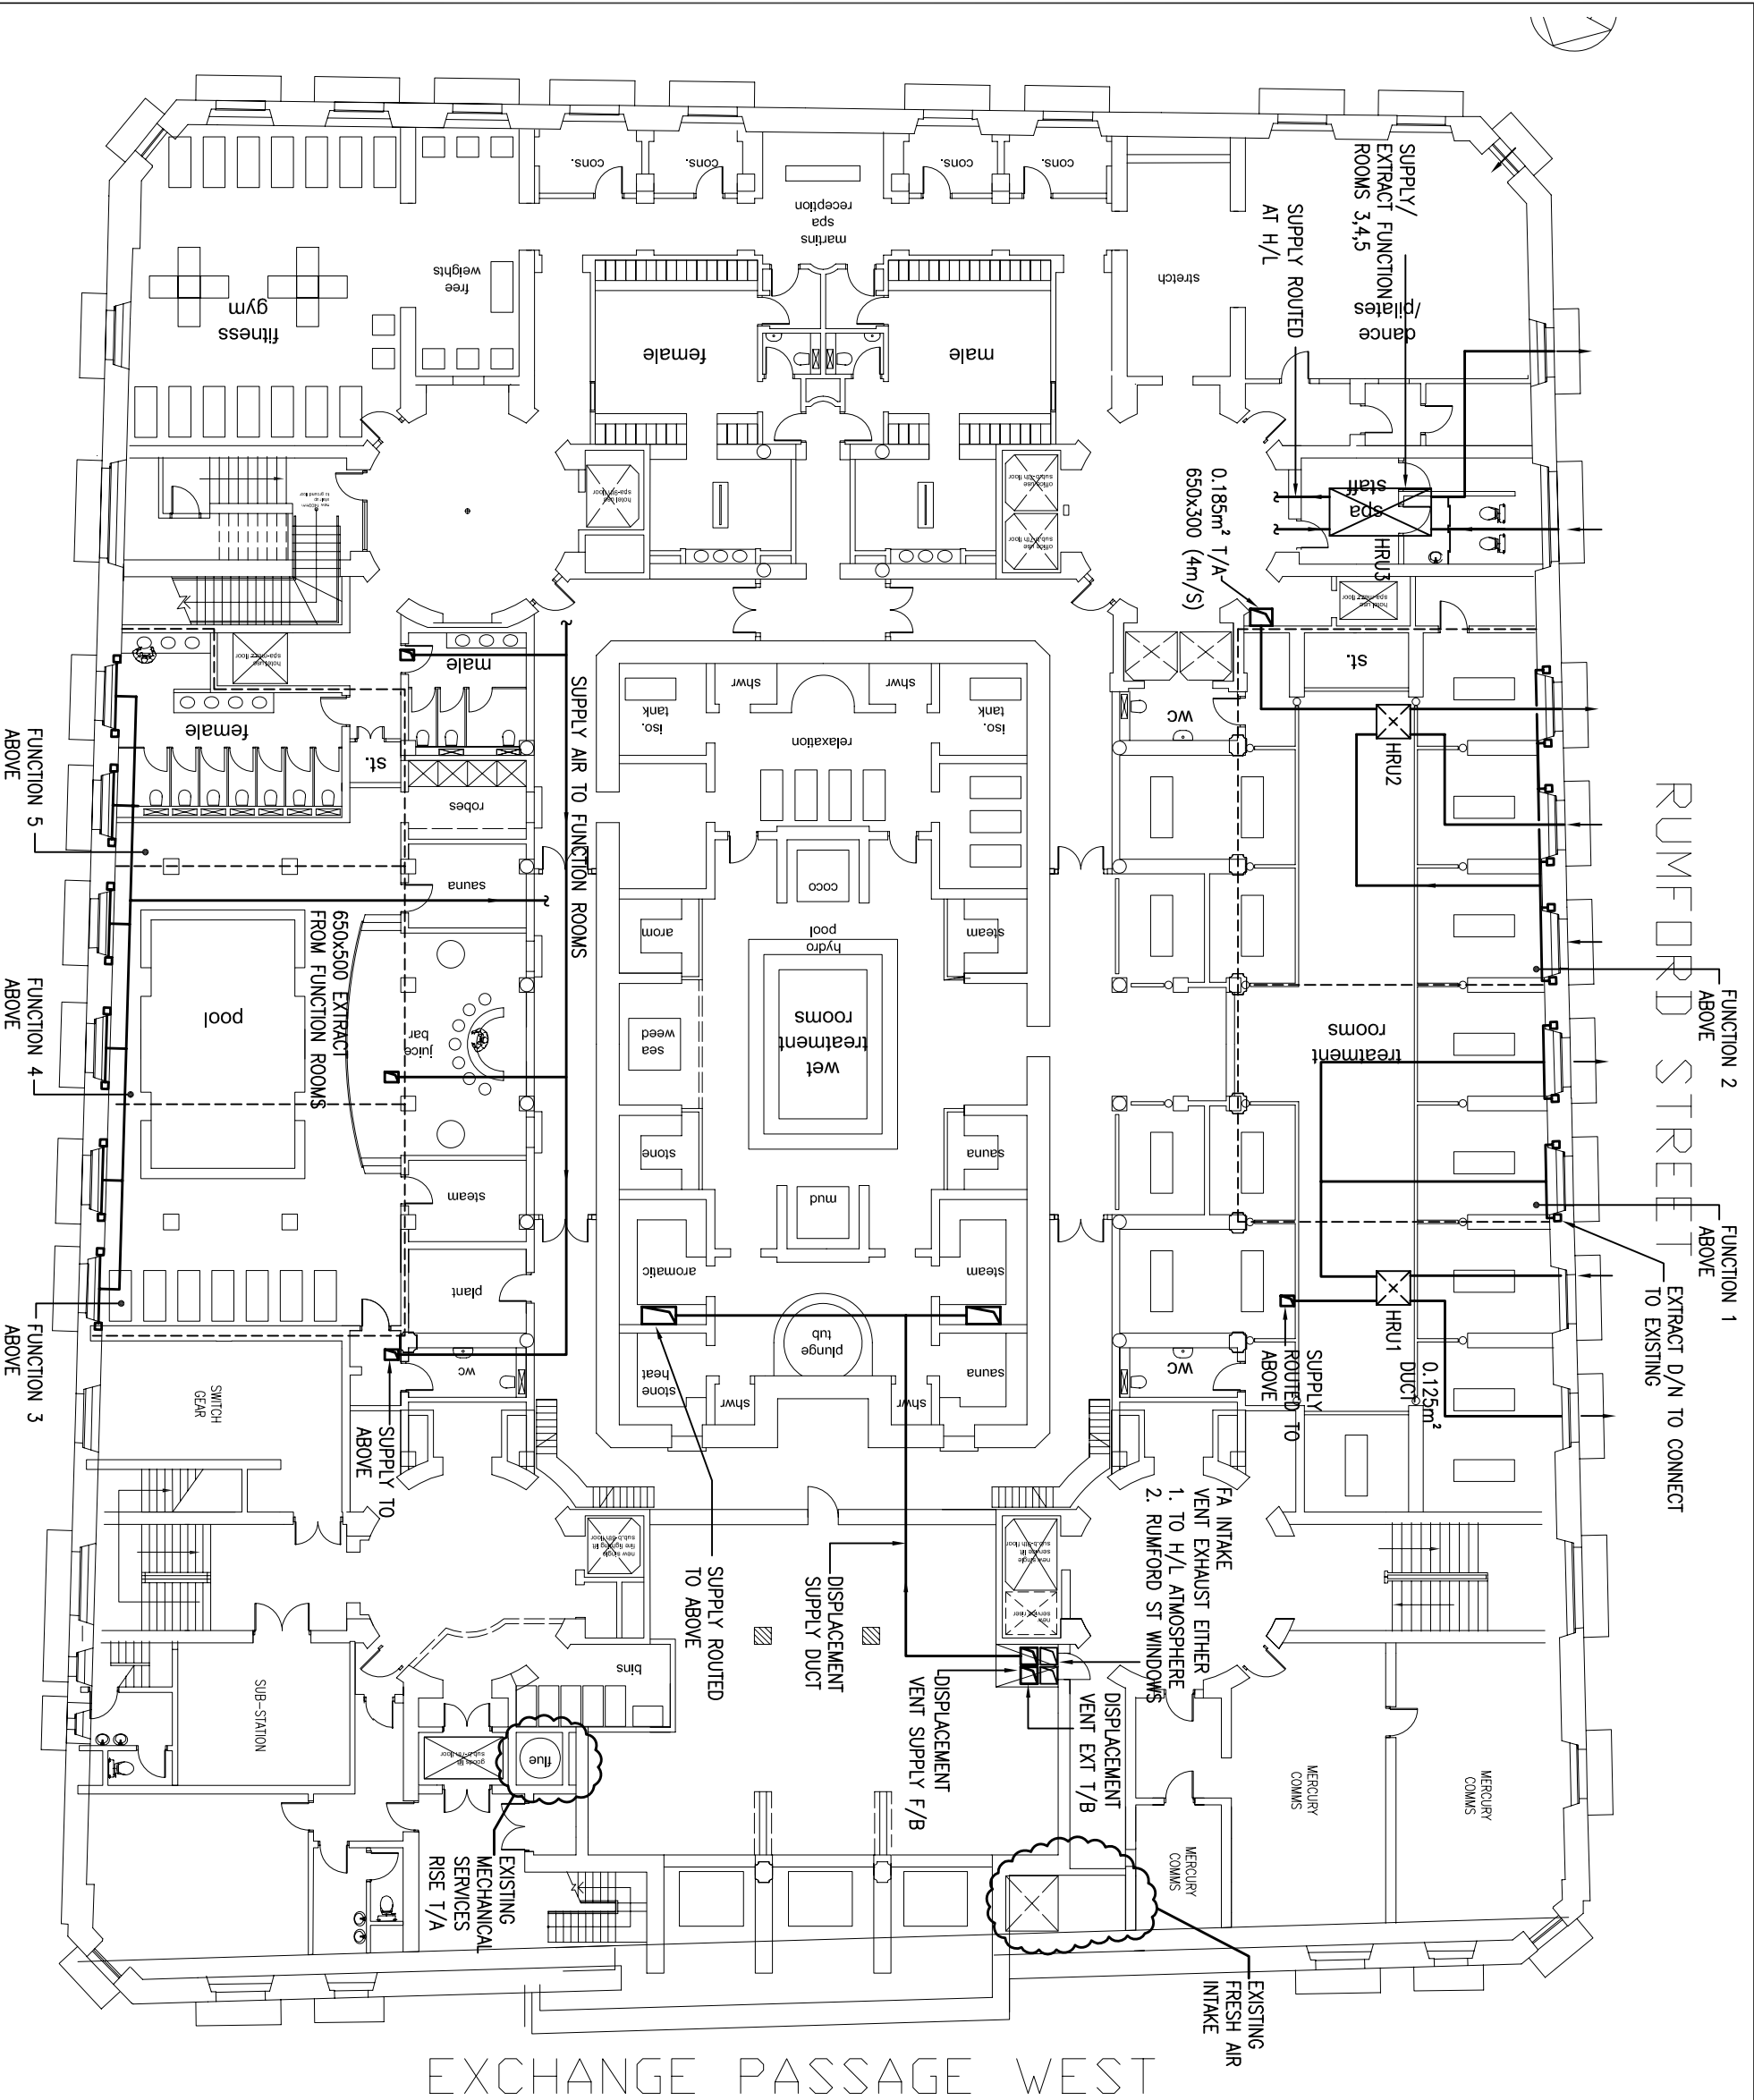

RUMFORD STREET

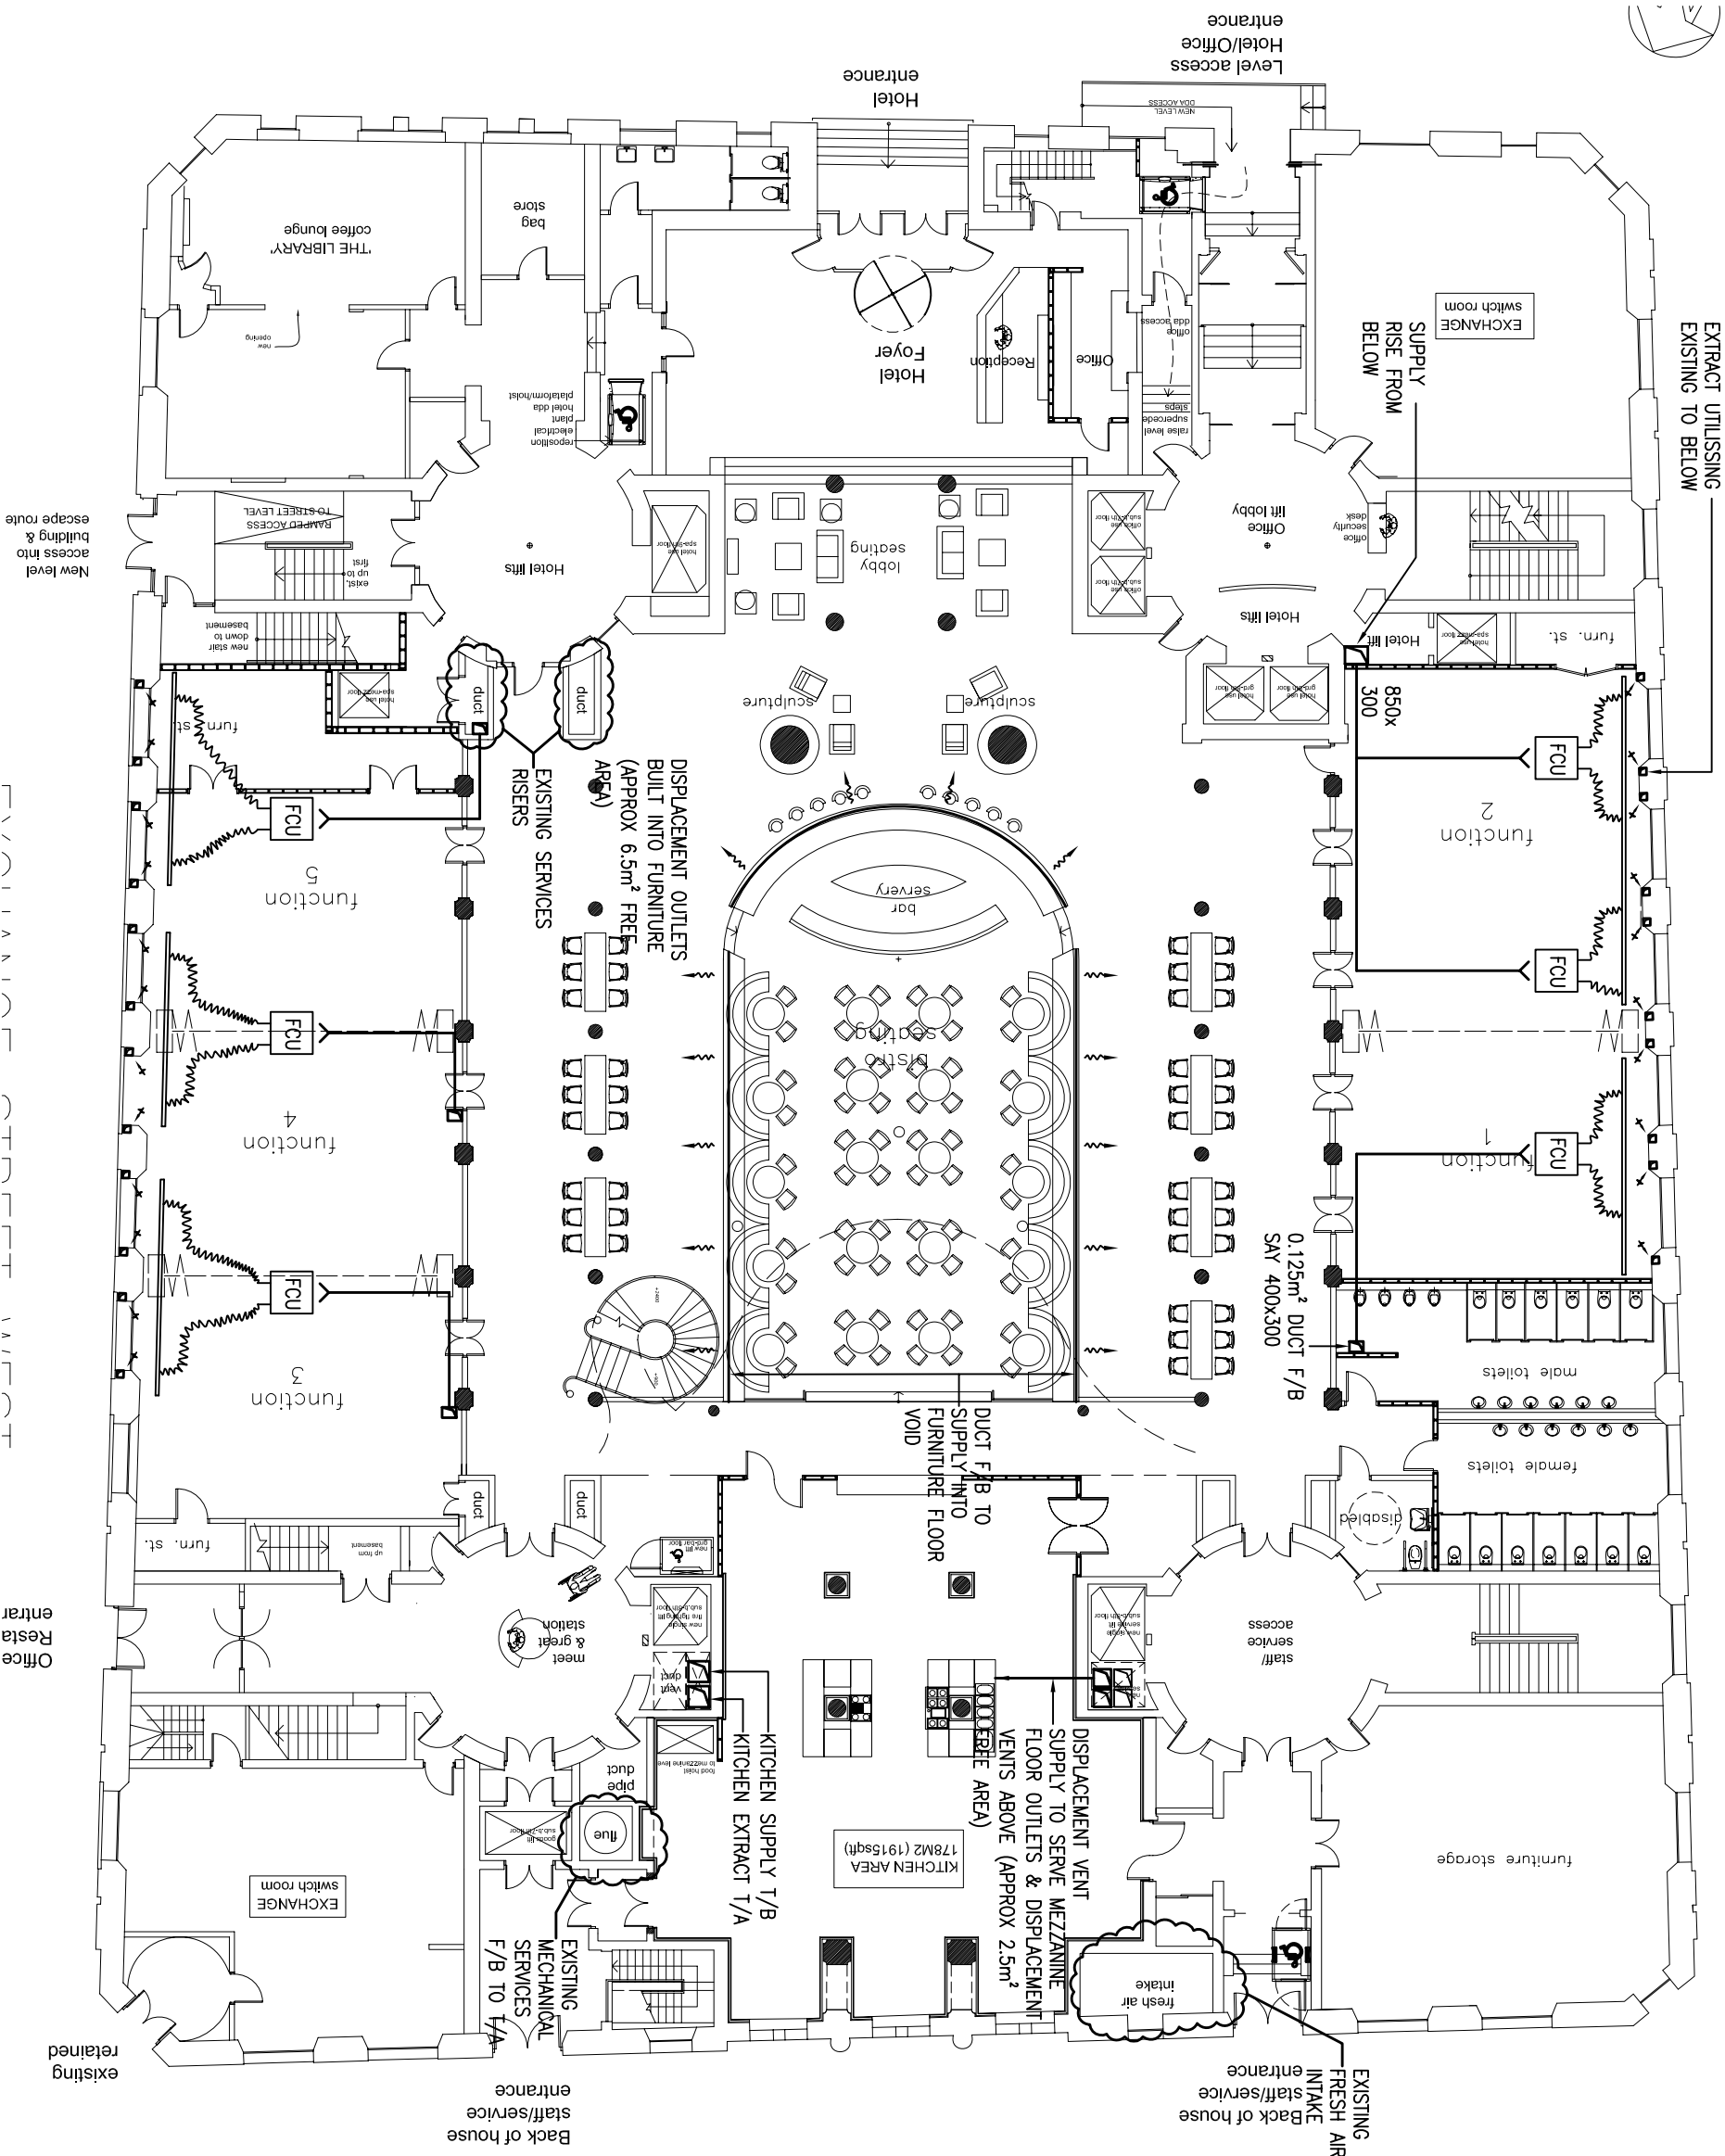

NOTES.

LEGEND.

P2	15.01.10	REVISED IN LINE WITH ARCHITECTS COMMENTS	
P1		PRELIMINARY ISSUE. FOR COMMENT	
Rev	Date	Description	Chkd

HFM Consulting Engineers

1st Floor,  
Courtlets House,  
38 King Street West,  
Manchester  
M3 2WZ  
Tel: 0161 833 1410  
Fax: 0161 833 1412



Also At:  
Second Floor, Century Buildings, 31, North John Street, Liverpool, L2 6RG  
Tel: 0151 255 2700 Fax: 0151 255 2701

Project  
MARTINS BANK BUILDING  
LIVERPOOL

Title  
INDICATIVE PROPOSED  
VENTILATION STRATEGY  
PROPOSED GROUND FLOOR

Engineer RG Checked JH


Job No L1245 Date DEC 2009

Drawing No. Rev. P2

L /1247 / M /SK202 Scale 1:200 @A3



RUMFORD STREET

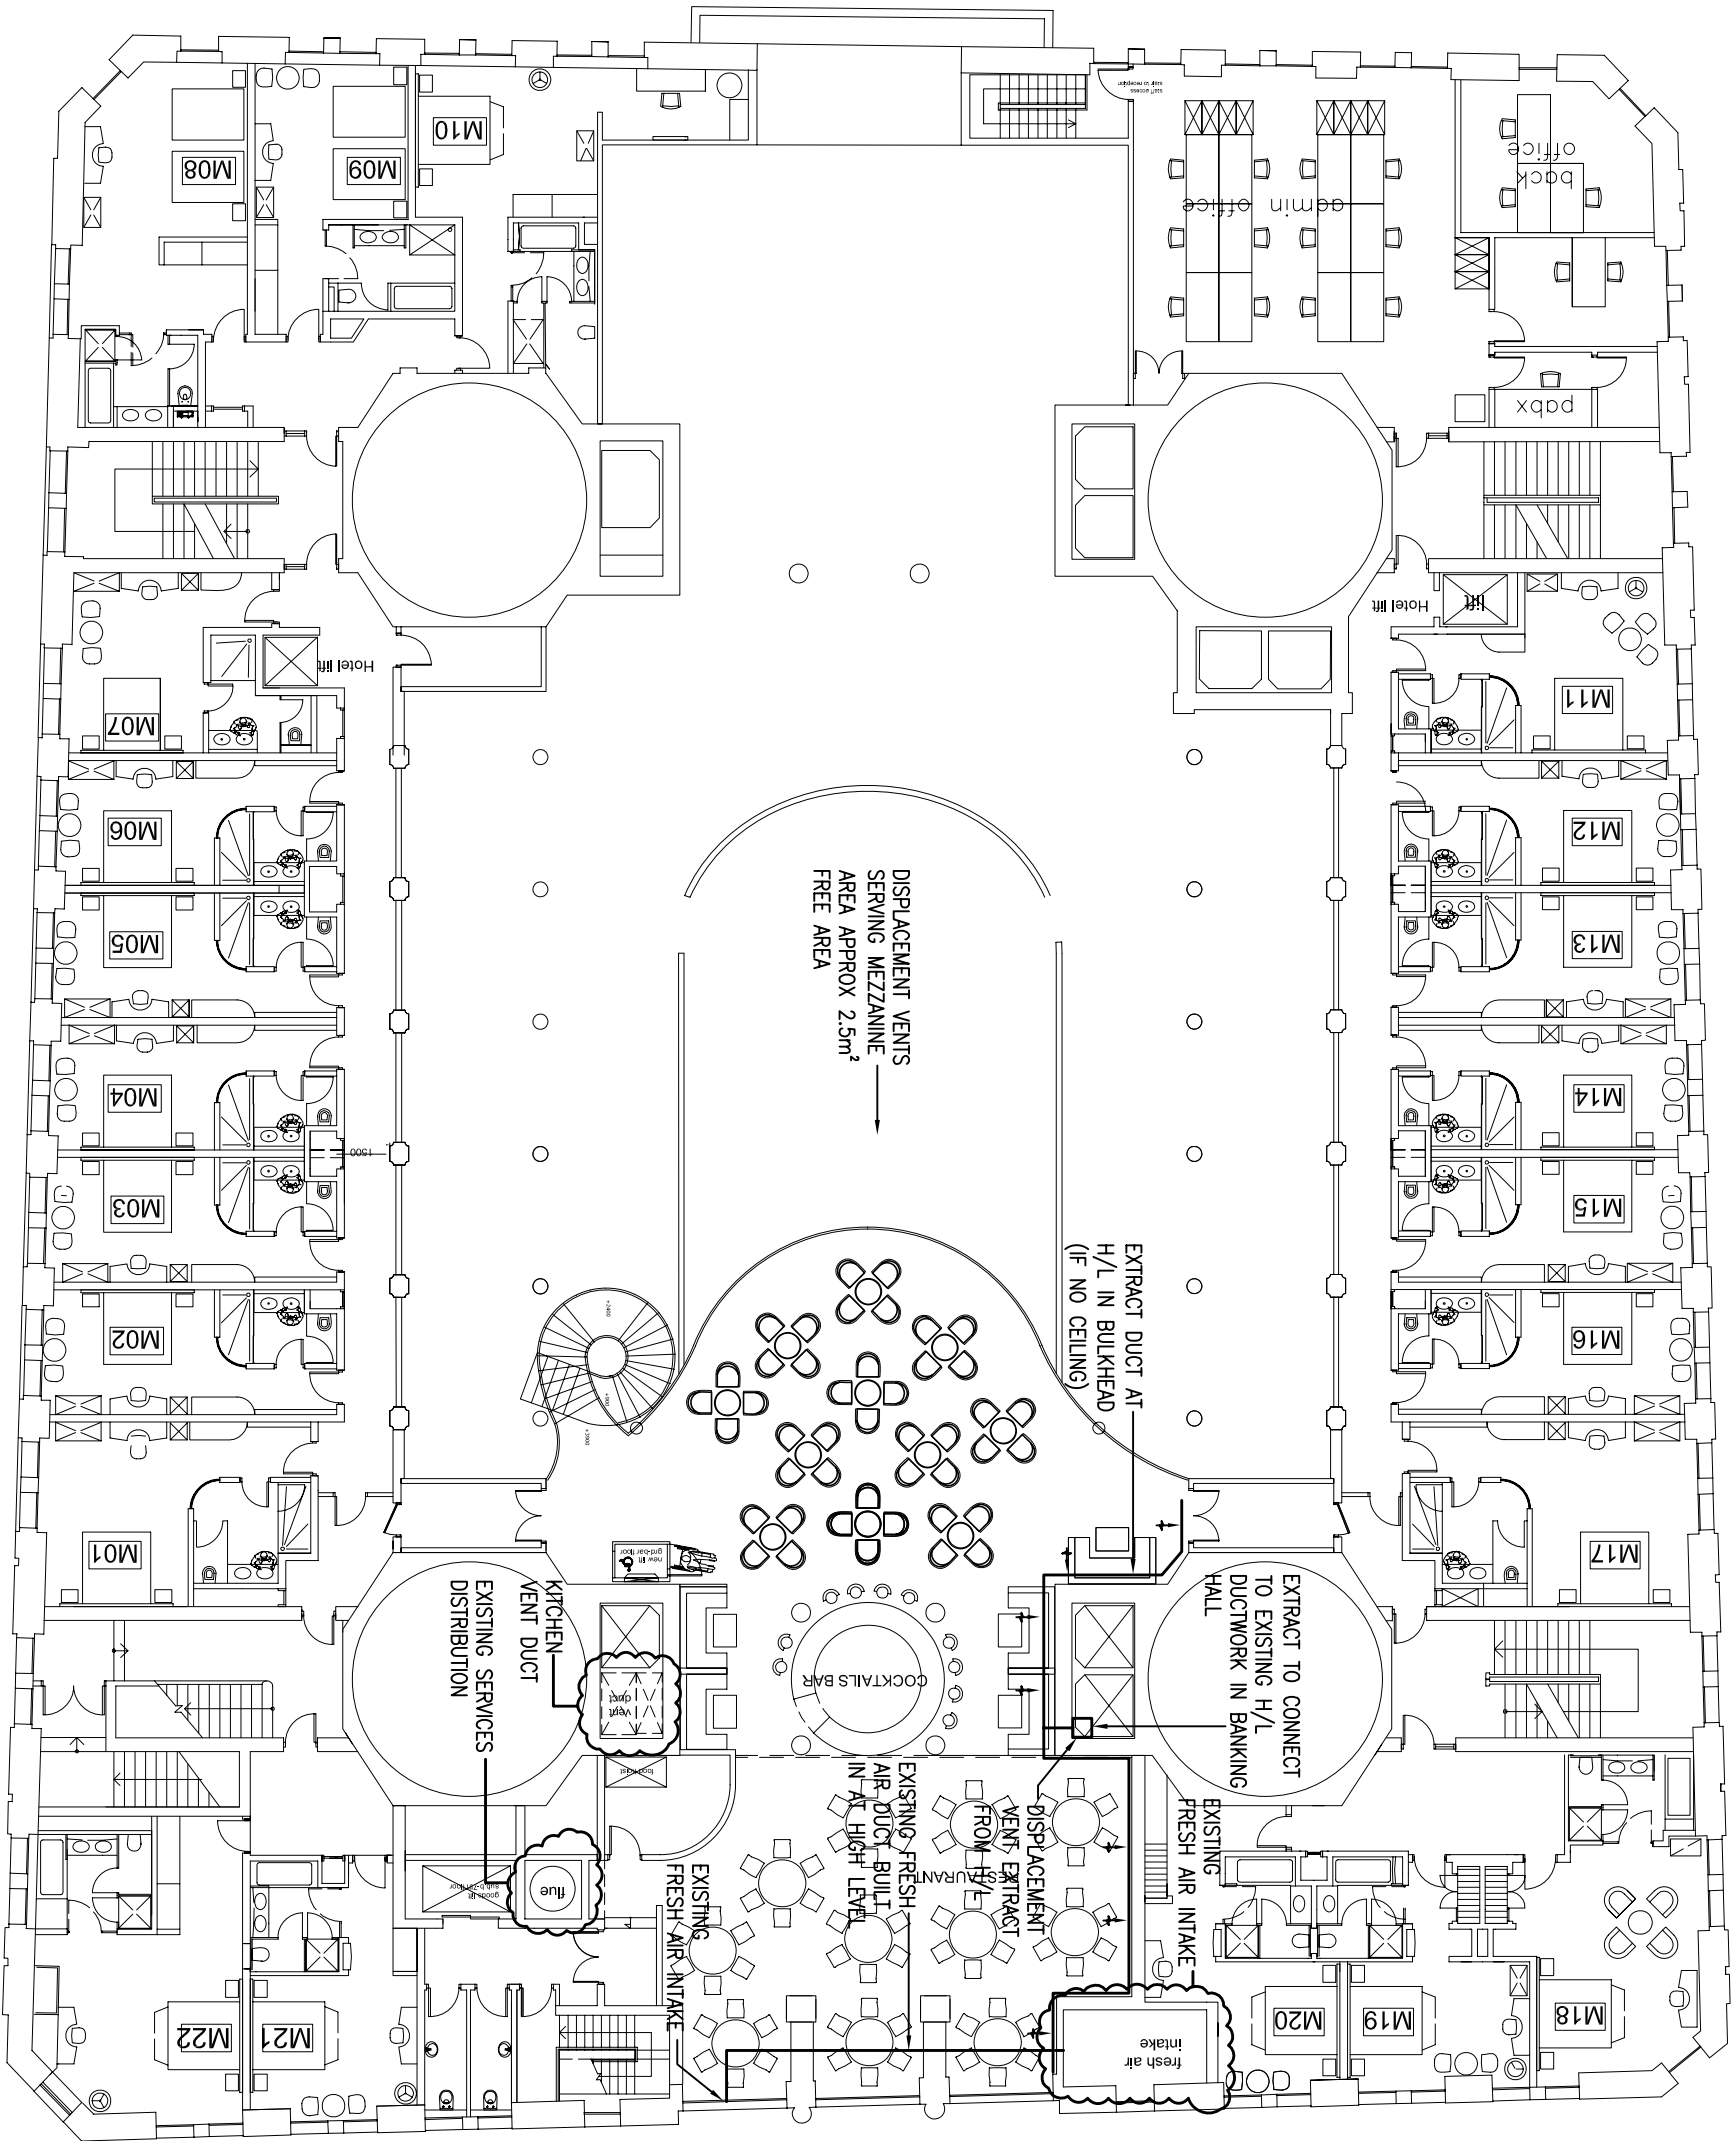

EXCHANGE STREET WEST

EXCHANGE PASSAGE WEST

NOTES.

LEGEND.

P2	15.01.10	REVISED IN LINE WITH ARCHITECTS COMMENTS
P1		PRELIMINARY ISSUE. FOR COMMENT
Rev	Date	Description
Chkd		

HFM Consulting Engineers

1st Floor,  
Courtlets House,  
38 King Street West,  
Manchester  
M3 2WZ

Tel: 0161 833 1410  
Fax: 0161 833 1412



Also At:  
Second Floor, Century Buildings, 31, North John Street, Liverpool, L2 6RG  
Tel: 0151 255 2700 Fax: 0151 255 2701  
Project  
MARTINS BANK BUILDING  
LIVERPOOL

Title  
INDICATIVE PROPOSED  
VENTILATION STRATEGY  
PROPOSED MEZZANINE LEVEL

Engineer RG Checked JH

Job No L1245 Date DEC 2009

Drawing No. Rev. P2

L /1245 / M /203


Scale 1:200 @A3



NOTES.

RUMFORD STREET

DRAINAGE TO DROP FROM C.V.  
TO BELOW WITHIN EXISTING  
COLUMN VOIDS

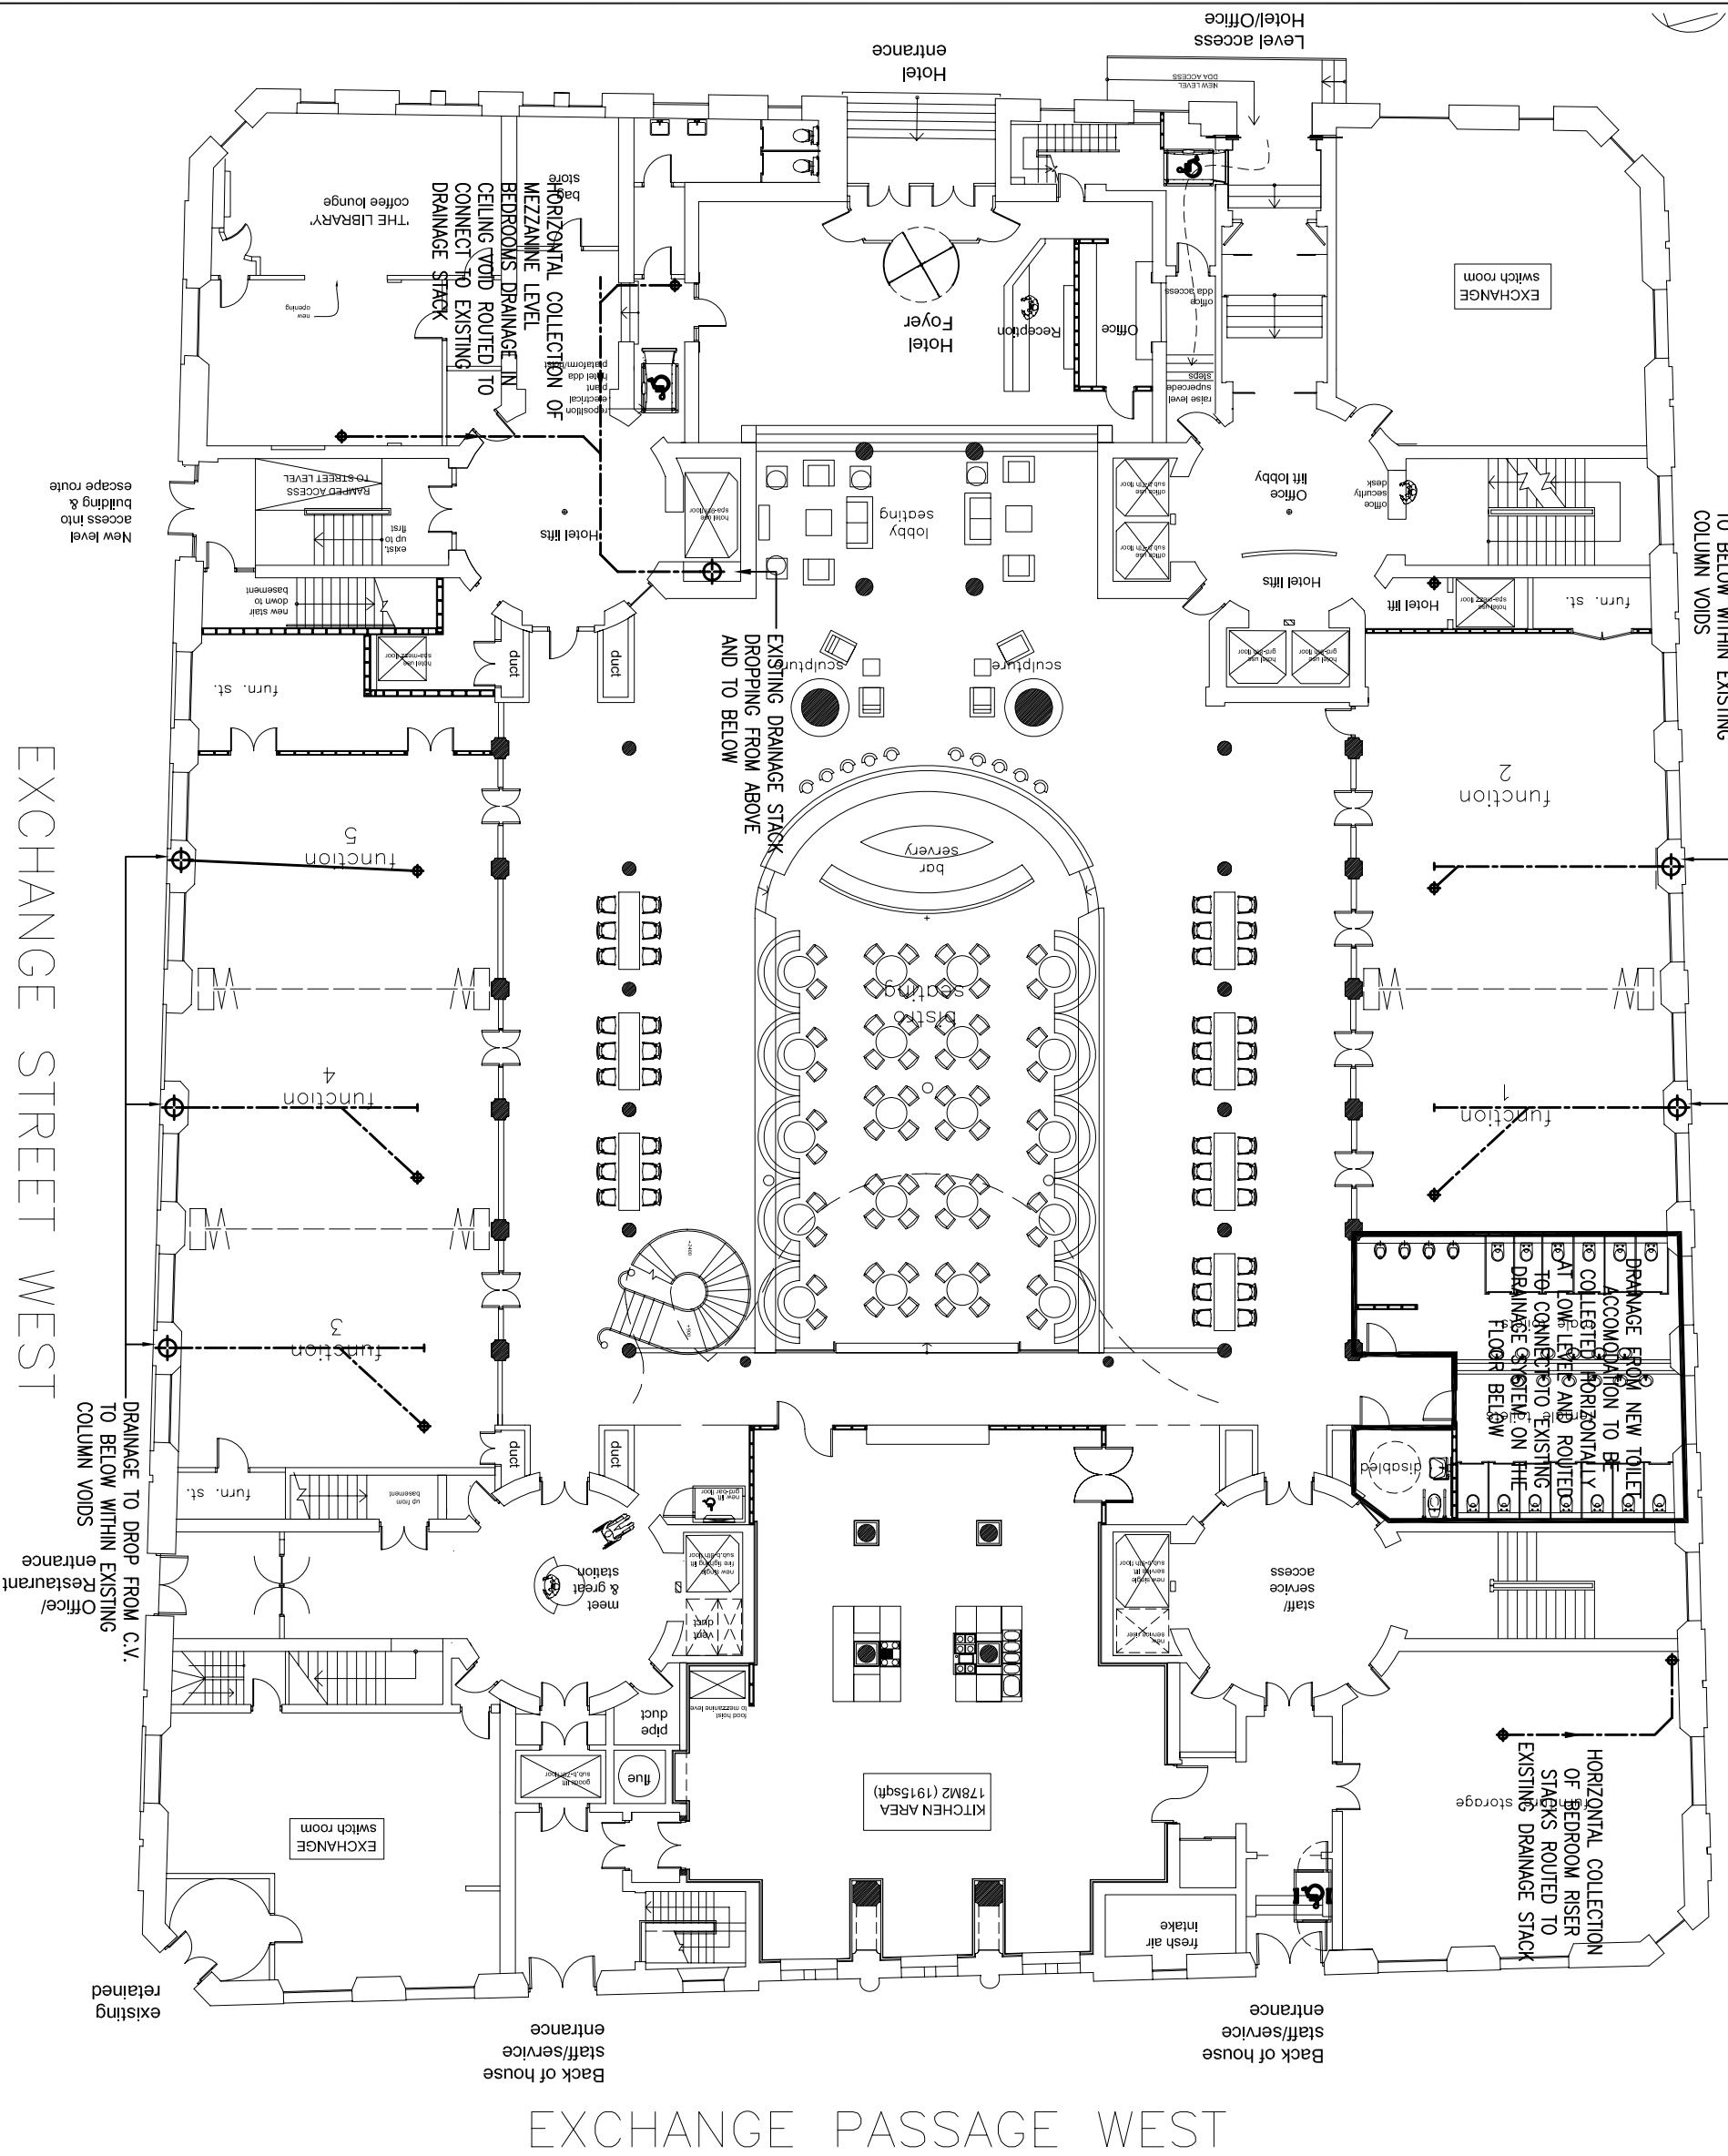

LEGEND.

P2	15.01.10	REVISED IN LINE WITH ARCHITECTS COMMENTS	
P1		PRELIMINARY ISSUE. FOR COMMENT	
Rev	Date	Description	Chkd

HFM Consulting Engineers

1st Floor,  
Courtiels House,  
38 King Street West,  
Manchester  
M3 2WZ  
Tel: 0161 833 1410  
Fax: 0161 833 1412




Also At:  
Second Floor, Century Buildings, 31, North John Street, Liverpool, L2 8RG  
Tel: 0151 255 2700 Fax: 0151 255 2701

Project  
MARTINS BANK BUILDING  
LIVERPOOL


Title  
INDICATIVE PROPOSED  
INTERNAL DRAINAGE STRATEGY  
PROPOSED GROUND FLOOR

Engineer	RG	Checked	JH
Job No	L1245	Date	DEC 2009
Drawing No.	L / 1245 / M / SK502	Rev.	P2
		Scale	1:200 @A3

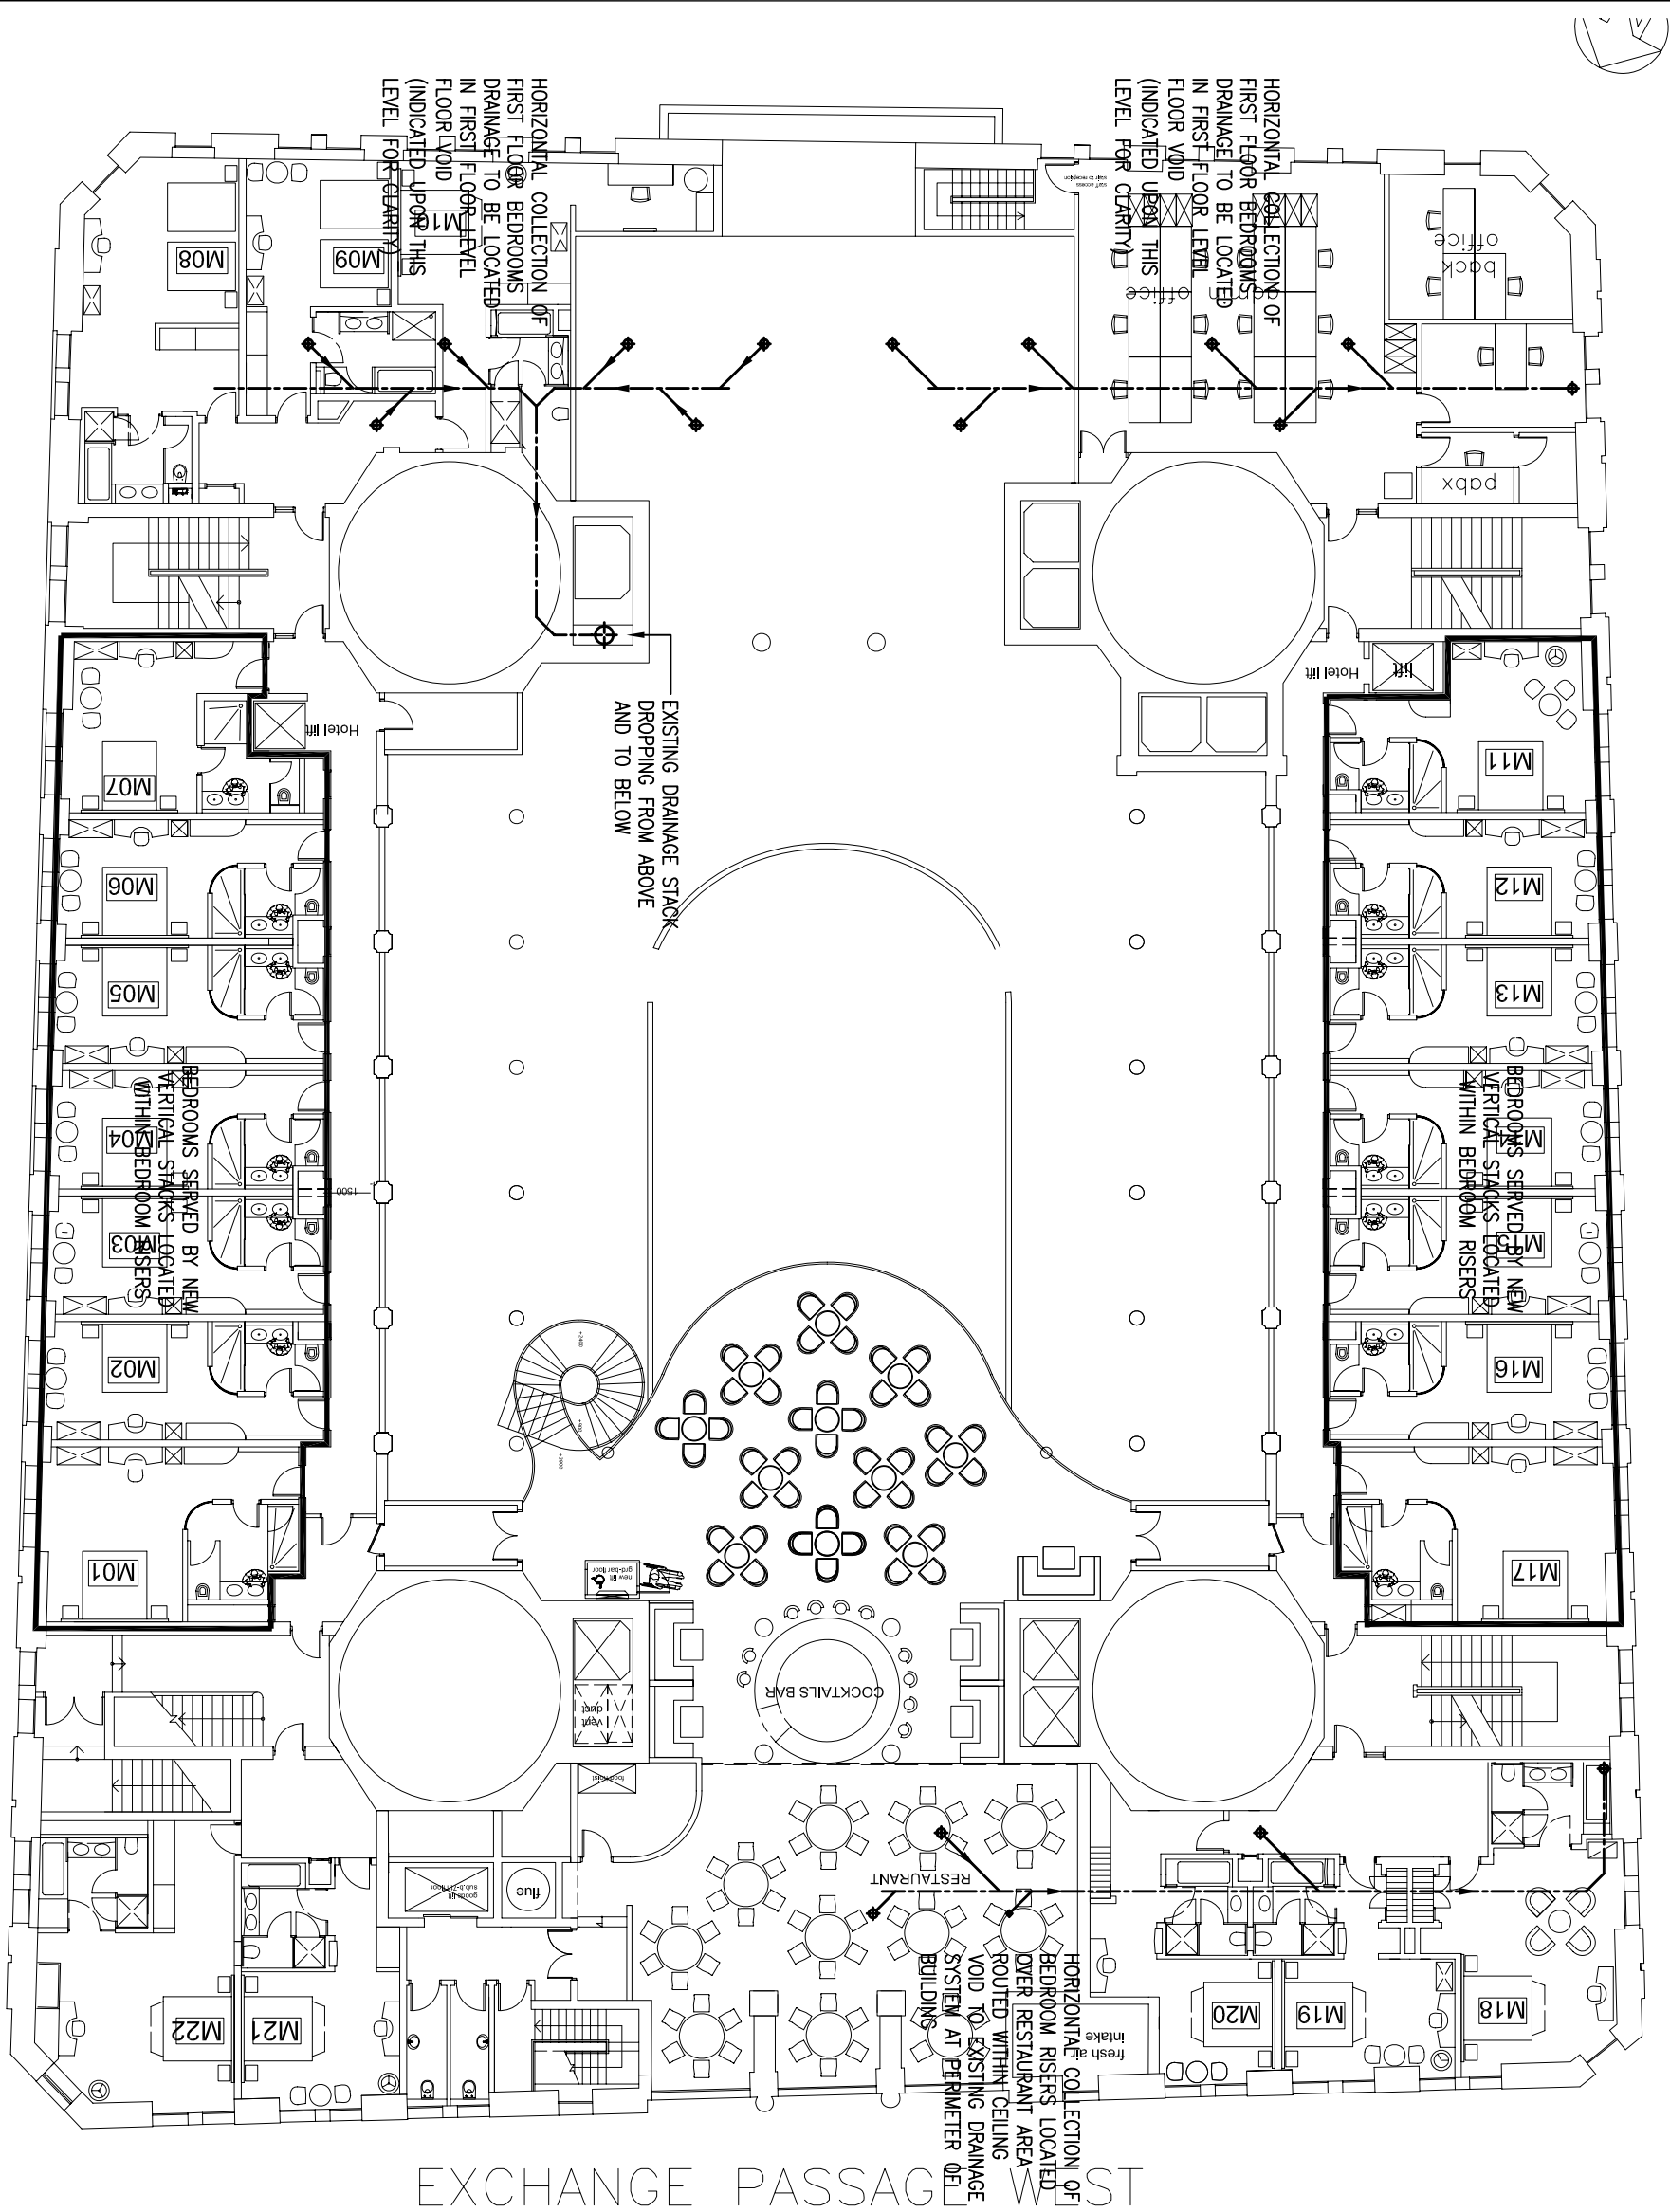






 

M:\L1247 Martins Bank Building\6. Drawings\Mech\L1247-M-SK502-507-DRAINAGE.dwg

RUMFORD STREET

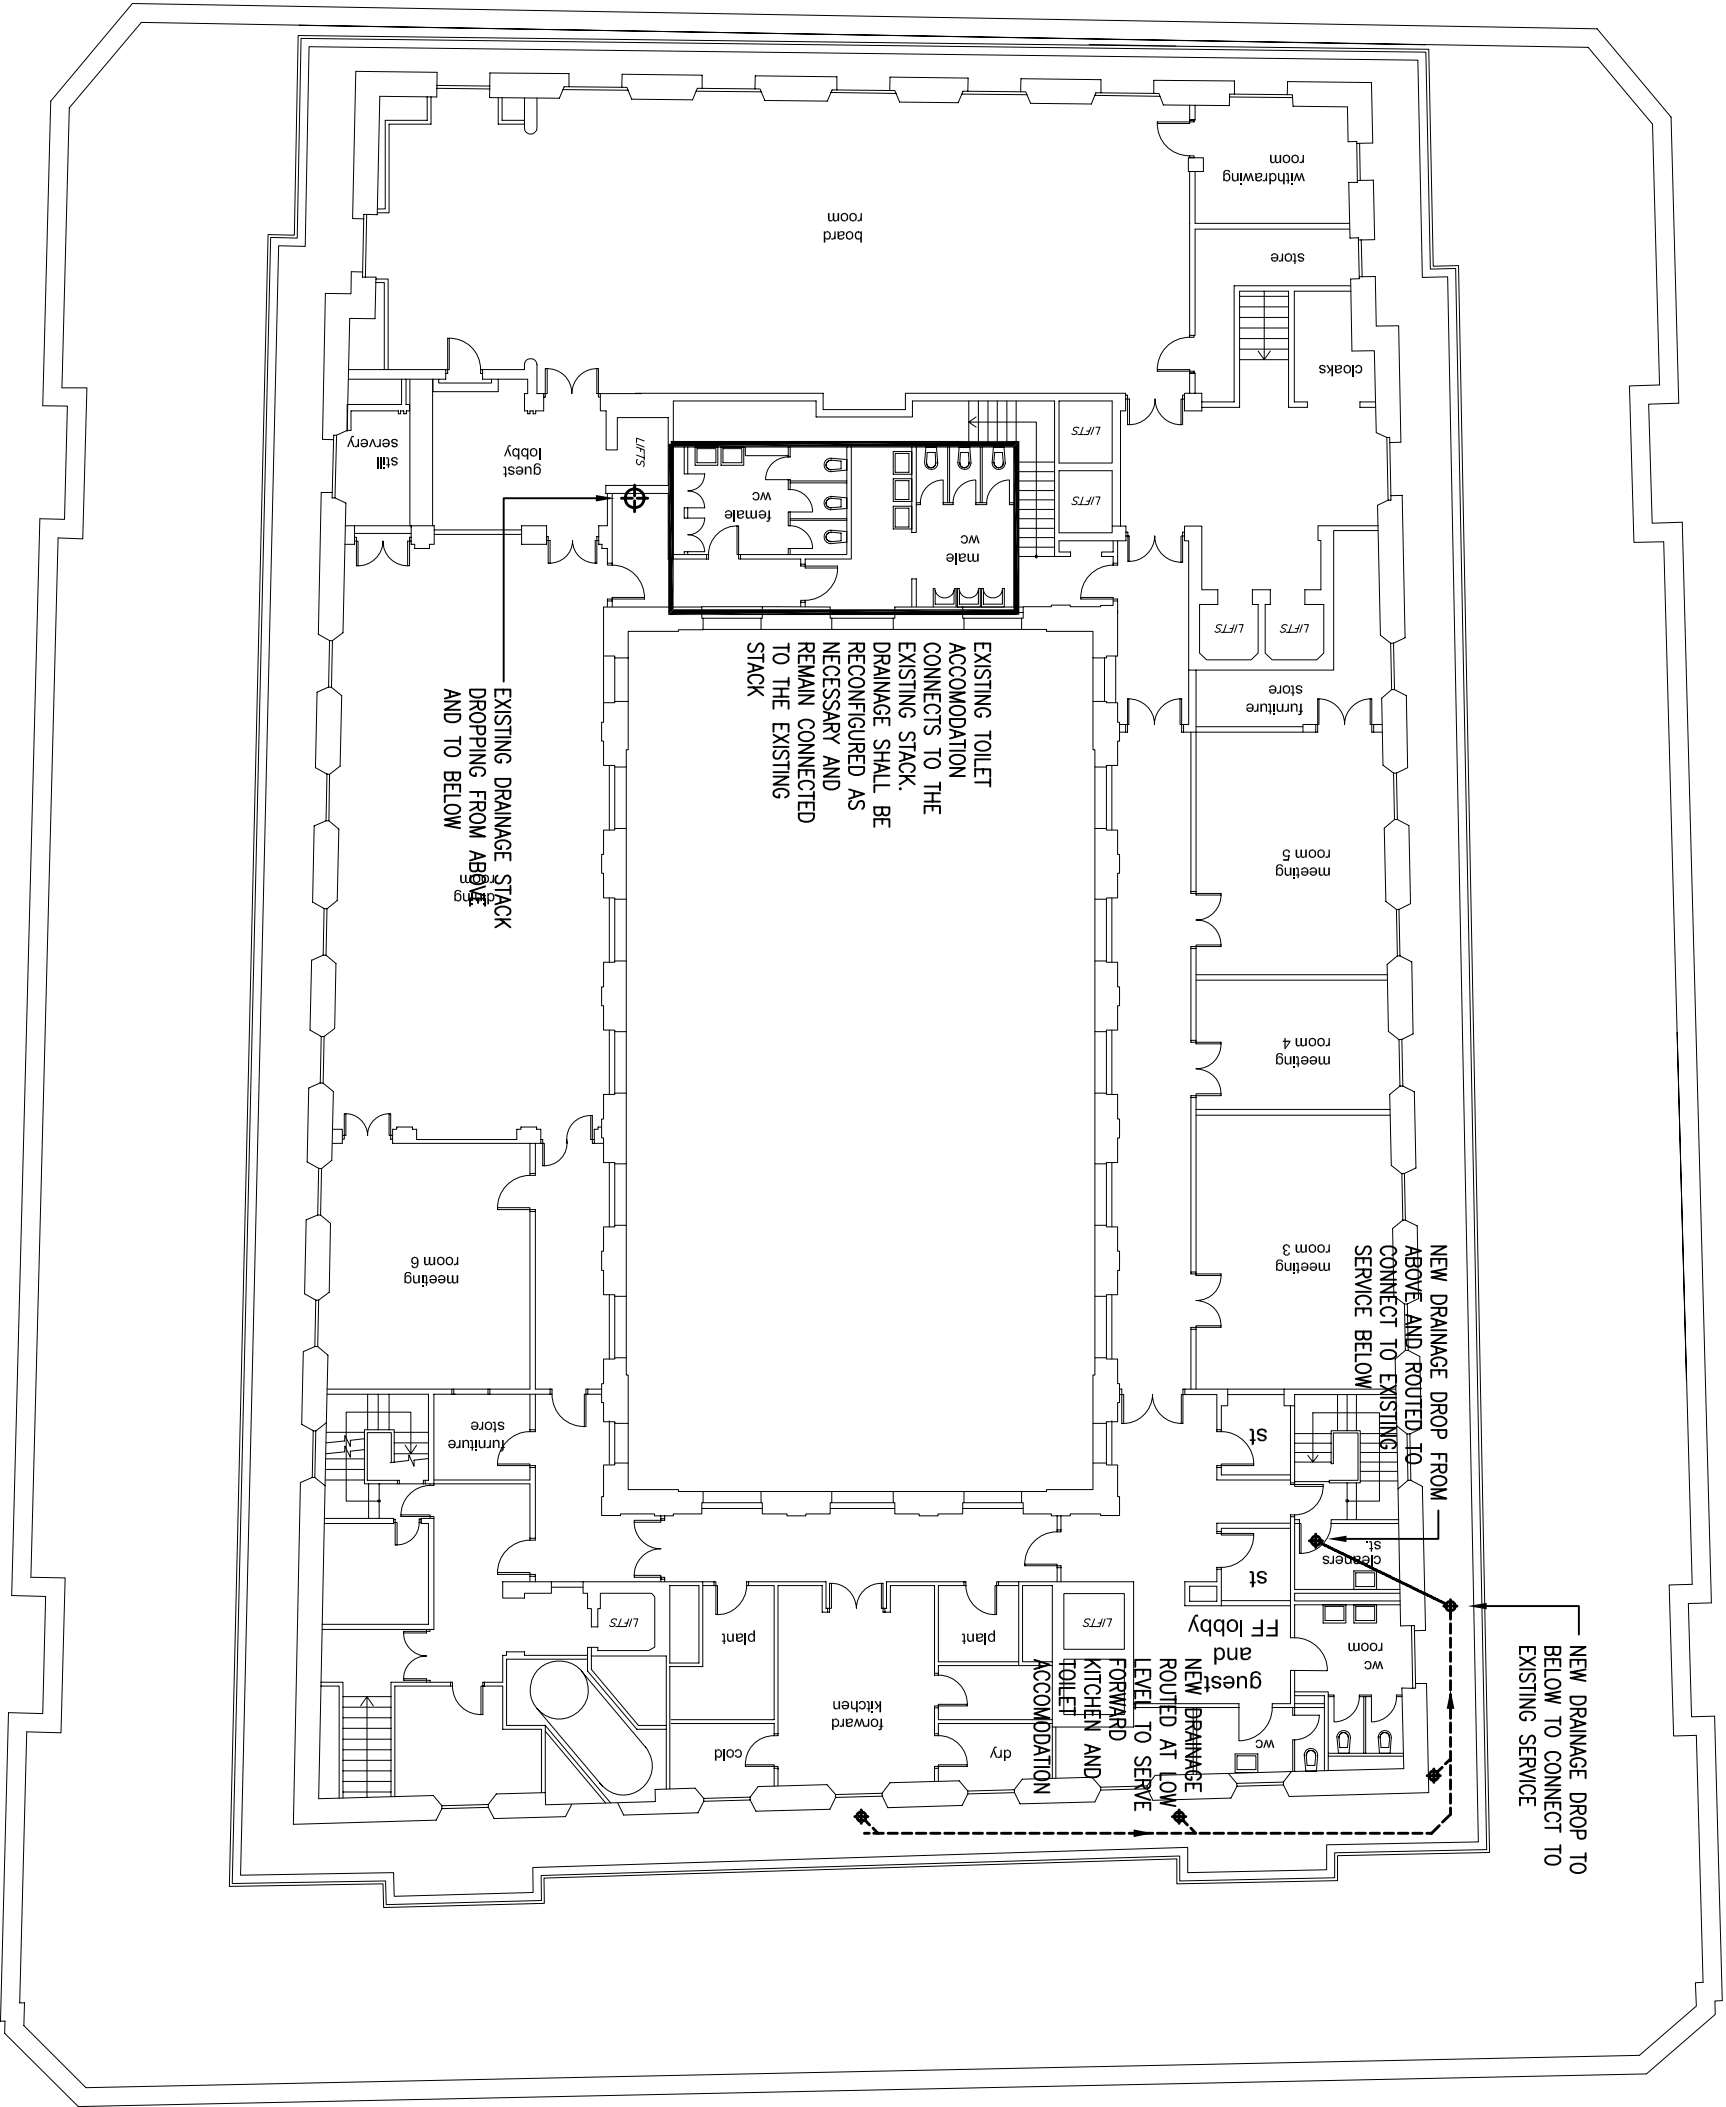

EXCHANGE STREET WEST

EXCHANGE PASSAGE WEST

NOTES.

LEGEND.

P2	15.01.10	REVISED IN LINE WITH ARCHITECTS COMMENTS	
P1		PRELIMINARY ISSUE. FOR COMMENT	
Rev	Date	Description	Chkd

HFM Consulting Engineers

1st Floor,  
Courtiels House,  
38 King Street West,  
Manchester  
M3 2WZ

Tel: 0161 833 1410  
Fax: 0161 833 1412



Also At:  
Second Floor, Century Buildings, 31, North John Street, Liverpool, L2 6RG  
Tel: 0151 255 2700 Fax: 0151 255 2701

Project  
MARTINS BANK BUILDING  
LIVERPOOL

Title  
INDICATIVE PROPOSED  
INTERNAL DRAINAGE STRATEGY  
PROPOSED 8TH FLOOR

Engineer	RG	Checked	JH
----------	----	---------	----

Job No	L1245	Date	DEC 2009
--------	-------	------	----------

Drawing No.	Rev. P2
-------------	---------

L / 1245 / M / SK506

Scale 1:200 @A3

NOTES.

LEGEND.

P2	15.01.10	REVISED IN LINE WITH ARCHITECTS COMMENTS
P1		PRELIMINARY ISSUE. FOR COMMENT
Rev	Date	Description
Chkd		


HFM Consulting Engineers

1st Floor,  
Courtlets House,  
38 King Street West,  
Manchester  
M3 2WZ  
Tel: 0161 833 1410  
Fax: 0161 833 1412




Also At:  
Second Floor, Century Buildings, 31, North John Street, Liverpool, L2 6RG  
Tel: 0151 255 2700 Fax: 0151 255 2701  
Project  
MARTINS BANK BUILDING  
LIVERPOOL

Title INDICATIVE PROPOSED INTERNAL DRAINAGE STRATEGY PROPOSED 9TH FLOOR			
Engineer	RG	Checked	JH
Job No	L1245	Date	DEC 2009
Drawing No.	L / 1245 / M / SK507		Rev. P2
		Scale	1:200 @A3

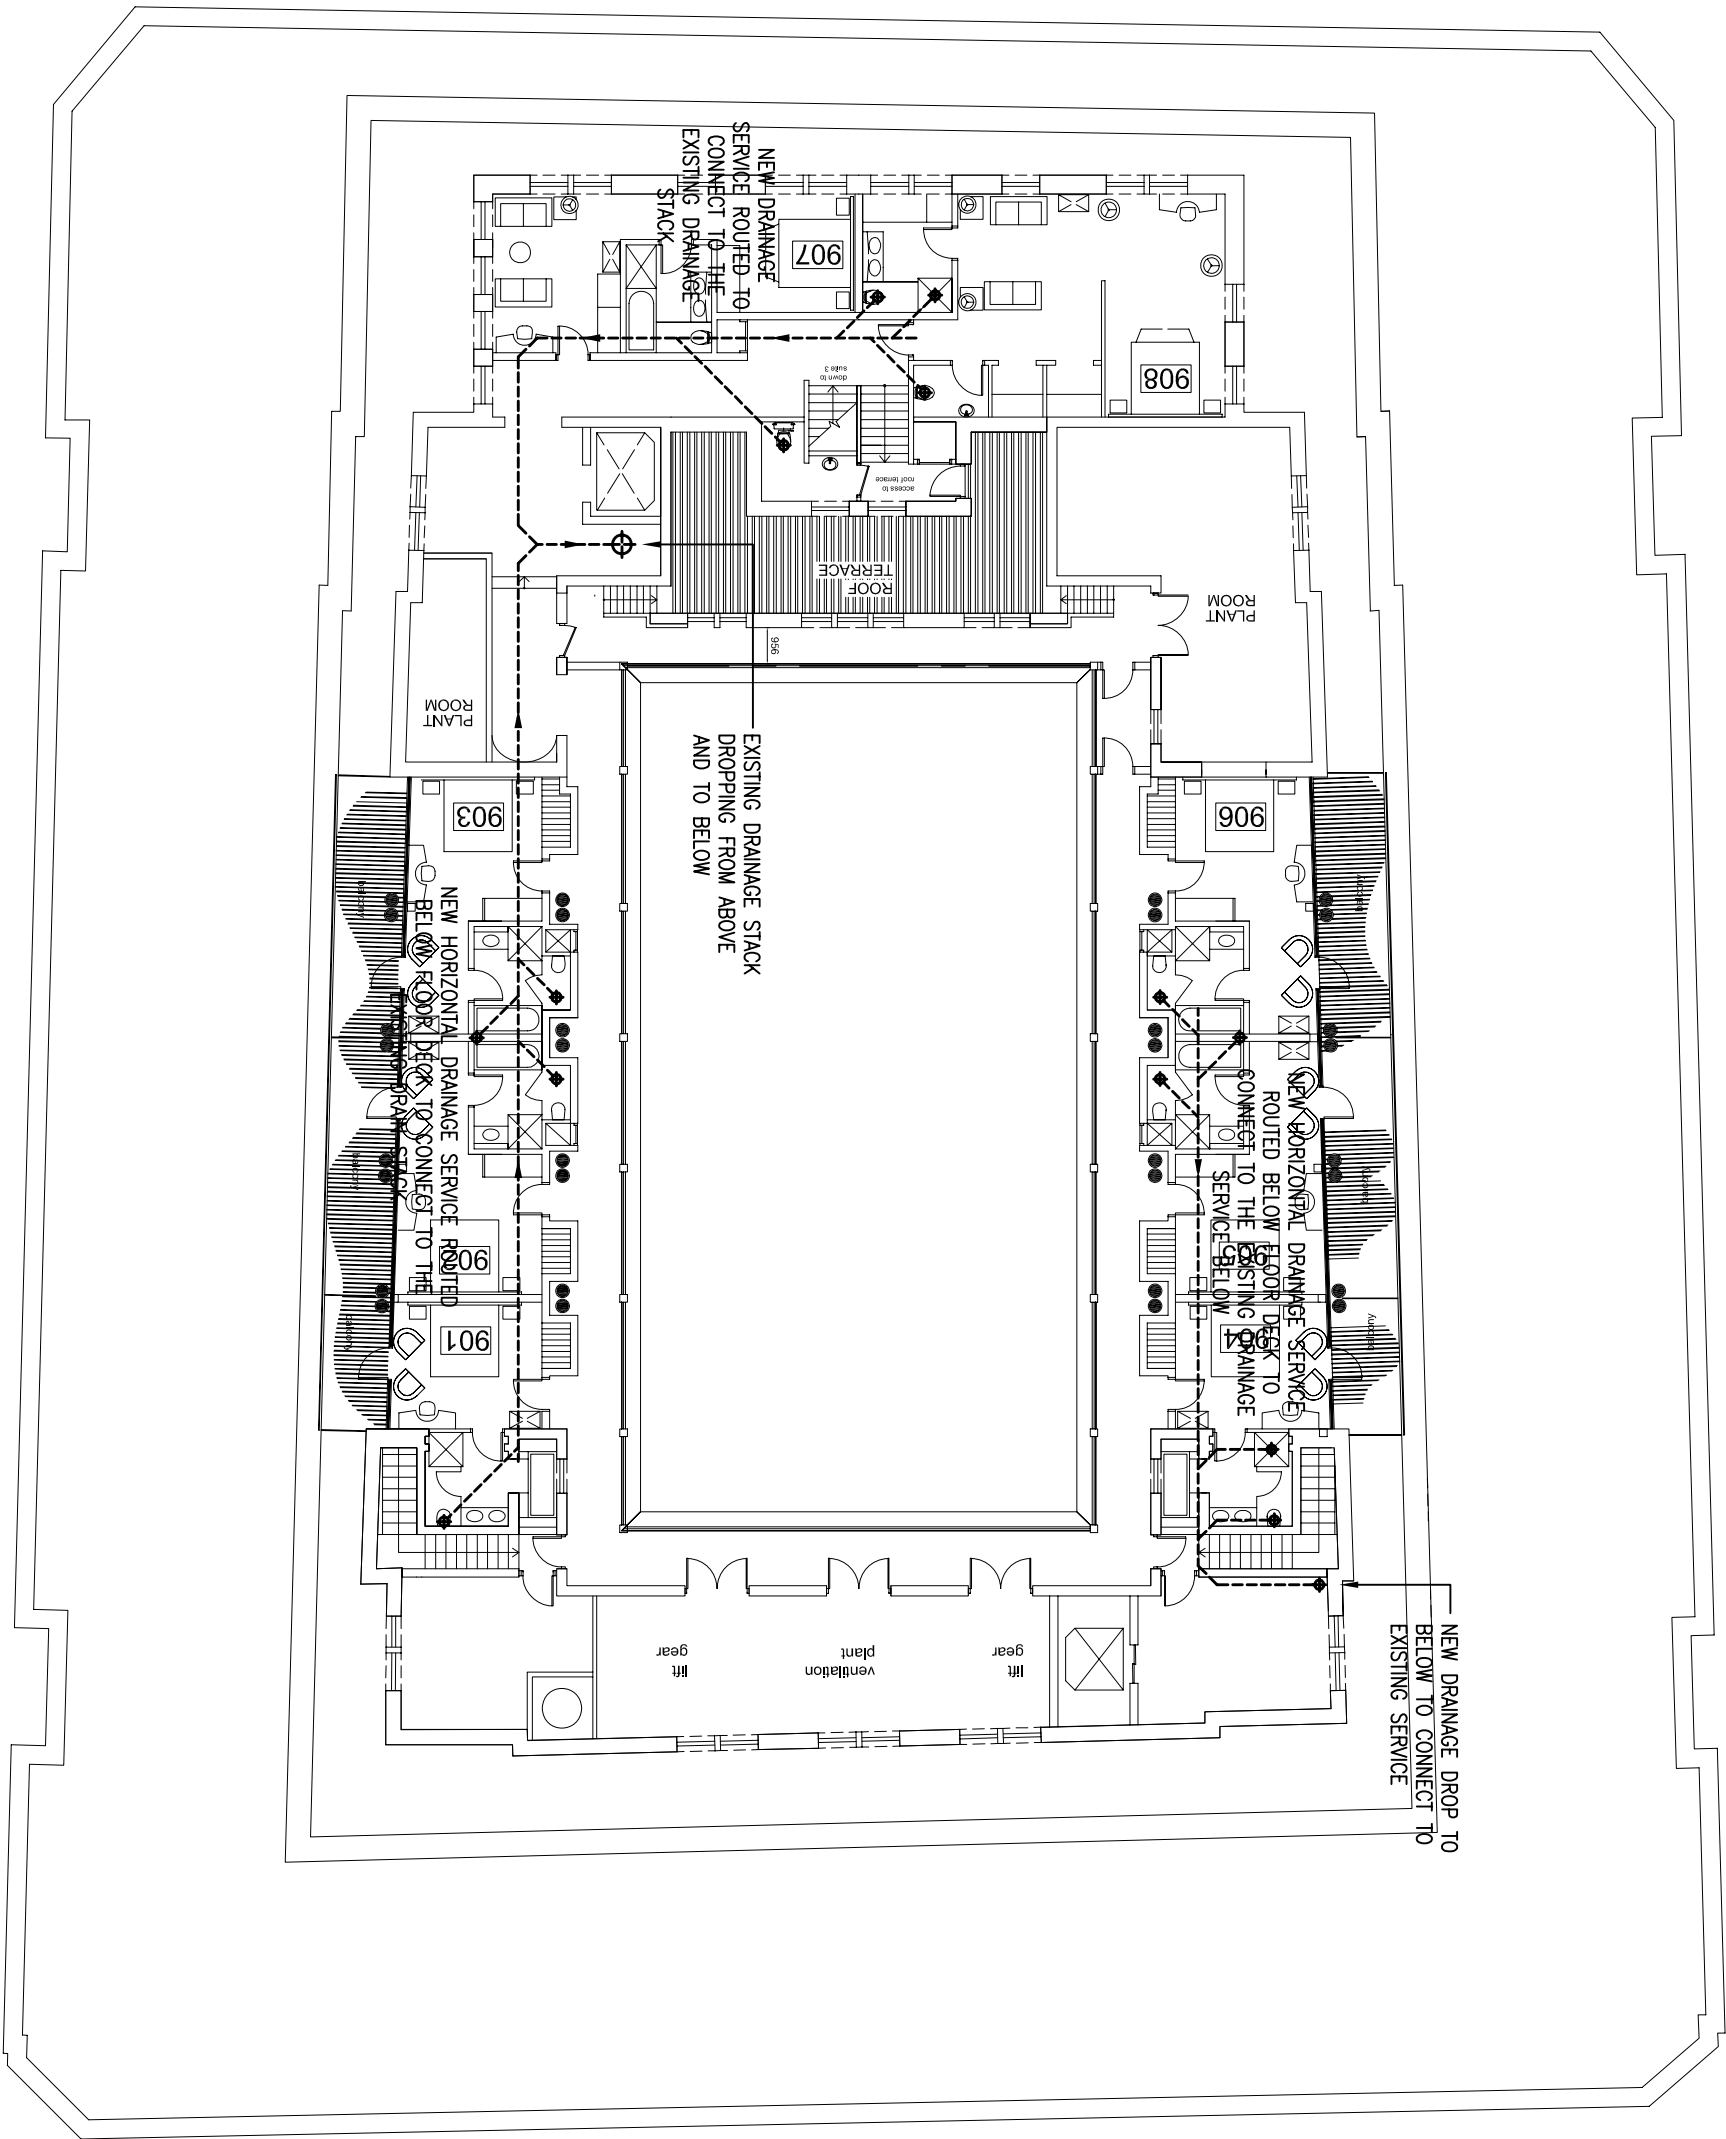

NOTES.

RUMFORD STREET

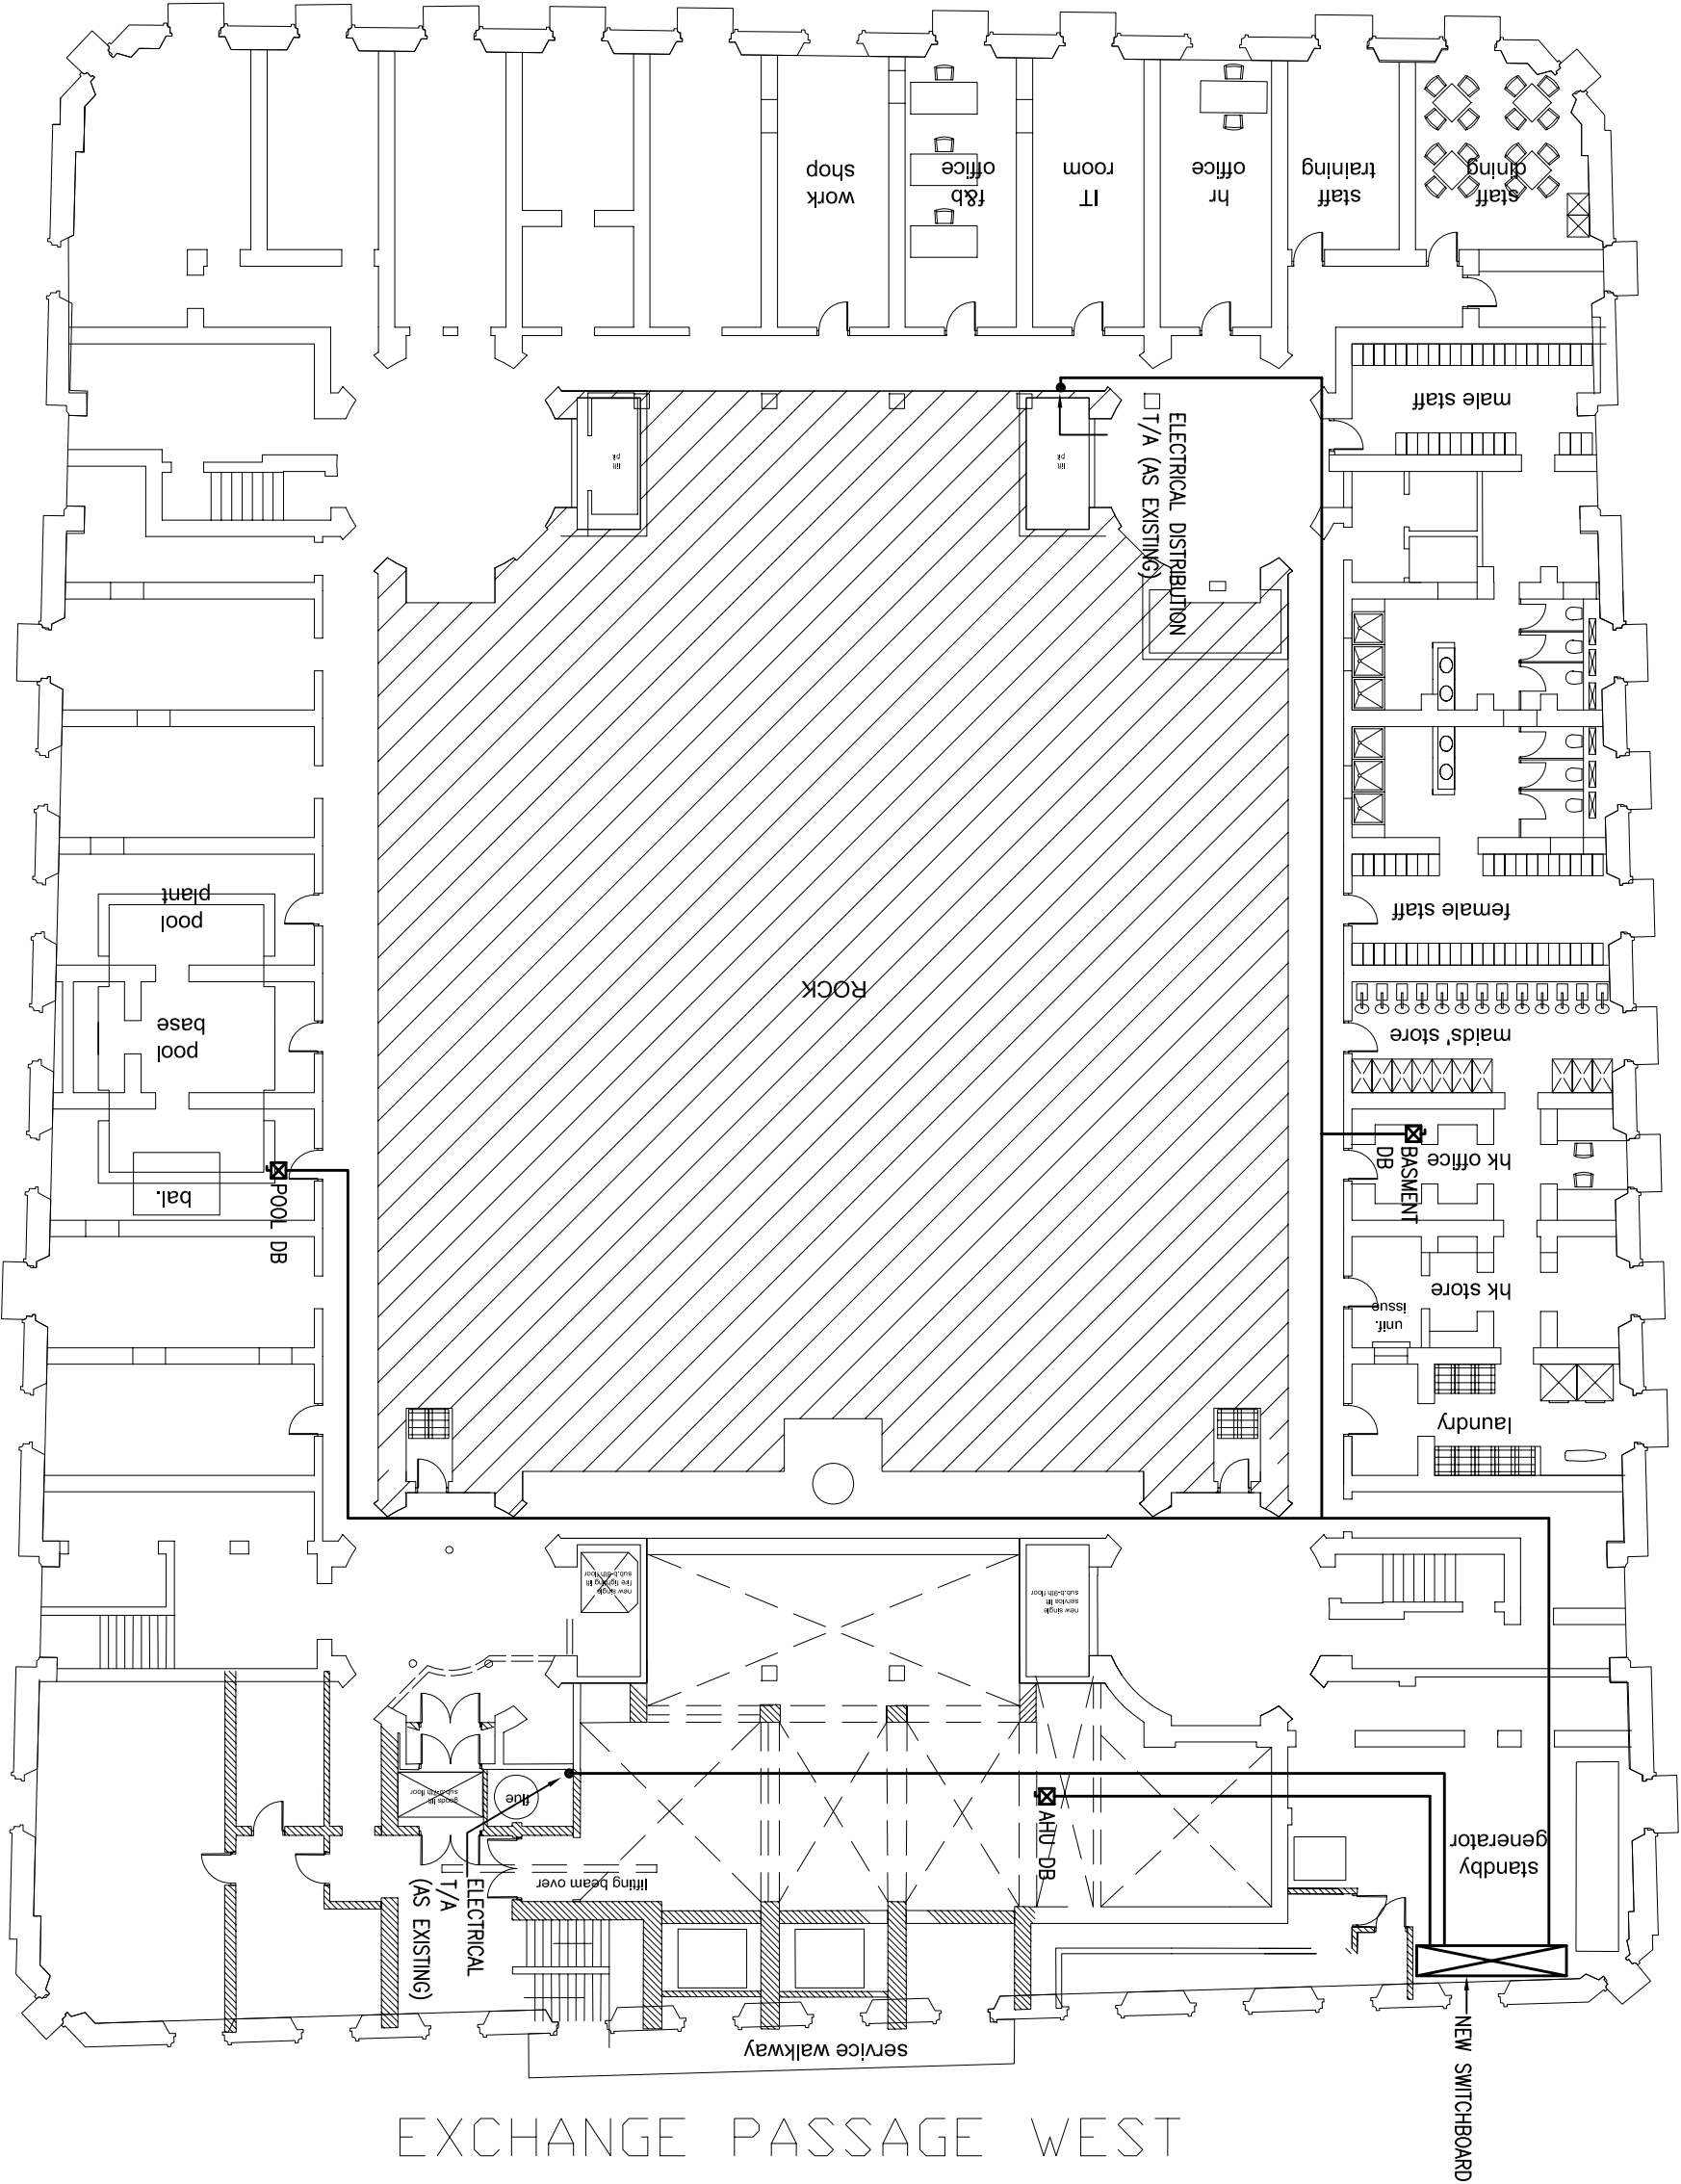

EXCHANGE PASSAGE WEST

LEGEND.

p1	PRELIMINARY ISSUE. FOR COMMENT		
Rev	Date	Description	Chkd

HFM Consulting Engineers

1st Floor,  
Courtiels House,  
38 King Street West,  
Manchester  
M3 2WZ  
Tel: 0161 833 1410  
Fax: 0161 833 1412




Also At:  
Second Floor, Century Buildings, 31, North John Street, Liverpool, L2 6RG  
Tel: 0151 255 2700 Fax: 0151 255 2701  
Project  
MARTINS BANK BUILDING  
LIVERPOOL

Title  
BASEMENT LEVEL INDICATIVE ELECTRICAL LAYOUT

Engineer PH Checked

Job No L/1247 Date 04.12.09

Drawing No. L /1247/E /200 Rev. p1 Scale 1:200 @A3

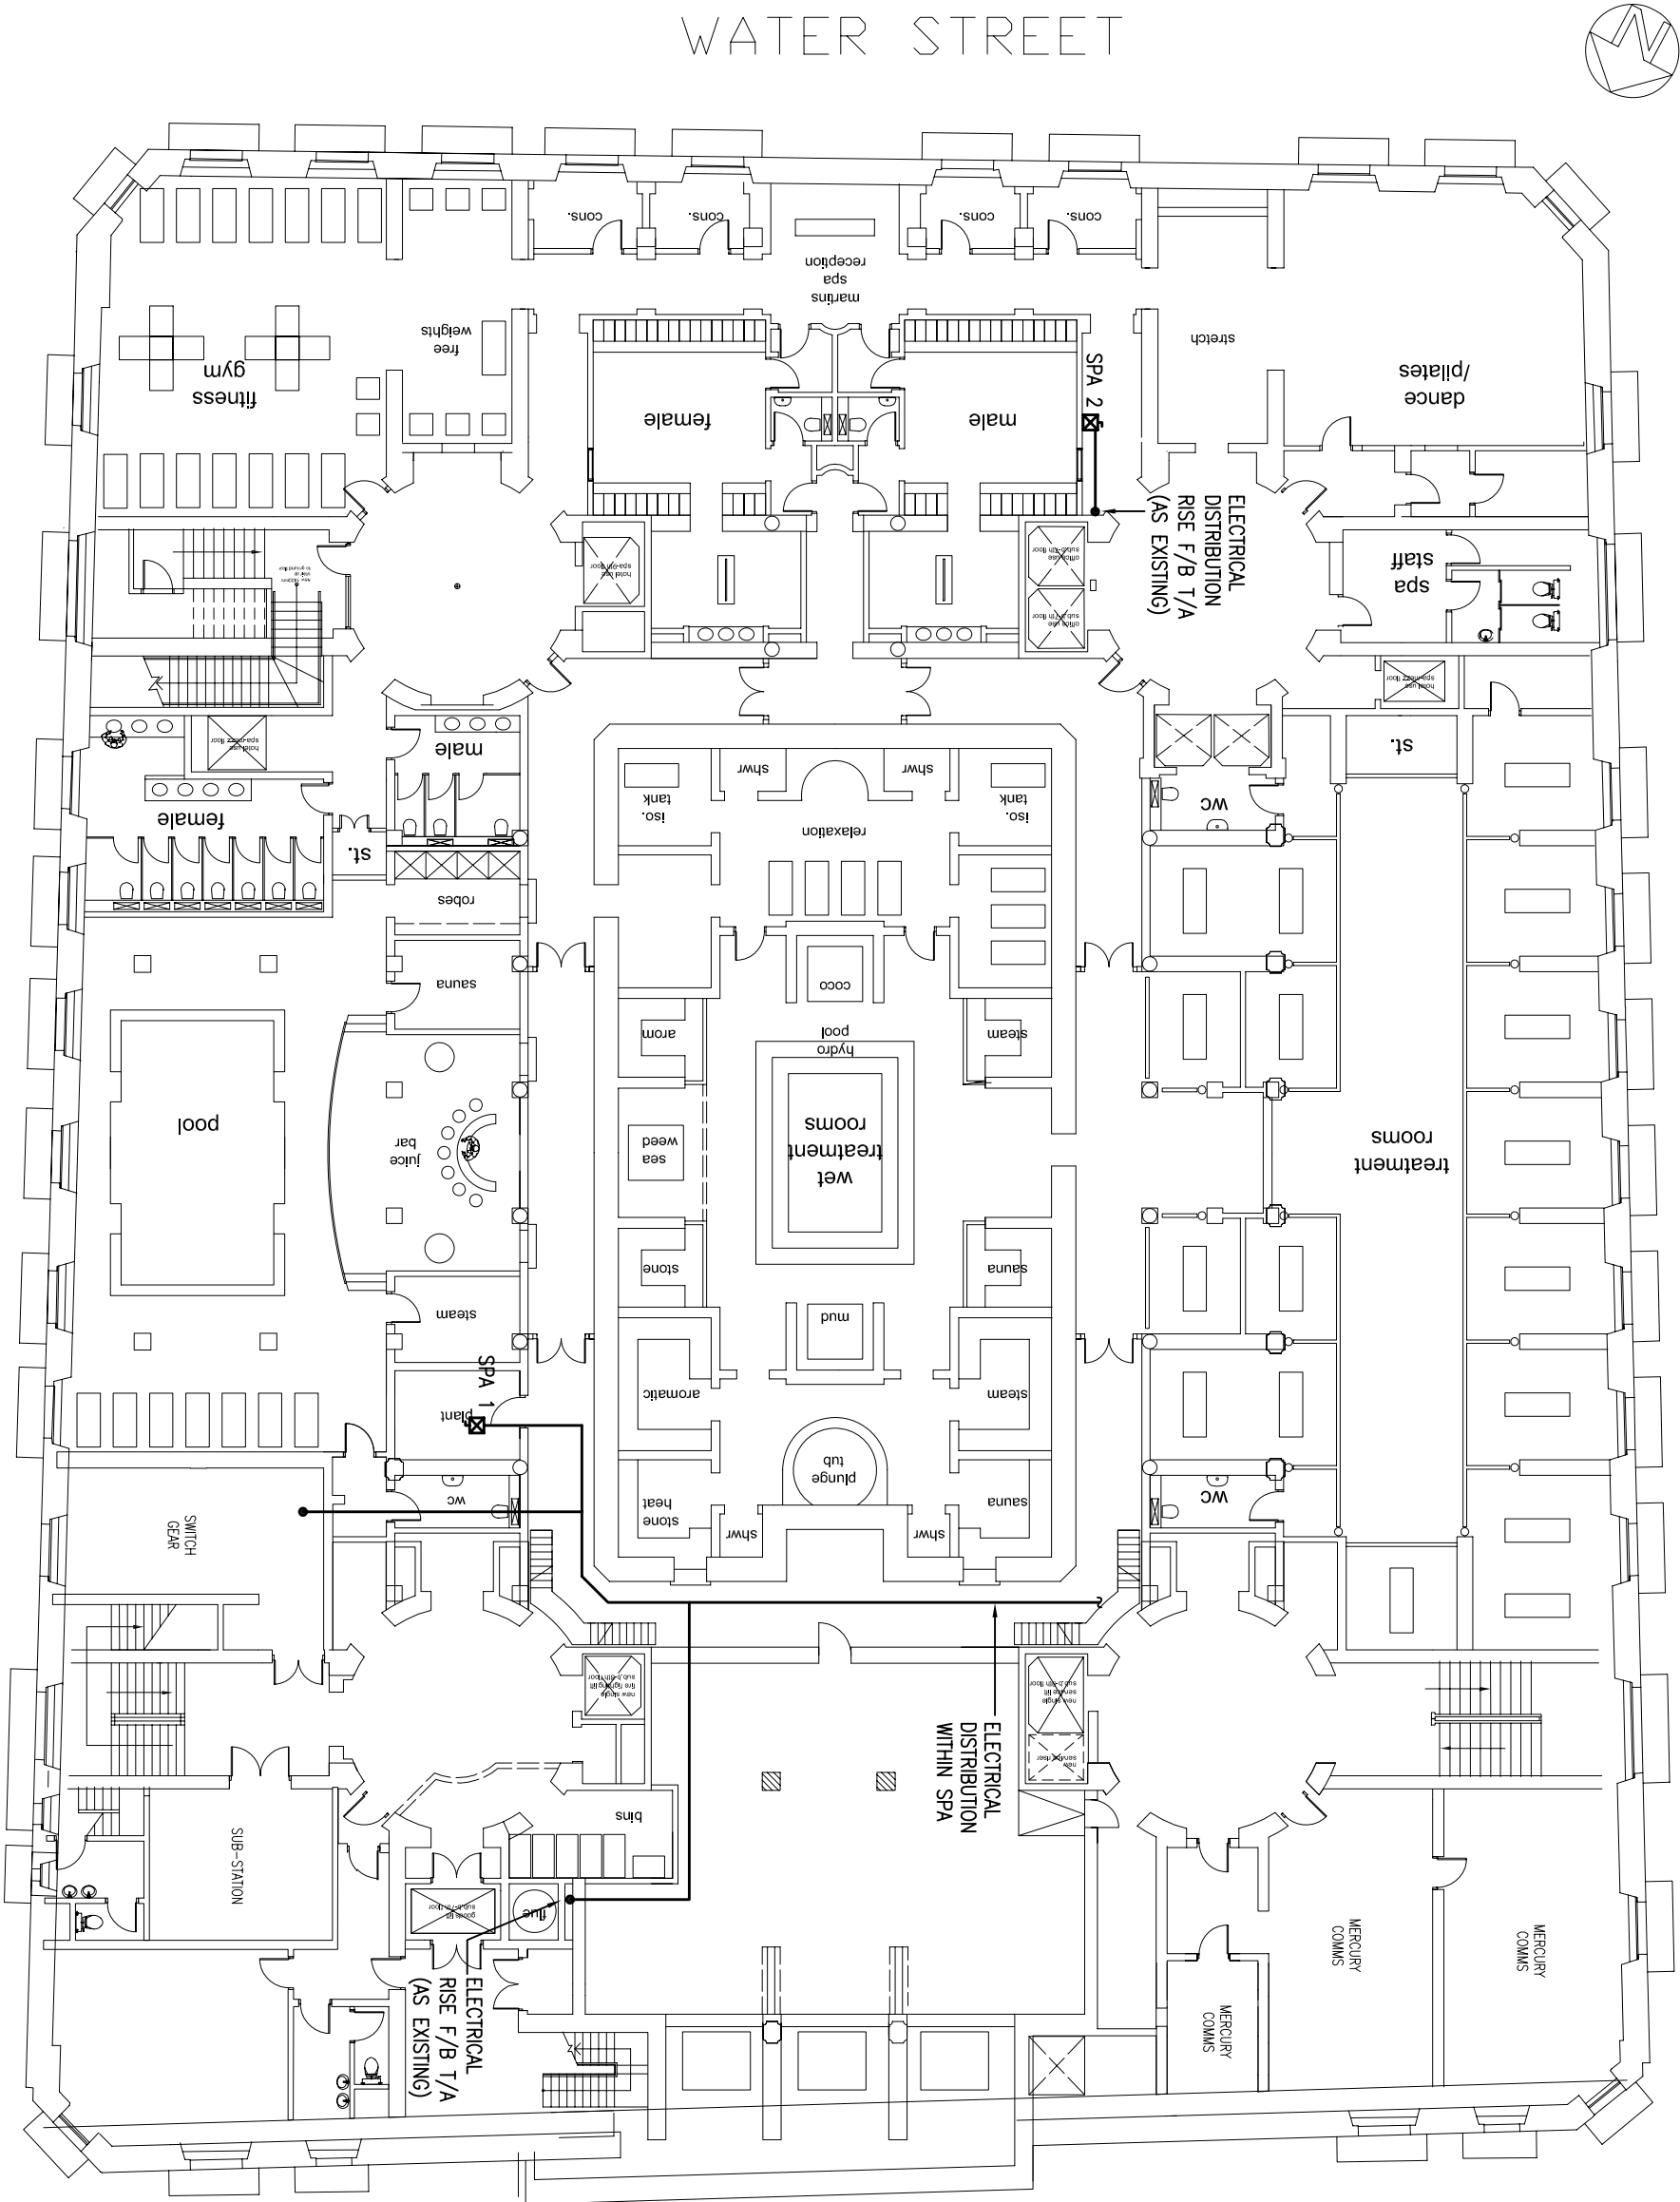

RUMFORD STREET

WATER STREET

EXCHANGE STREET WEST

NOTES.

LEGEND.

P1	PRELIMINARY ISSUE. FOR COMMENT		
Rev	Date	Description	Chkd

HFM Consulting Engineers

1st Floor,  
Courtlis House,  
38 King Street West,  
Manchester  
M3 2WZ

Tel: 0161 833 1410  
Fax: 0161 833 1412




Also At:  
Second Floor, Century Buildings, 31, North John Street, Liverpool, L2 6RG  
Tel: 0151 255 2700 Fax: 0151 255 2701

Project  
MARTINS BANK BUILDING  
LIVERPOOL


Title  
LOWER GROUND FLOOR INDICATIVE ELECTRICAL  
LAYOUT

Engineer	PH	Checked	
Job No	L/1247	Date	04.12.09
Drawing No.		Rev.	P1
L /1247/E /201		Scale	1:200 @A3

## NOTES.

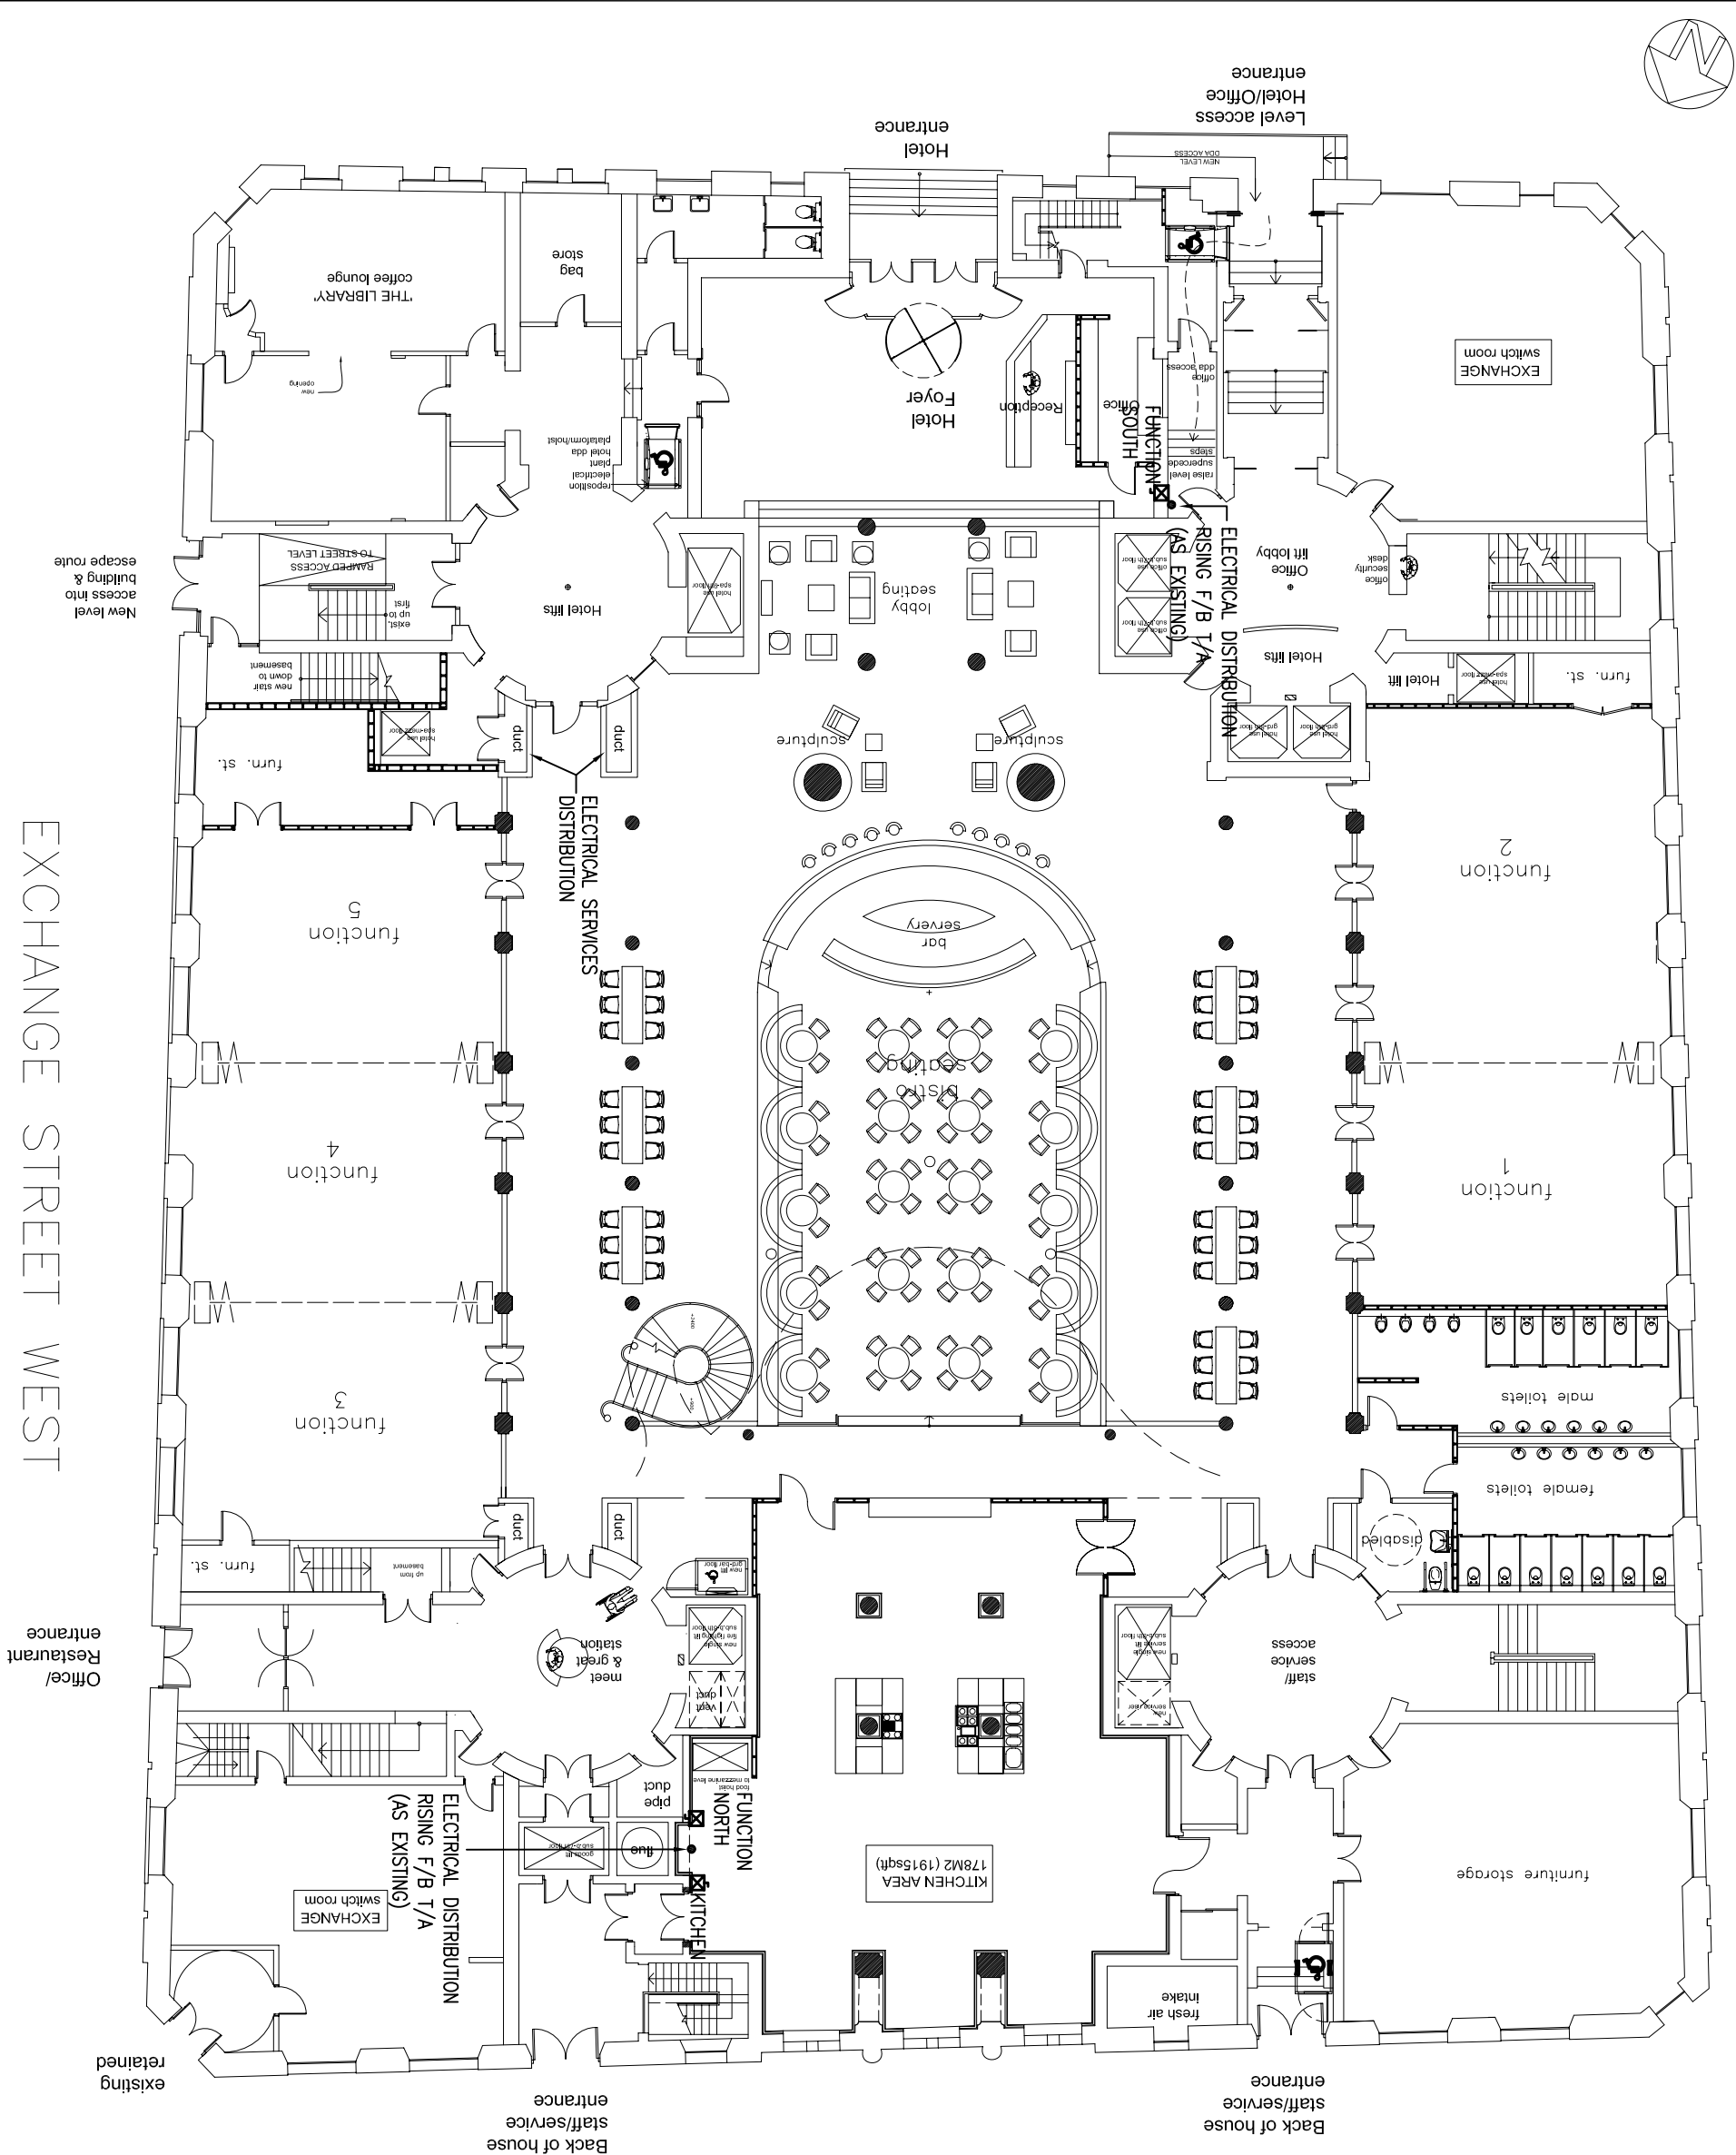[illegible]

RUMFORD STREET

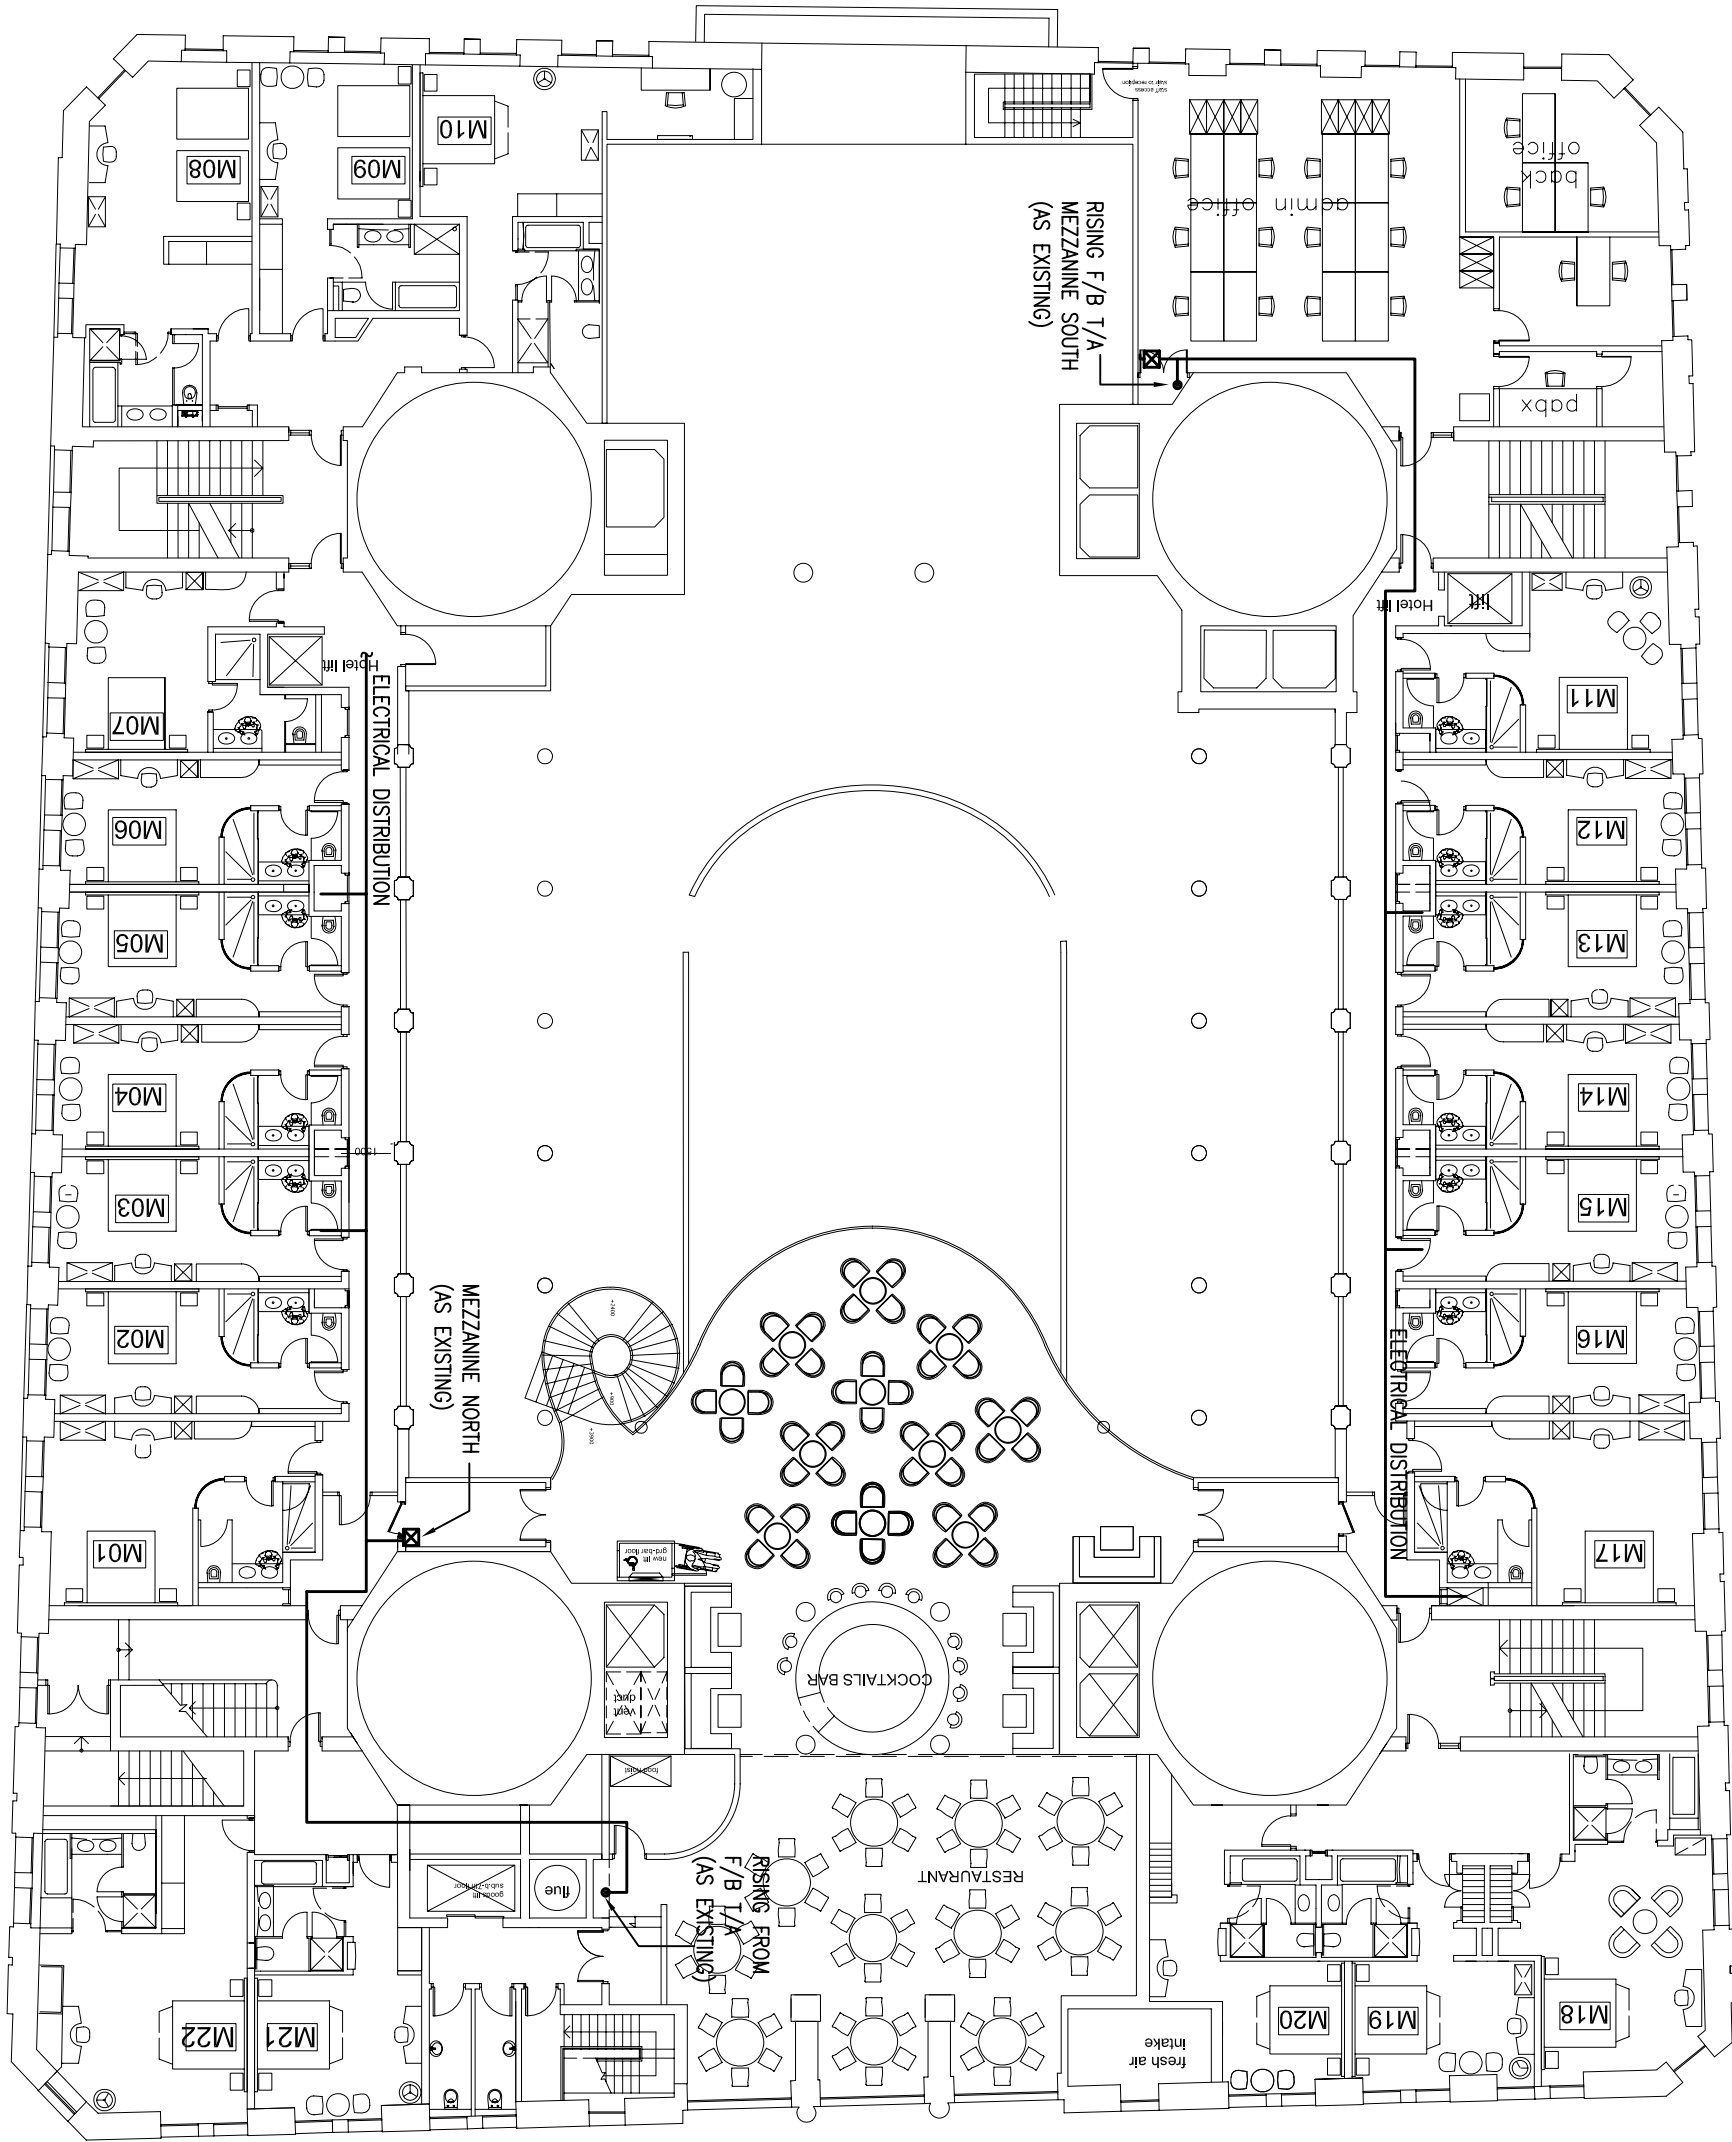

EXCHANGE STREET WEST

EXCHANGE PASSAGE WEST

NOTES.

LEGEND.

P2	15.01.10	REVISED IN LINE WITH ARCHITECTS COMMENTS
P1		PRELIMINARY ISSUE. FOR COMMENT
Rev	Date	Description
		Chkd

HFM Consulting Engineers

1st Floor,  
Courtiels House,  
38 King Street West,  
Manchester  
M3 2WZ

Tel: 0161 833 1410  
Fax: 0161 833 1412



Also At:  
Second Floor, Century Buildings, 31, North John Street, Liverpool, L2 6RG  
Tel: 0151 255 2700 Fax: 0151 255 2701


Project  
MARTINS BANK BUILDING  
LIVERPOOL

Title  
MEZZANINE FLOOR INDICATIVE ELECTRICAL LAYOUT

Engineer	PH	Checked
Job No	L/1247	Date 04.12.09
Drawing No.		Rev. P2
L / 1247 / E / 203		Scale 1:200 @A3



RUMFORD STREET

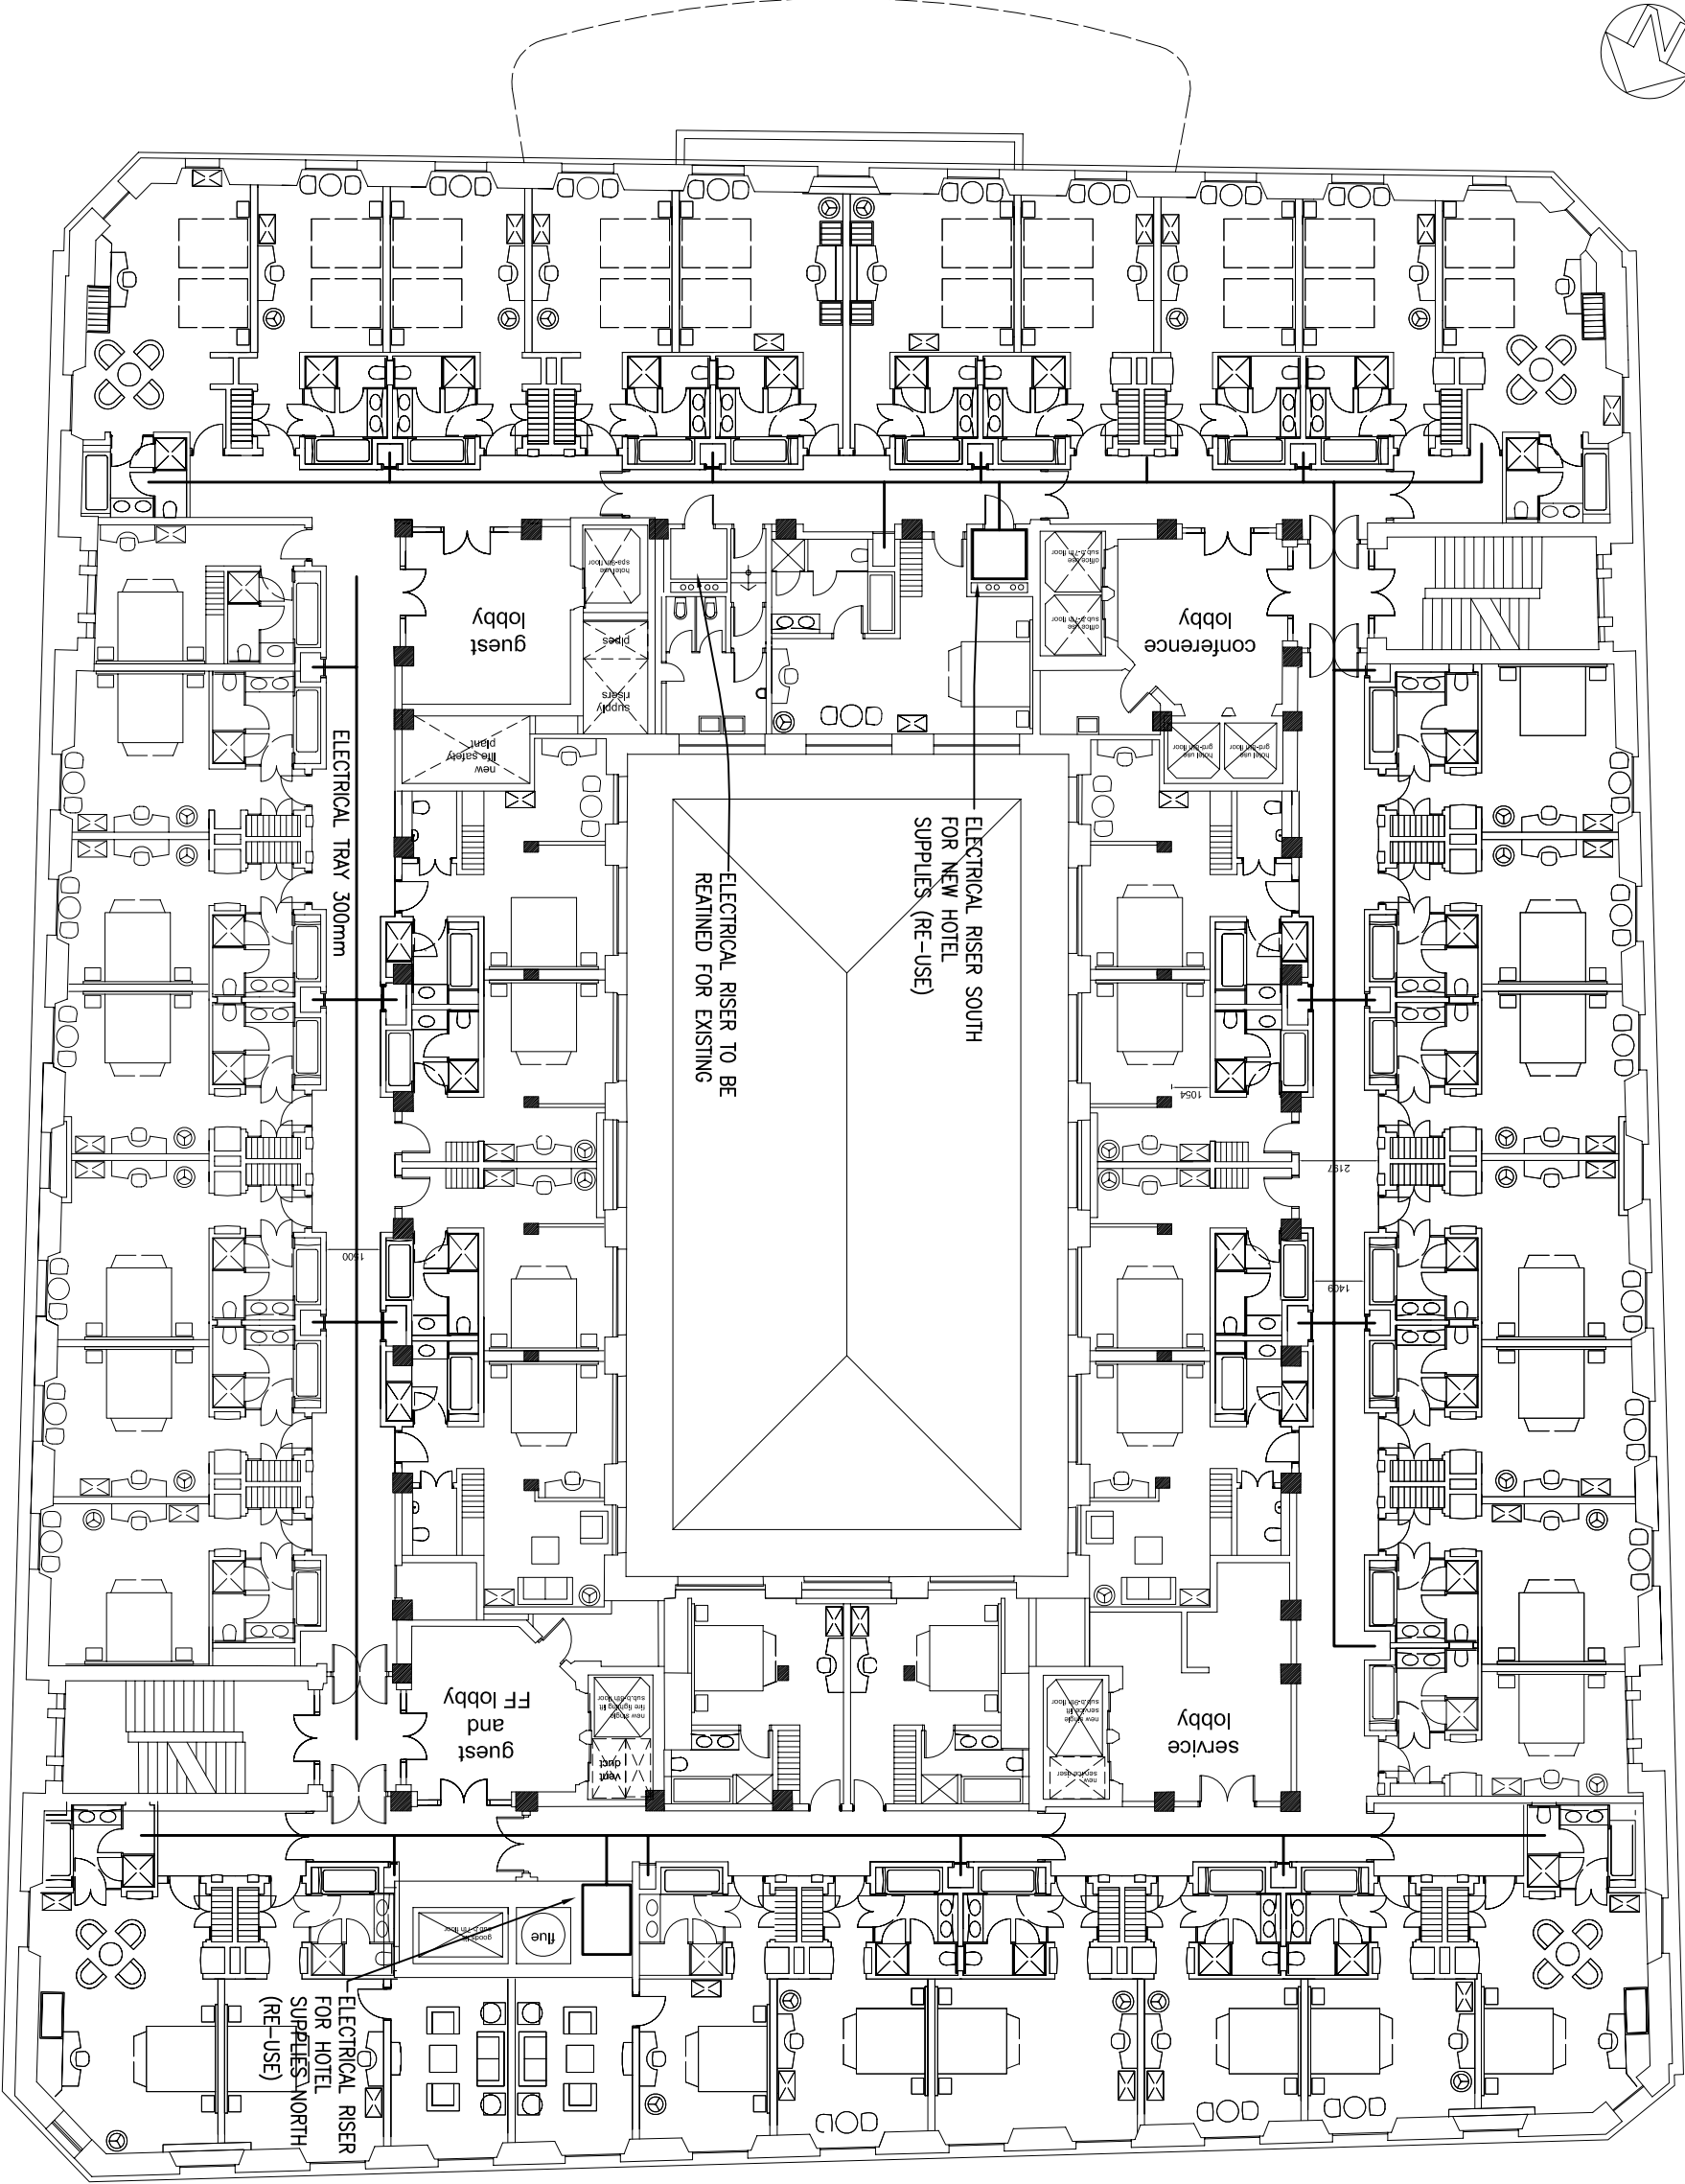

NOTES.

LEGEND.

P1	PRELIMINARY ISSUE. FOR COMMENT		
Rev	Date	Description	Chkd

HFM Consulting Engineers

1st Floor,  
Courtiels House,  
38 King Street West,  
Manchester  
M3 2WZ

Tel: 0161 833 1410  
Fax: 0161 833 1412



Also At:  
Second Floor, Century Buildings, 31, North John Street, Liverpool, L2 6RG  
Tel: 0151 255 2700 Fax: 0151 255 2701

Project  
MARTINS BANK BUILDING  
LIVERPOOL

Title  
SECOND FLOOR INDICATIVE ELECTRICAL LAYOUT

Engineer	PH	Checked	
Job No	L/1247	Date	04.12.09
Drawing No.		Rev.	P1
L / 1247 / E / 205		Scale	1:200 @A3