 

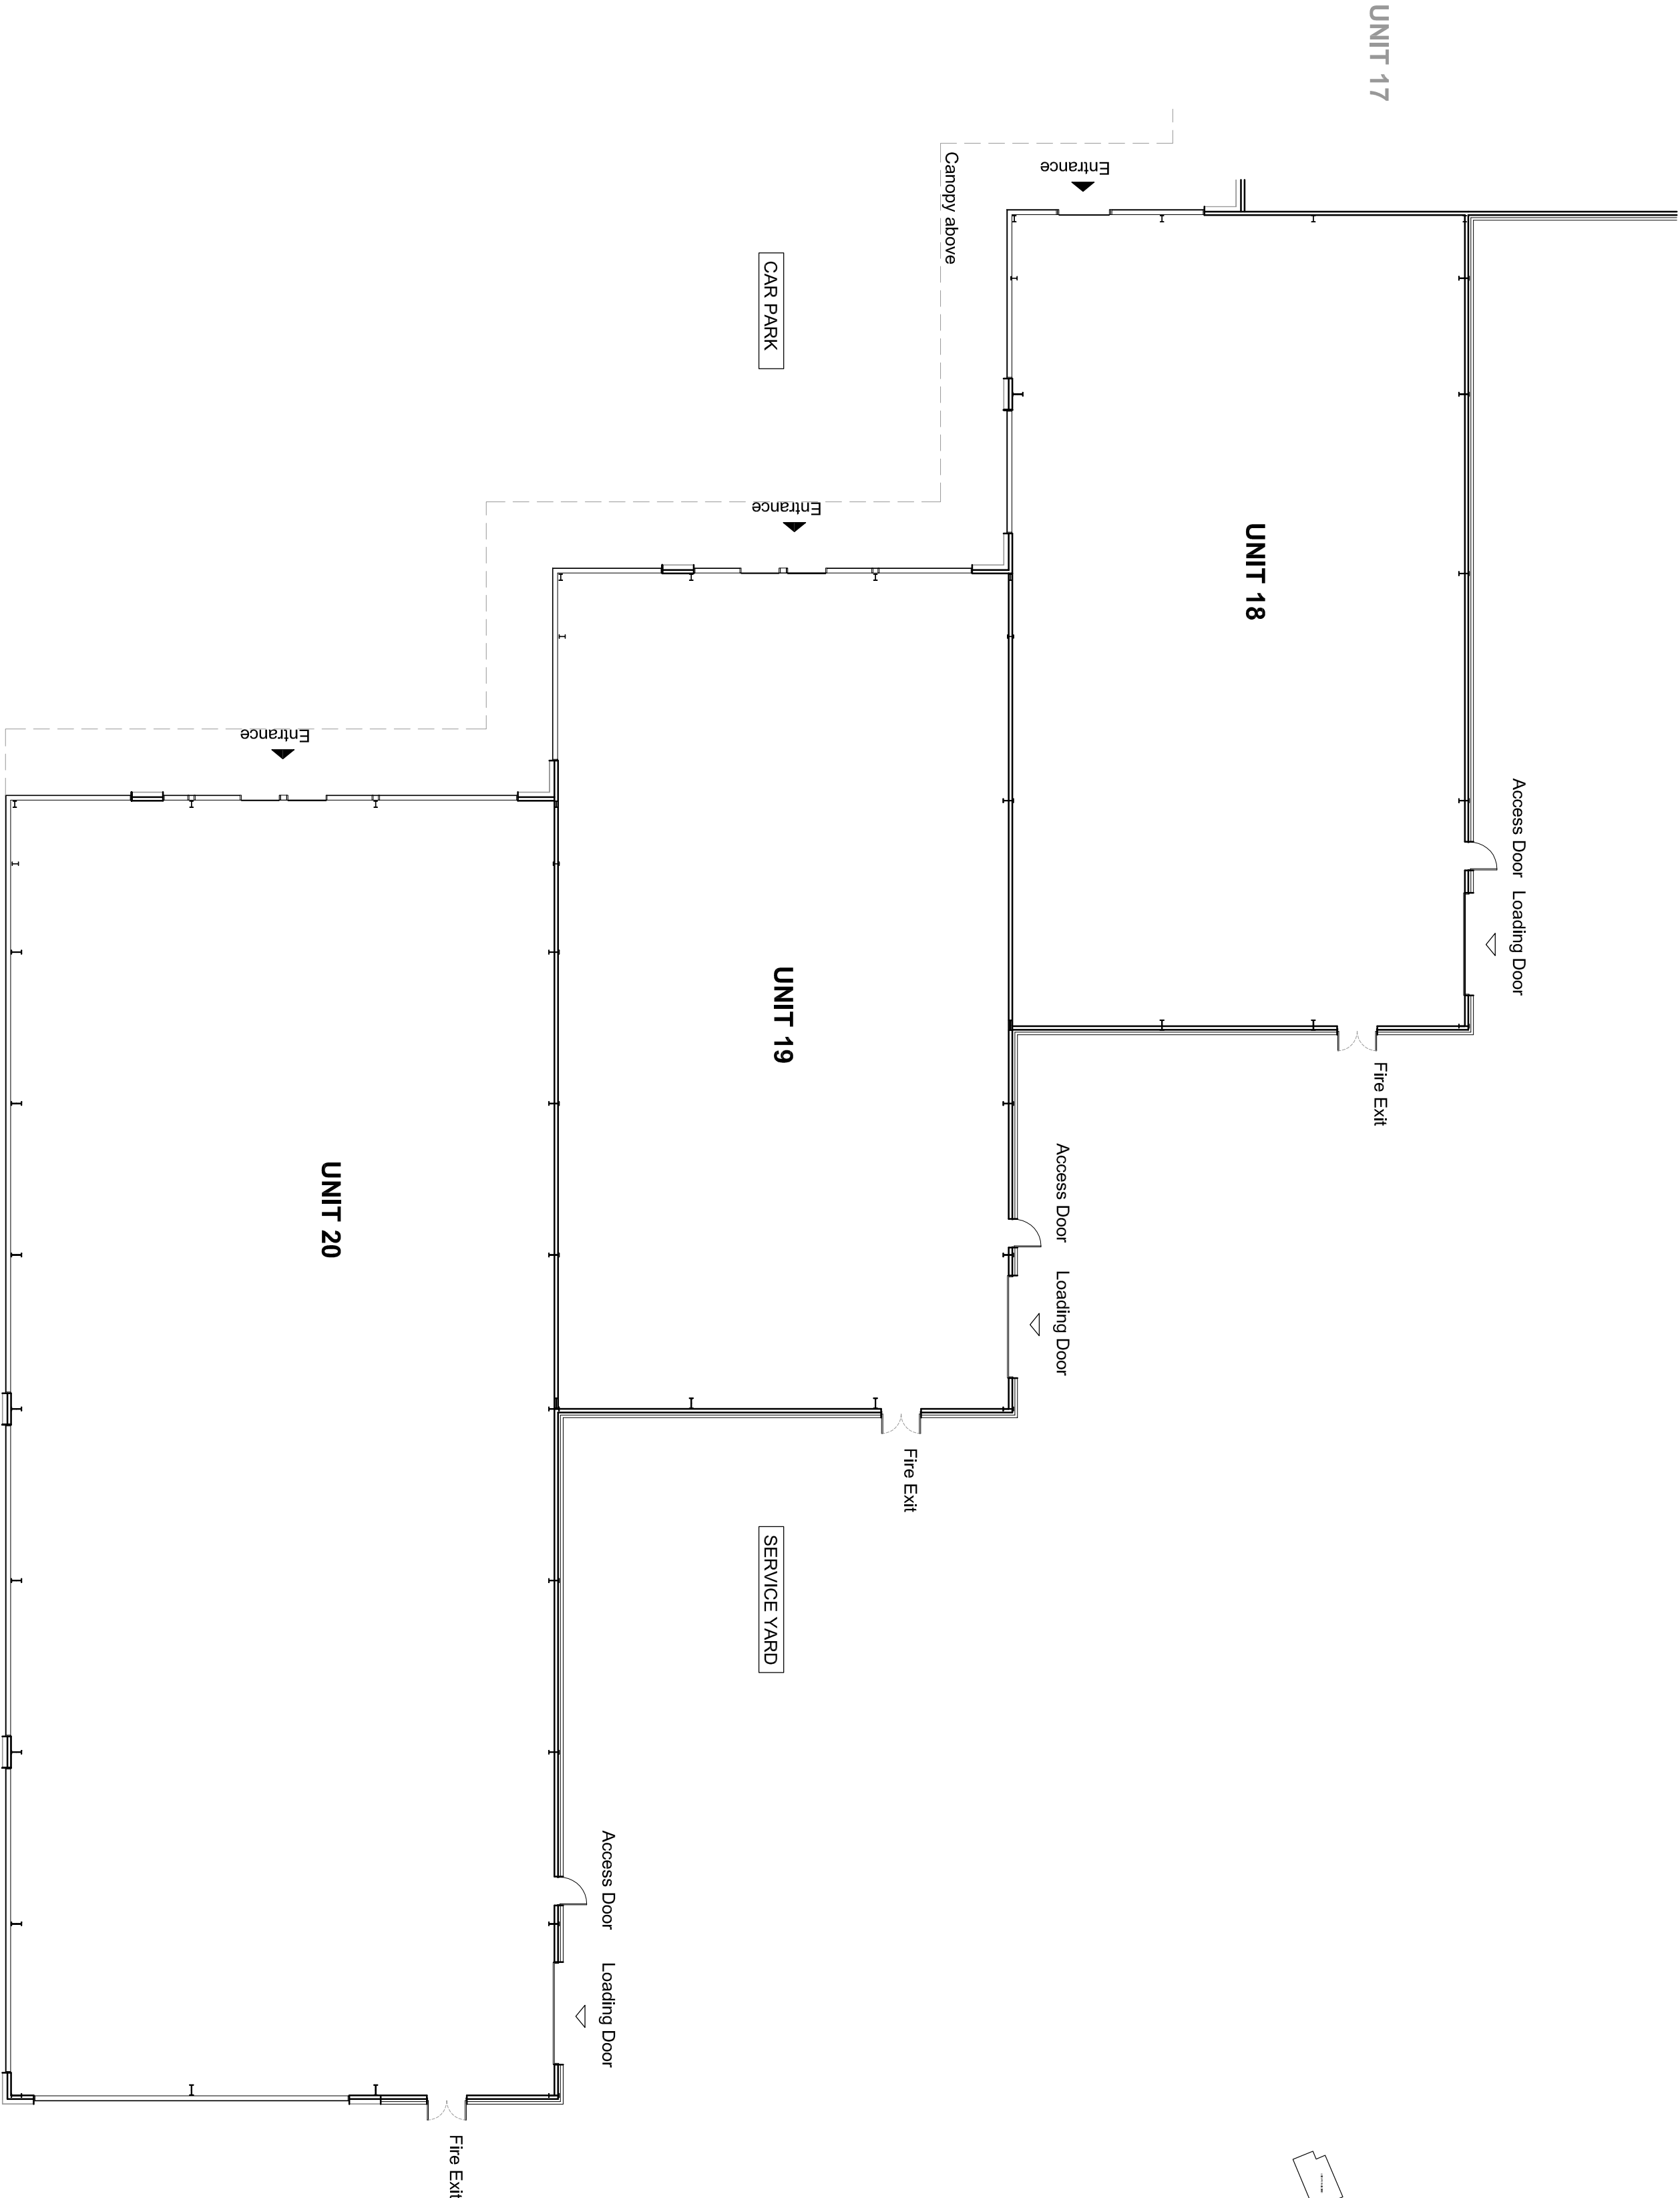


NOTES

- All dimensions and levels are to be checked on site.
- Any discrepancies are to be reported to the architect before any work commences.
- The drawing shall not be scaled to ascertain any dimensions. Work to fixed data only.
- This drawing shall not be reproduced without express written permission from AEW.
- The overall drawings and ownership boundaries are produced using all reasonable endeavours. AEW cannot be held responsible for any inaccuracy or scale discrepancy of data plans supplied to them.

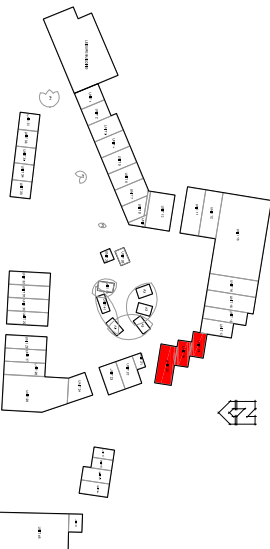

rev	date	drawn	checked
1	30/09/10	CS	RH

Initial Issue

drawing stage

FOR APPROVAL

drawing date

client

DERWENT HOLDINGS LTD

project

EDGE LANE CENTRAL
LIVERPOOL

drawing title

NEW LEISURE/ RETAIL PARK
UNIT 18 TO 20
PROPOSED GROUND FLOOR PLAN

date	30/09/10	drawn	CS
scale	1/200 @ A2	checked	RH



AEW ARCHITECTS AND DESIGNERS LTD
CENTURY BUILDINGS ST MARY'S PARSONAGE
MANCHESTER M3 2DF T:0161 2144370 F:0161 2144371

Job No

DWG No

Rev

M3458 P3-405 A