



GENERAL NOTES

Use written dimensions only, do not scale from drawing. Use latest revision of all referenced information.

 

Rev	Date	Description	Drawn	Chkd
A	30.04.21	Amend - New BT Streethub Structure	MD	JE

#

MONO CONSULTANTS LIMITED
70-76 Steam Packet House
Cross Street
Manchester, M2 4JG
t. 44 (0)161 839 8839
www.monoconsultants.com



Drg Status PLANNING	
Cell No. & Name 1-LIV001	
Site Name & Address 2 BOLD STREET (JCN HANOVER ST), LIVERPOOL, L1 4DS	
Drawing Title PROPOSED SITE PLAN	
Scale 1:100	Date 30.04.2021
Drawn By MD	Checked By JE
Drawing Number 002	Revision A

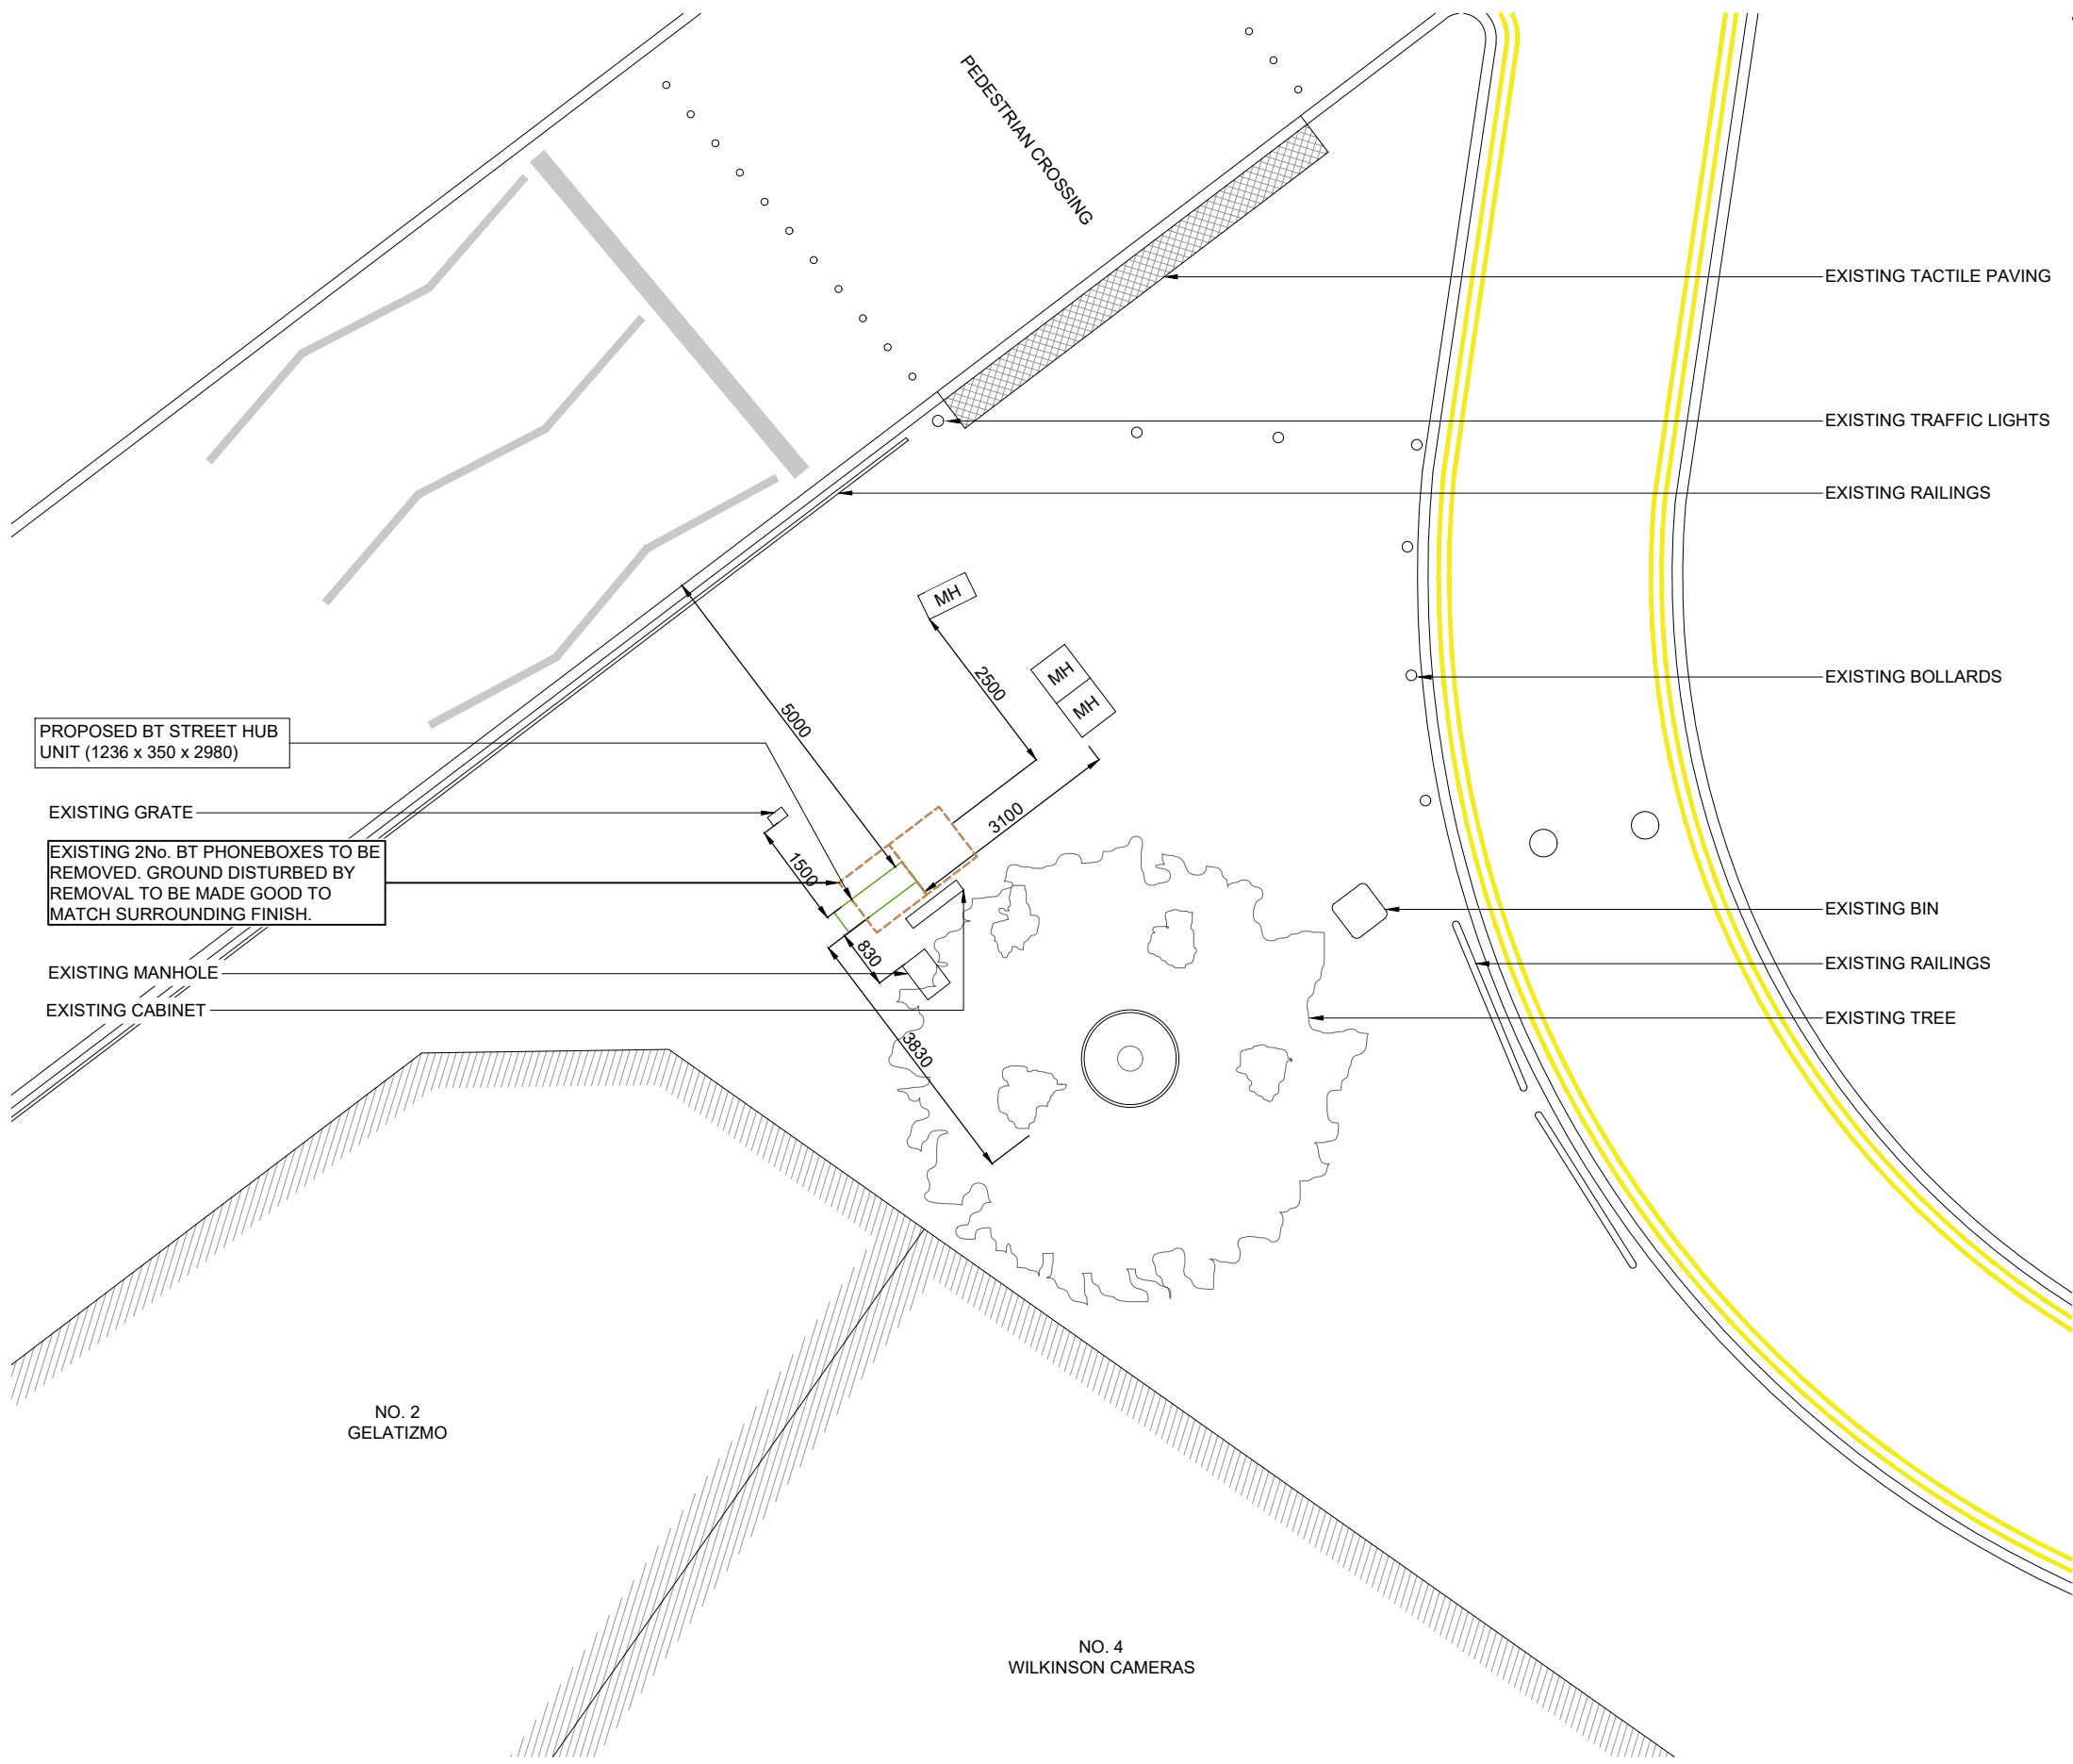

PROPOSED SITE PLAN
SCALE 1:100