



GENERAL NOTES

Use written dimensions only, do not scale from drawing. Use latest revision of all referenced information.

Rev	Date	Description	Drawn	Chkd
A	30.04.21	Amend - New BT Streethub Structure	MD	JE



MONO CONSULTANTS LIMITED

70-76 Steam Packet House

Cross Street

Manchester, M2 4JG

t. 44 (0)161 839 8839

www.monoconsultants.com



Drg Status
PLANNING

Cell No. & Name

 

1-LIV001

Site Name & Address

OS NO. 76-78 LORD STREET,
(NR JCN PARADISE ST)
LIVERPOOL,
L2 1TL

Drawing Title
PROPOSED SITE PLAN

Scale	1:100	Date	30.04.2021
Drawn By	MD	Checked By	JE
Drawing Number	002	Revision	A

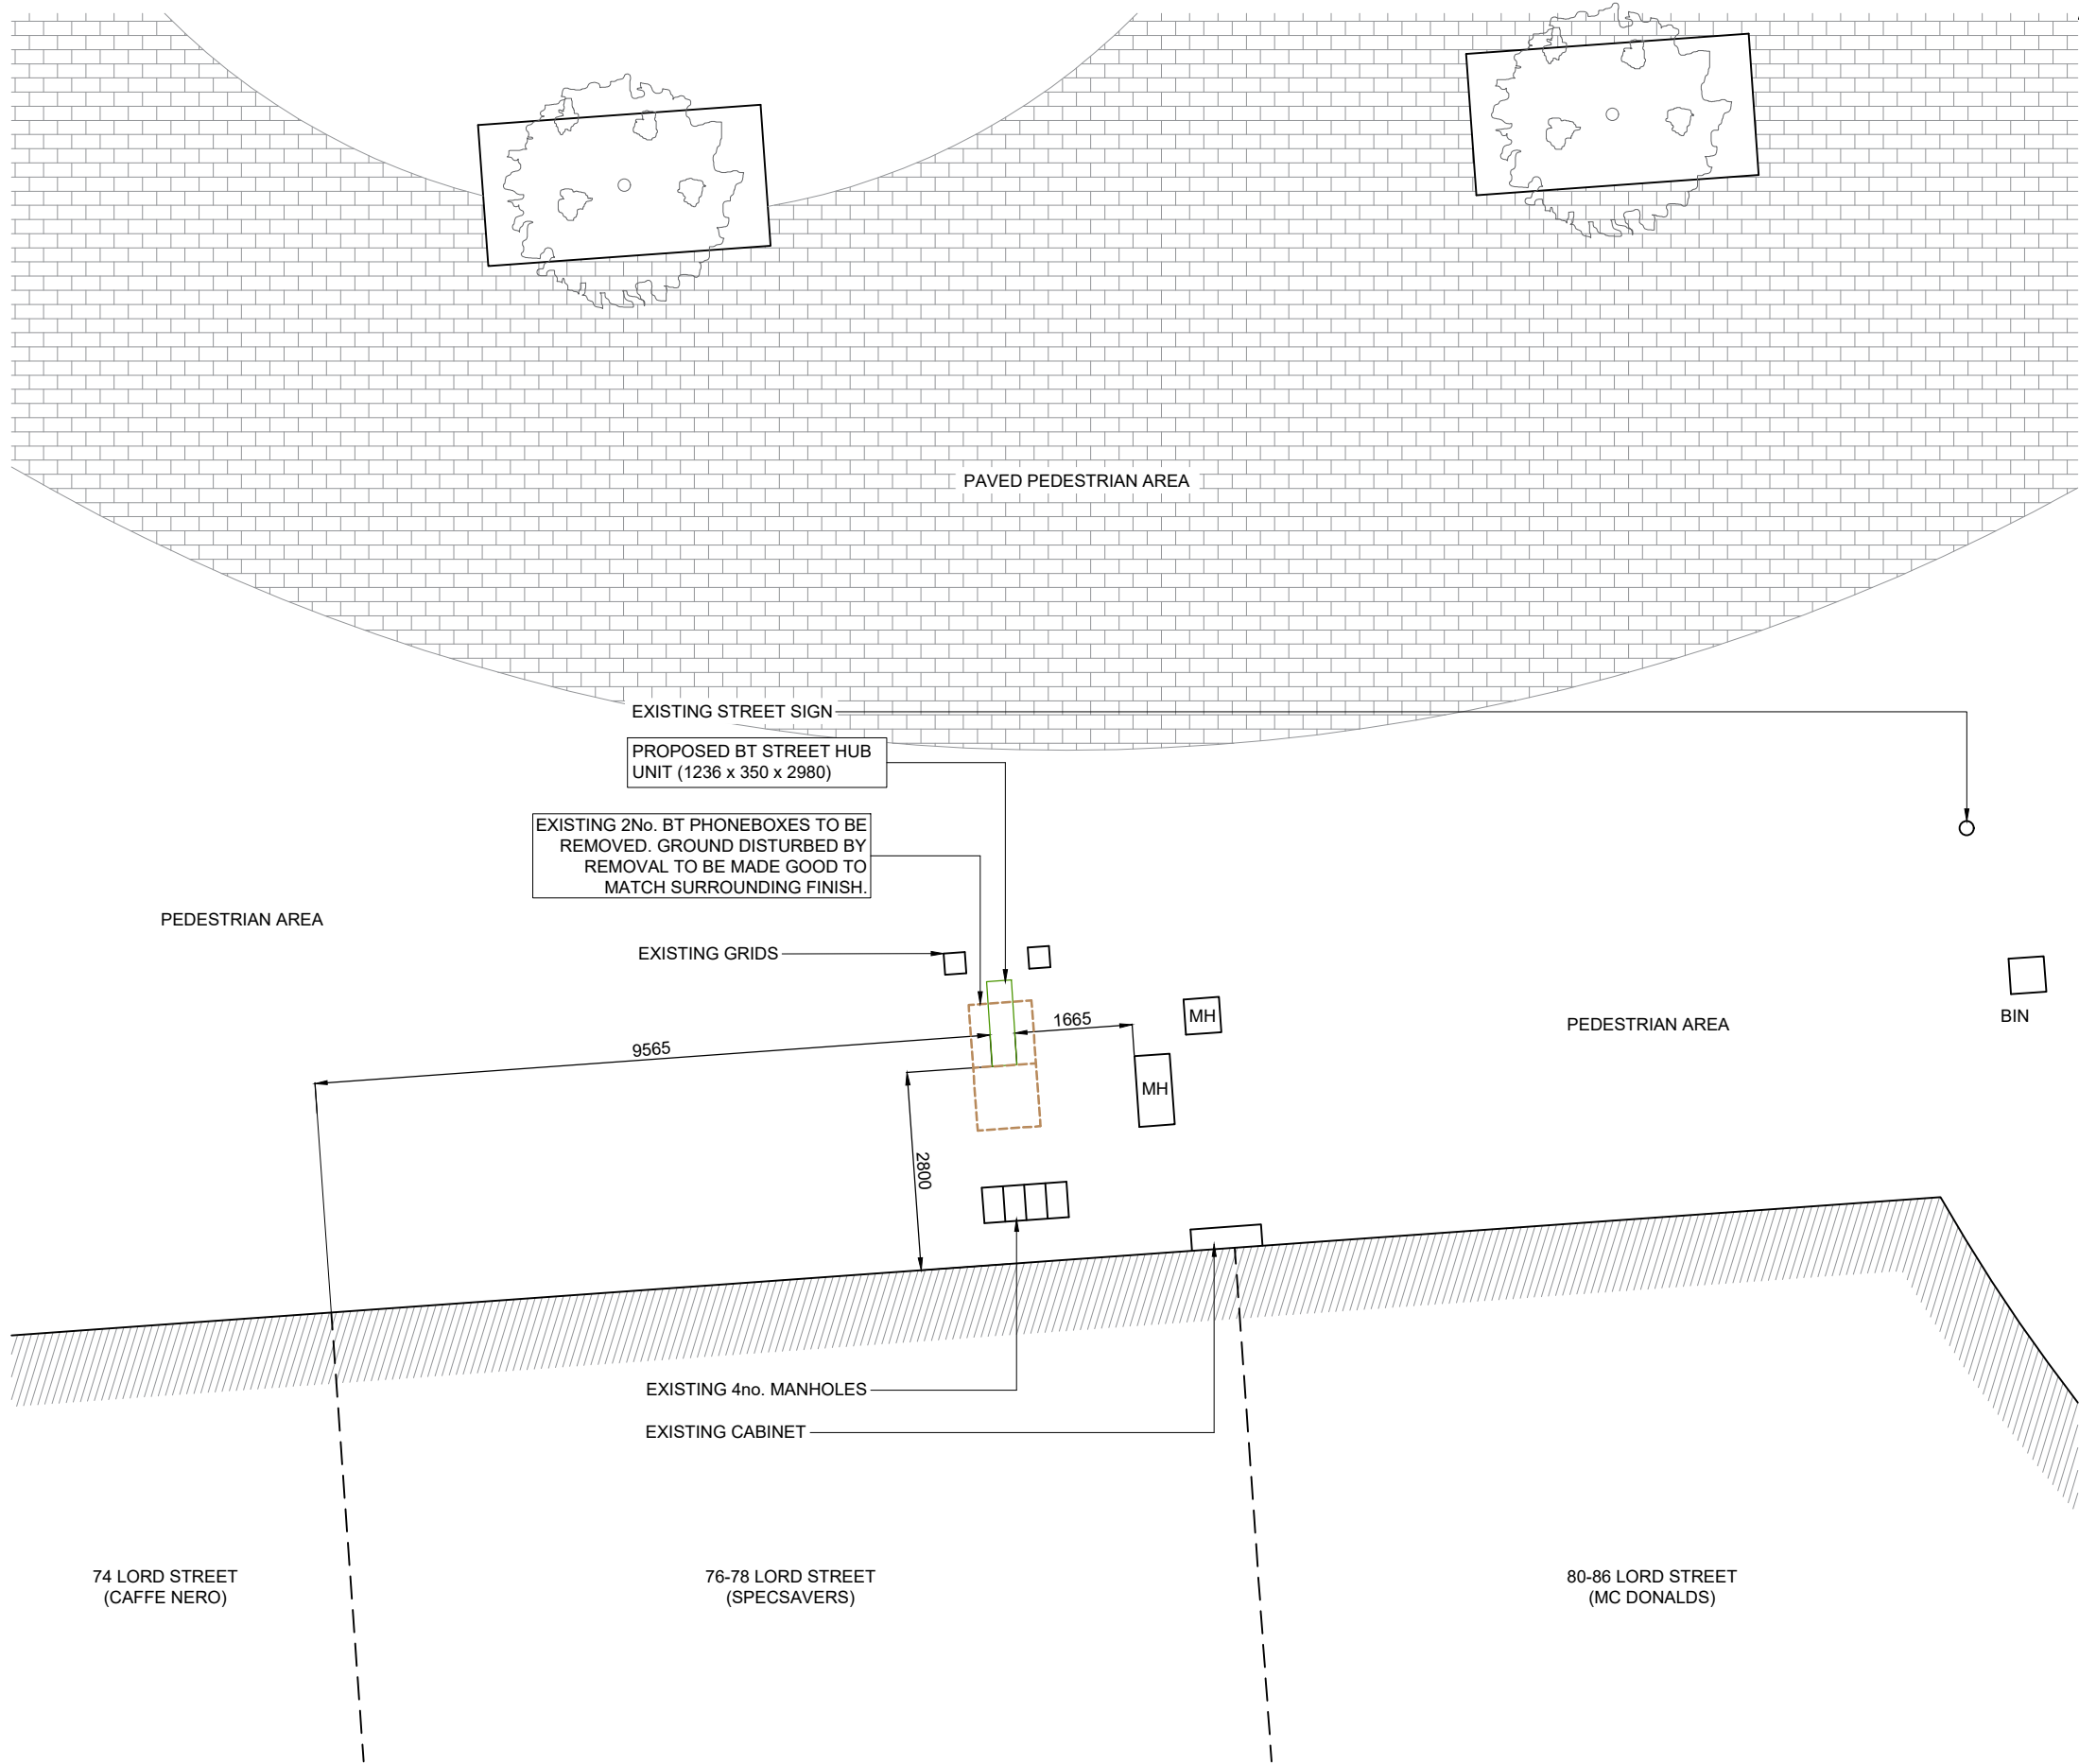

PROPOSED SITE PLAN
SCALE 1:100