


LEGEND/NOTES  
THIS DRAWING IS TO BE READ IN CONJUNCTION WITH AND FORMS PART OF THE PROJECT DOCUMENTS LISTED BELOW:

CIVILS DESIGN SUBMISSION  
BDG0117/CIV/FORM2  
BDG0117/CIV/FORM3  
BDG0117/CIV/DC  
BDG0117/CIV/DRA  
BDG0117/CIV/ECL  
BDG0117/CIV/SPEC  
BDG0117/DRG/A001  
BDG0117/DRG/A002  
BDG0117/DRG/A003  
BDG0117/DRG/A004  
BDG0117/DRG/A005

STATEMENT OF DESIGN INTENT  
CERTIFICATE OF DESIGN AND CHECK  
INTERDISCIPLINARY DESIGN CHECK CERTIFICATE  
DESIGNER RISK ASSESSMENT  
ENVIRONMENTAL CHECKLIST  
NBS SPECIFICATION / MODEL CLAUSES  
EXISTING GA PLANS, ELEVATIONS & SECTIONS  
PROPOSED ROOF PLANS & ELEVATIONS  
PROPOSED GENERAL ARRANGEMENT PLAN & SECTIONS  
TYPICAL DETAILS SHEET 1  
TYPICAL DETAILS SHEET 2

M&E DESIGN SUBMISSION  
BDG0117/ENG/FORM2  
BDG0117/ENG/FORM3  
BDG0117/CIV/DC  
BDG0117/CIV/DRA  
BDG0117/DRG/E001  
BDG0117/DRG/E002

STATEMENT OF DESIGN INTENT  
CERTIFICATE OF DESIGN AND CHECK  
INTERDISCIPLINARY DESIGN CHECK CERTIFICATE  
DESIGNER RISK ASSESSMENT  
SCHEMATIC  
PROPOSED LIGHTING LAYOUT AND DISTRIBUTION  
SCHEMATIC  
LNW ENGINEERING SPECIFICATION FOR ELECTRICAL INSTALLATIONS

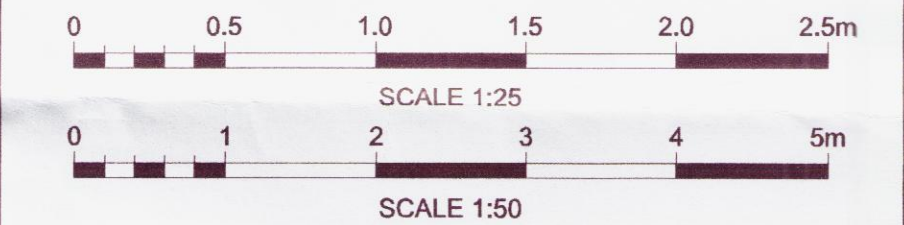

|     |            |                          |  |       |      |       |
|-----|------------|--------------------------|--|-------|------|-------|
| P01 | 06/08/2012 | DRAFT ISSUE              |  | DPC   | JP   | JW    |
| REV | DATE       | DESCRIPTION OF REVISIONS |  | DRAWN | CHKD | APPRD |

SAFETY HEALTH AND ENVIRONMENTAL INFORMATION

THE HAZARDS AND RISKS ASSOCIATED WITH THE WORKS SHOWN ON THIS DRAWING AND DESCRIBED IN THE SCHEDULE OF WORKS ARE CONSIDERED TO BE WITHIN THE REASONABLE, NORMAL AND ACCEPTABLE LIMITS FOR GENERAL BUILDING AND MAINTENANCE WORKS. PLEASE REFER TO DESIGNER RISK ASSESSMENT  
DOCUMENT REF: BDG0117/DRA

STATUS  
DRAFT ISSUE




PROJECT: BDG0117  
AIGBURTH CANOPY REFURBISHMENT

DRAWING TITLE  
PROPOSED GENERAL ARRANGEMENT PLAN & SECTIONS

|          |               |        |  |      |            |
|----------|---------------|--------|--|------|------------|
| DESIGNED | J. POWELL     | SIGNED |  | DATE | 23/07/2012 |
| DRAWN    | D. CARVER     | SIGNED |  | DATE | 23/07/2012 |
| CHECKED  | S. ELLIS      | SIGNED |  | DATE | 28/07/2012 |
| APPROVED | J. WINSTANLEY | SIGNED |  | DATE | 28/07/2012 |


SCALE(S) AT A1 SHEET SIZE 594 X 841  
1:50, 1:25  
ALTERNATIVE REFERENCE  
ELR & MILEAGE  
HXS1 3.1716

DRAWING NUMBER  
123351/DRG/A003  
BDG0117/DRG/A003  
REVISION  
P01

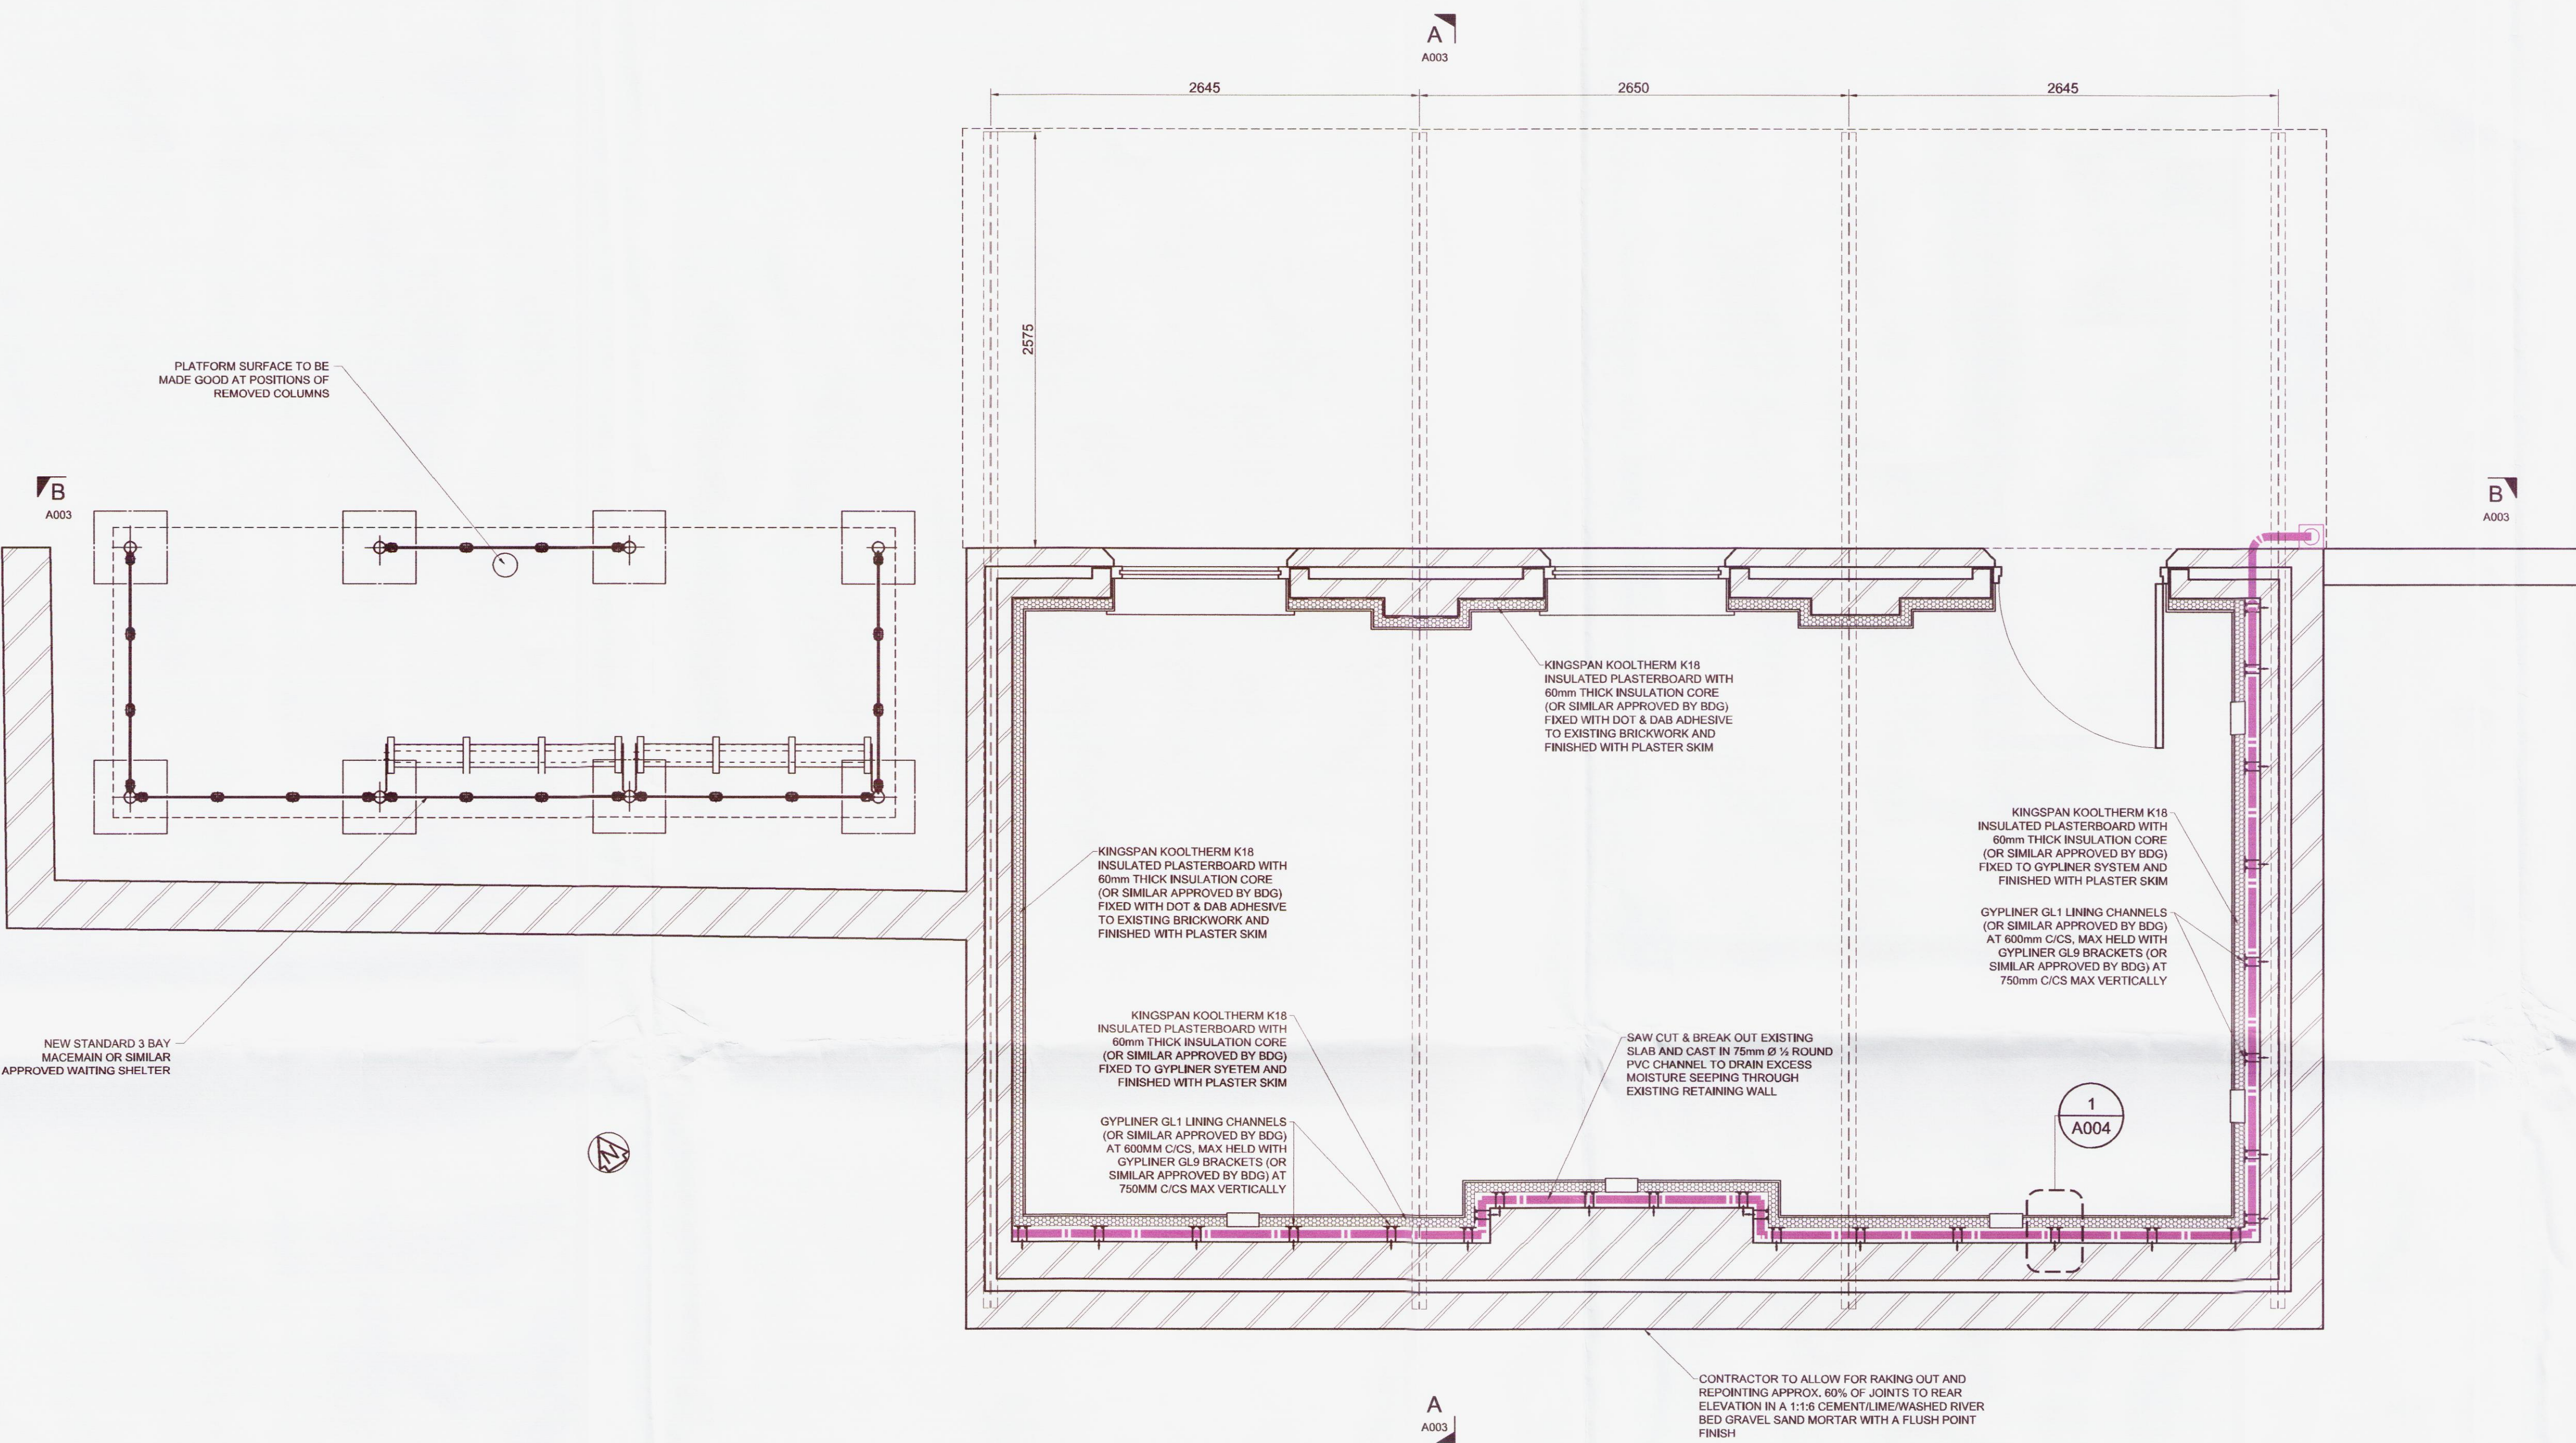


PROPOSED LIVERPOOL BOUND PLATFORM BUILDING GENERAL ARRANGEMENT PLAN

SCALE 1:25

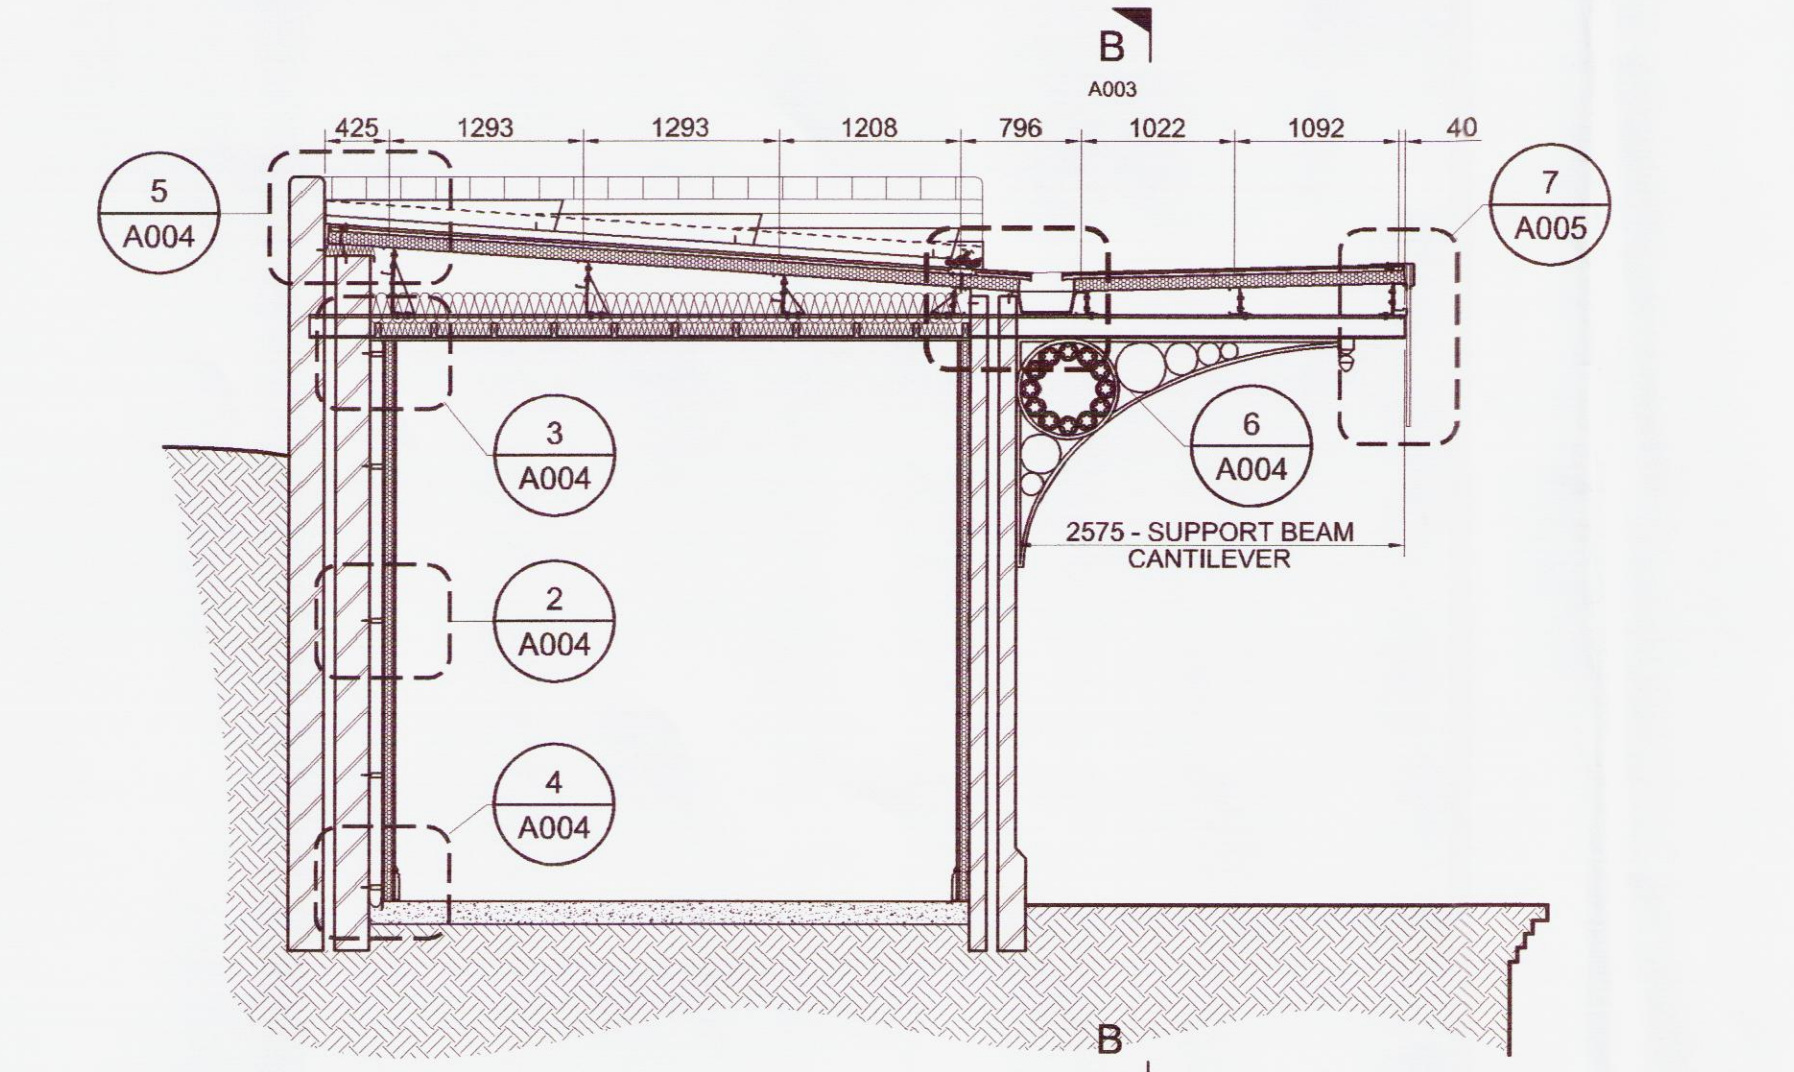

TYPICAL PLATFORM BUILDING SECTION A-A

SCALE 1:50

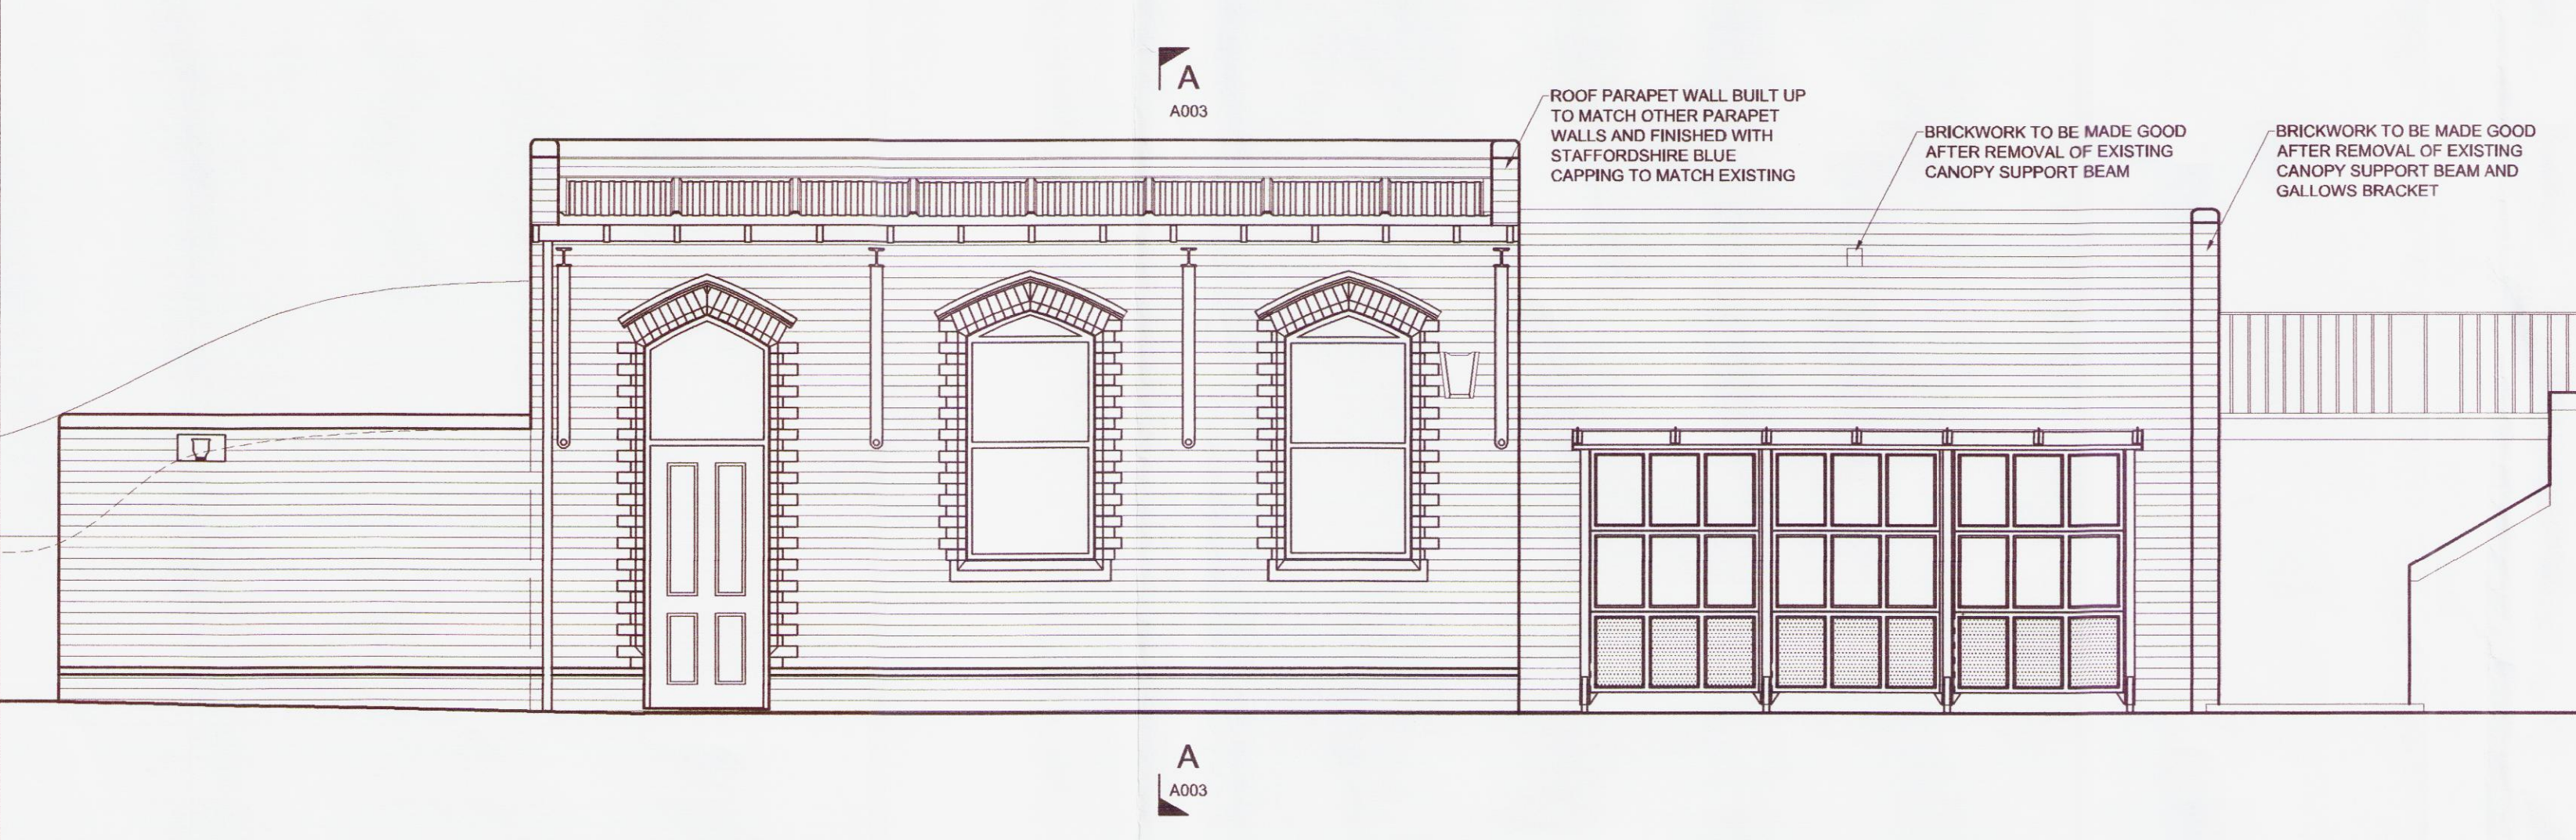

TYPICAL PLATFORM BUILDING CANOPY SECTION B-B

SCALE 1:50

12PM 2712

23 OCT 2012