
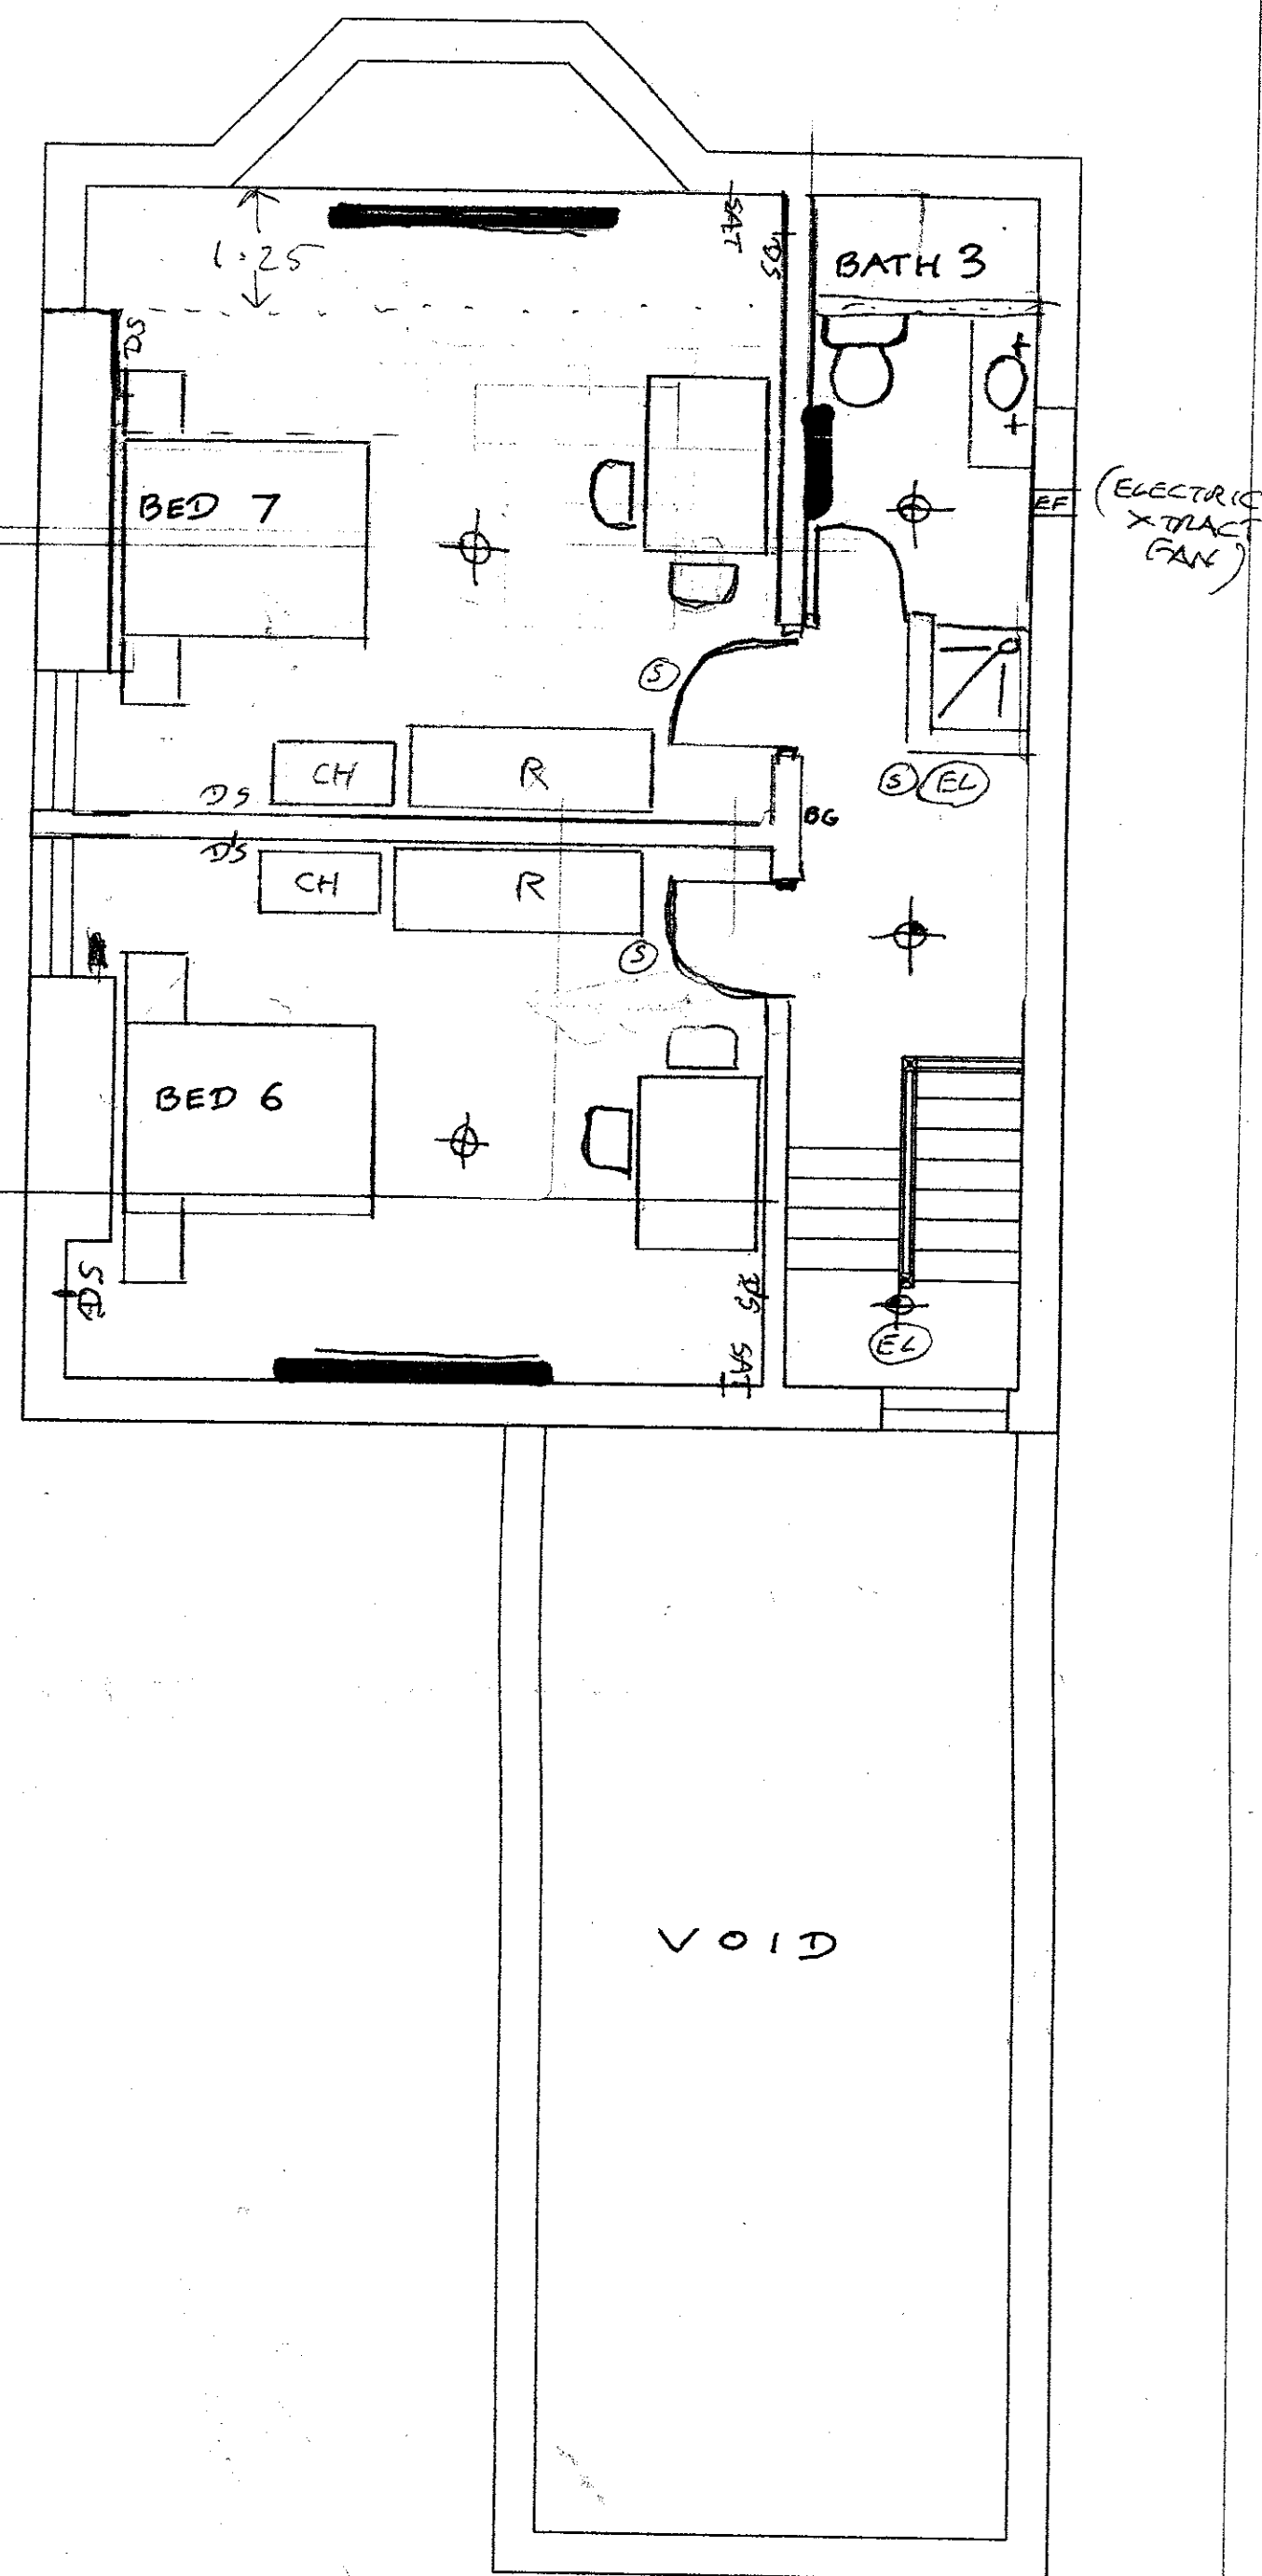
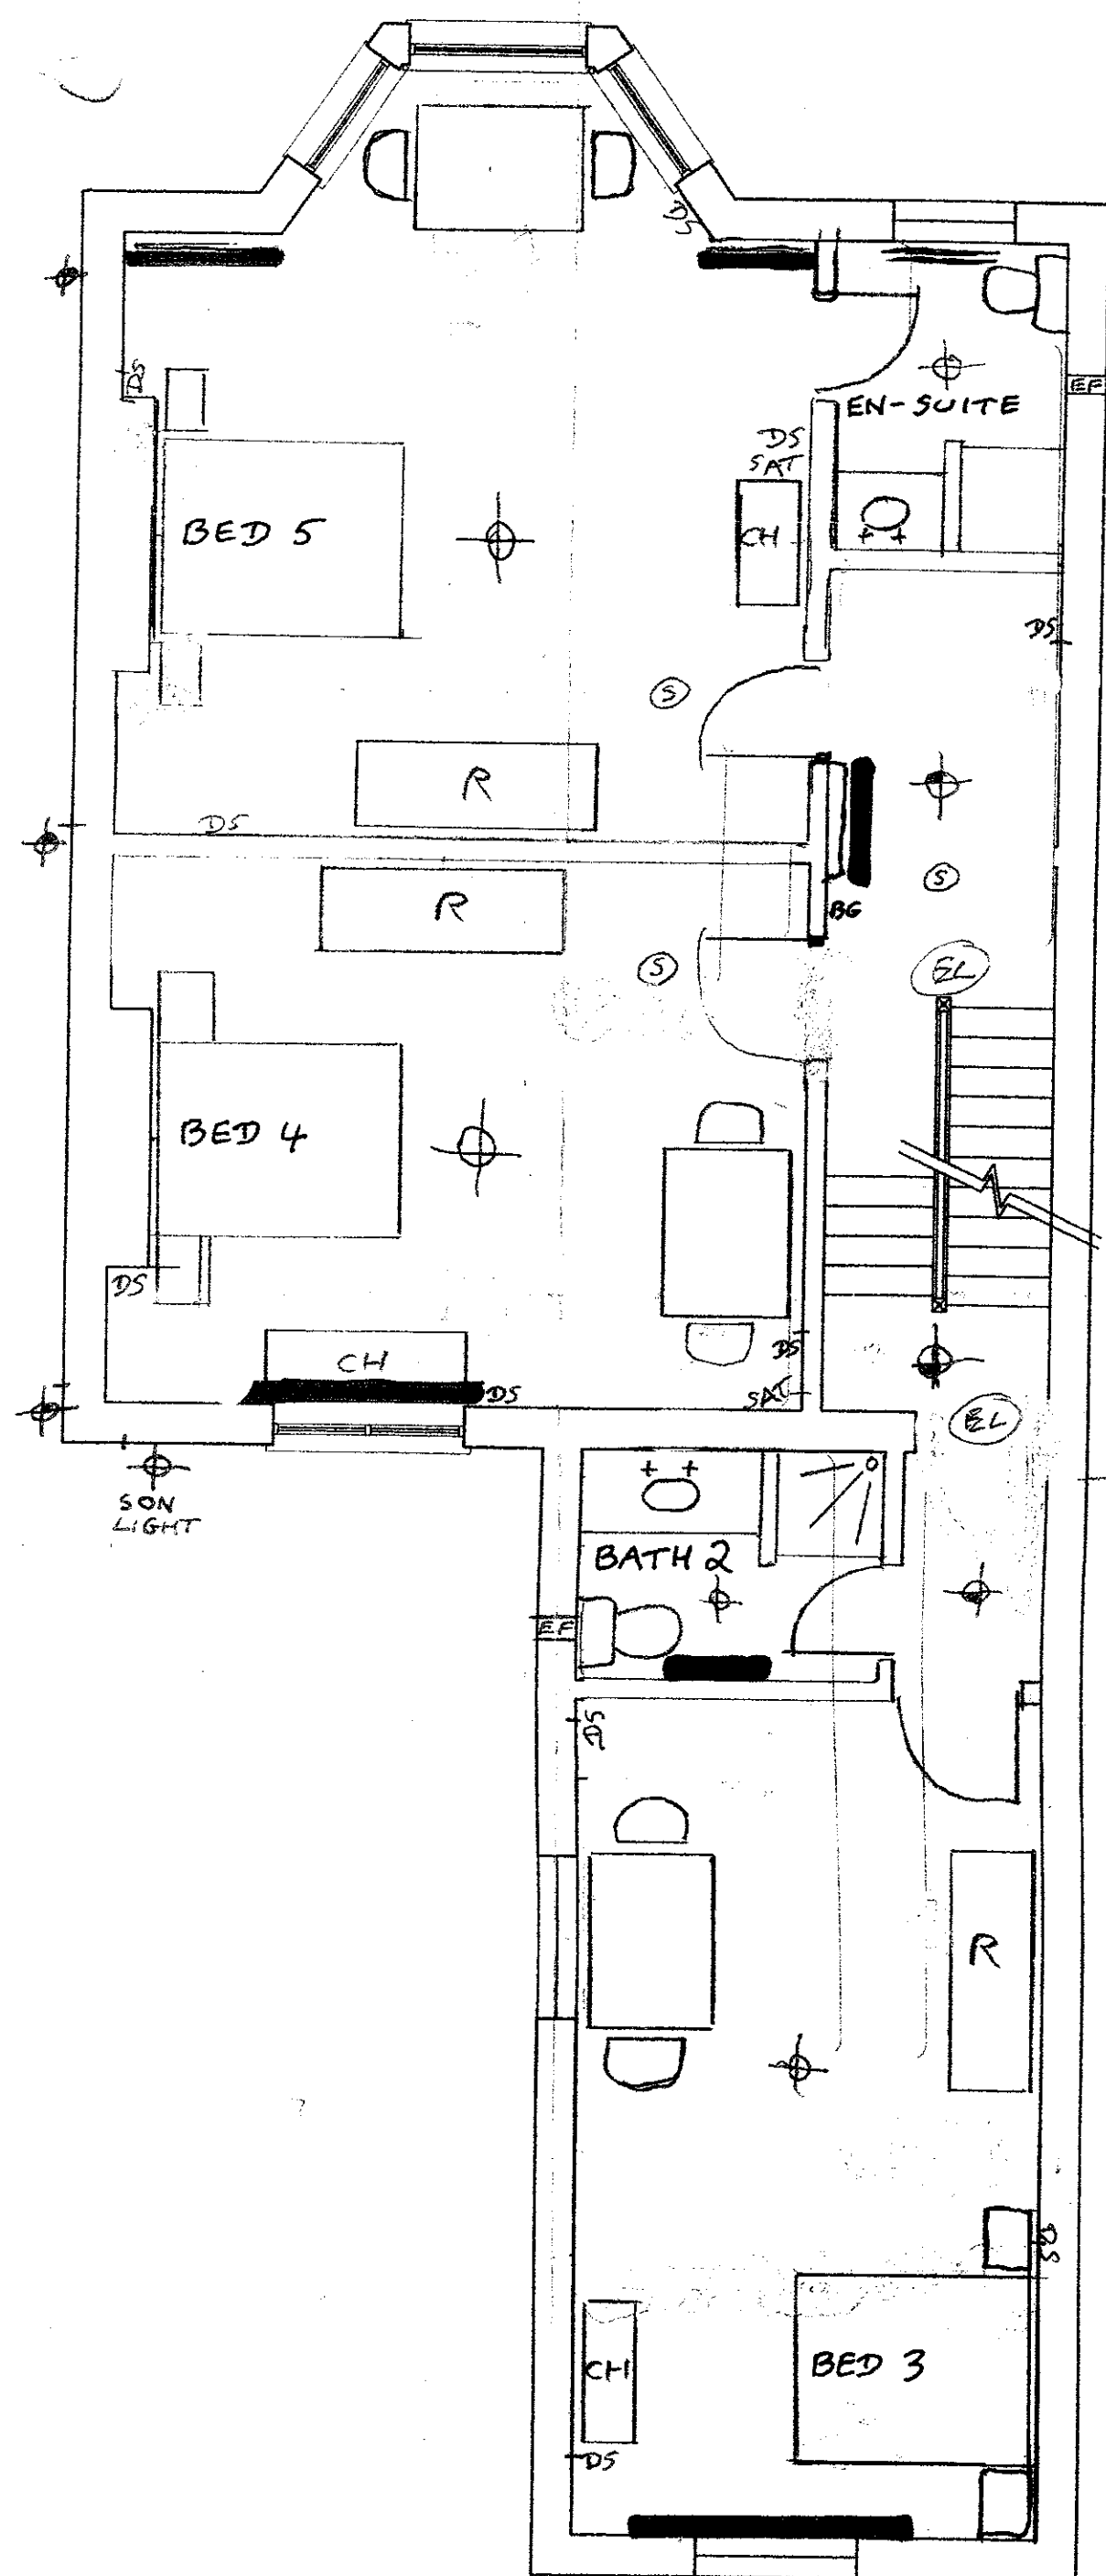
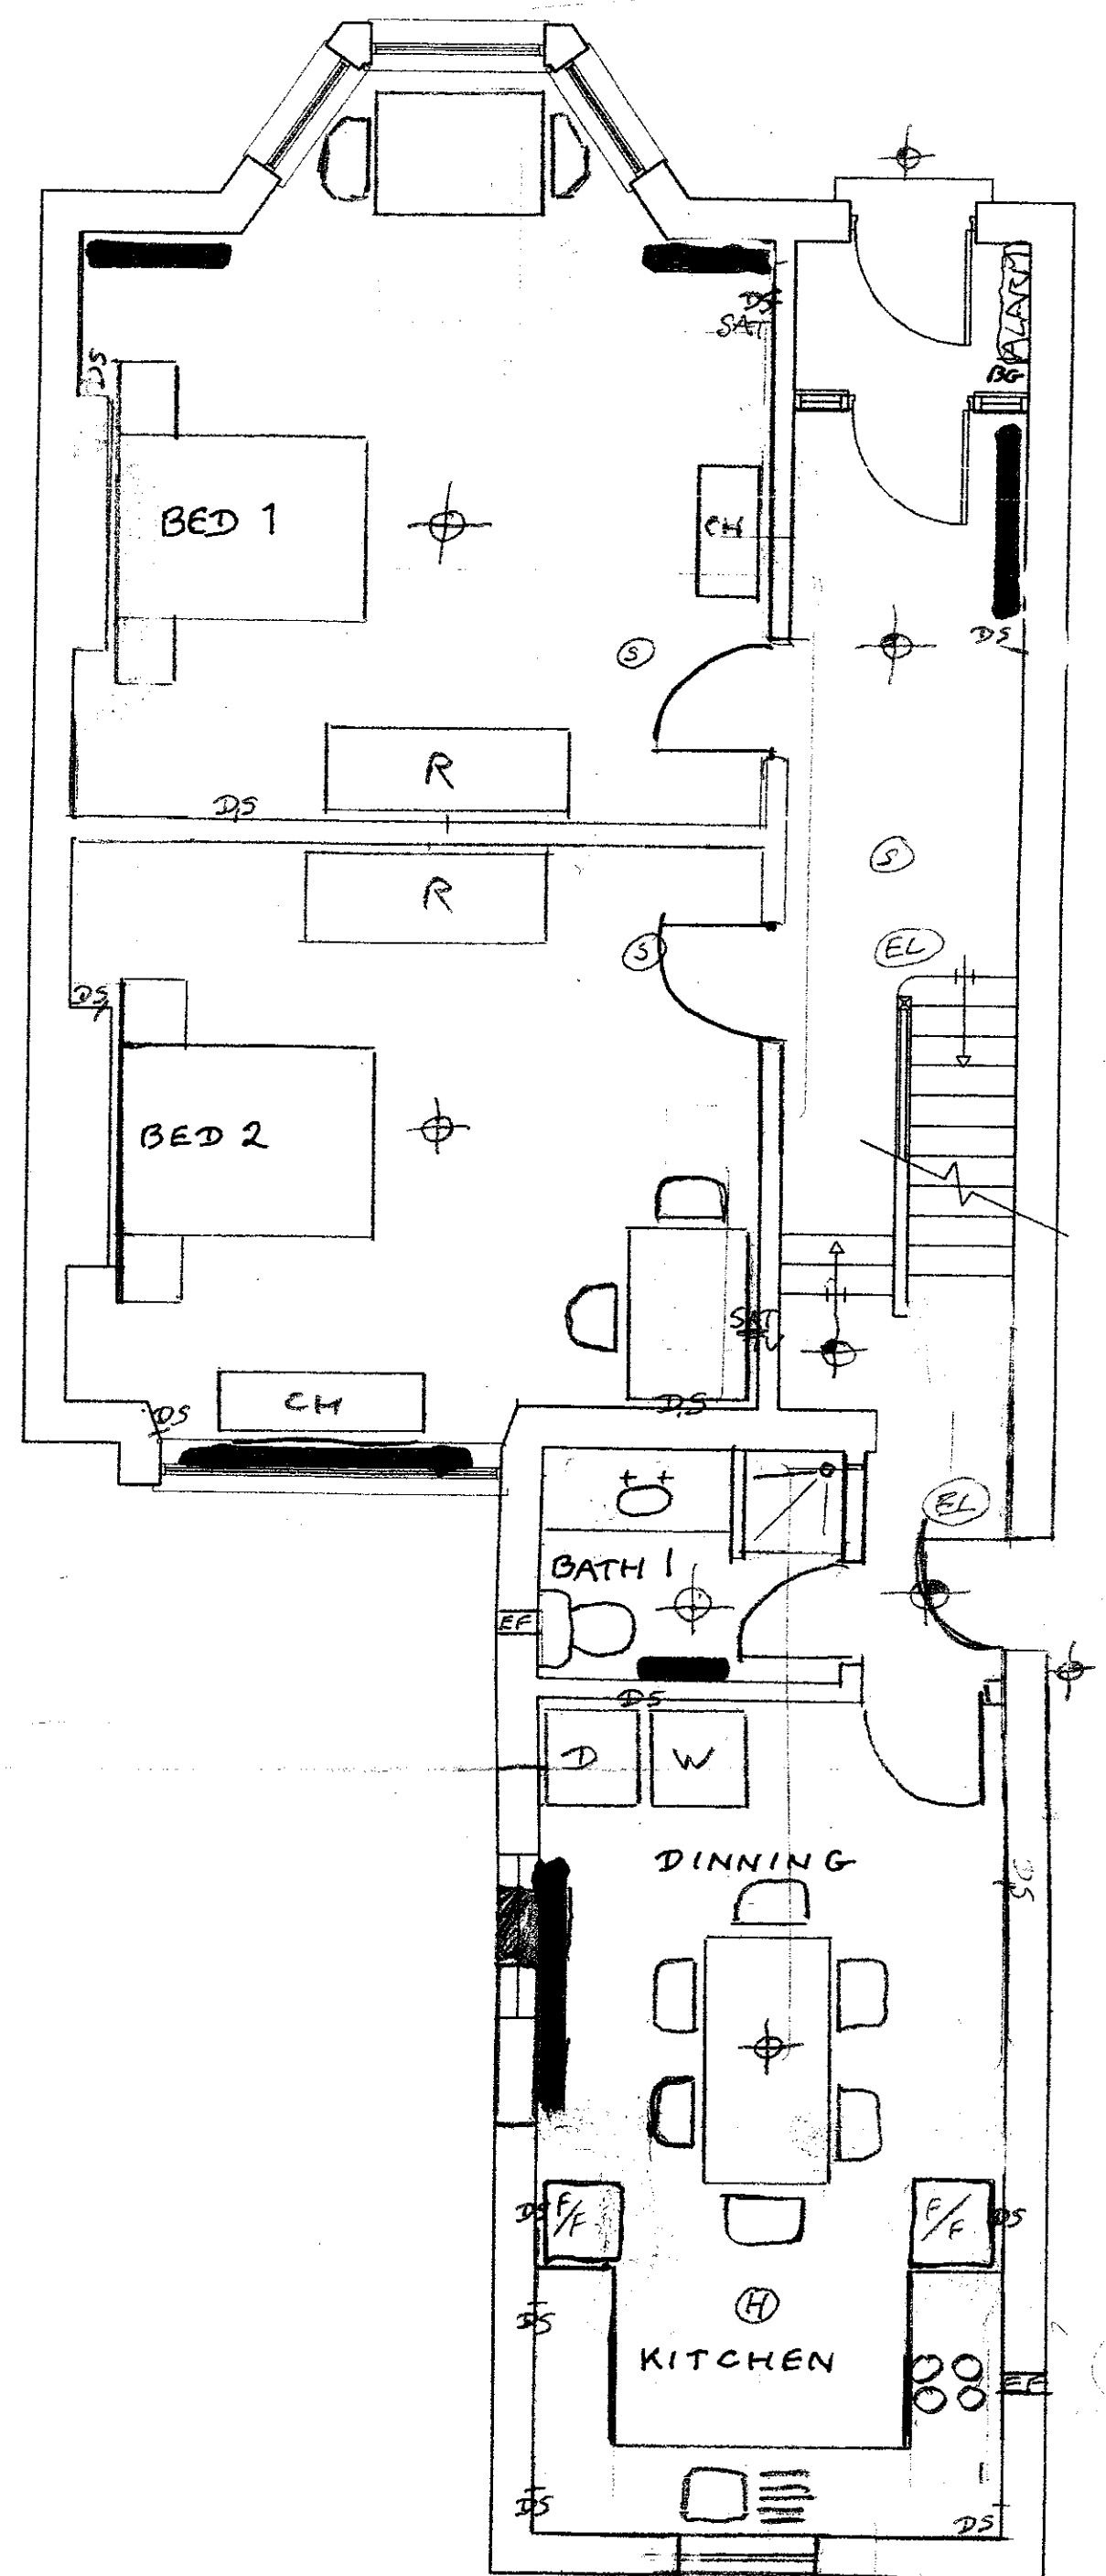


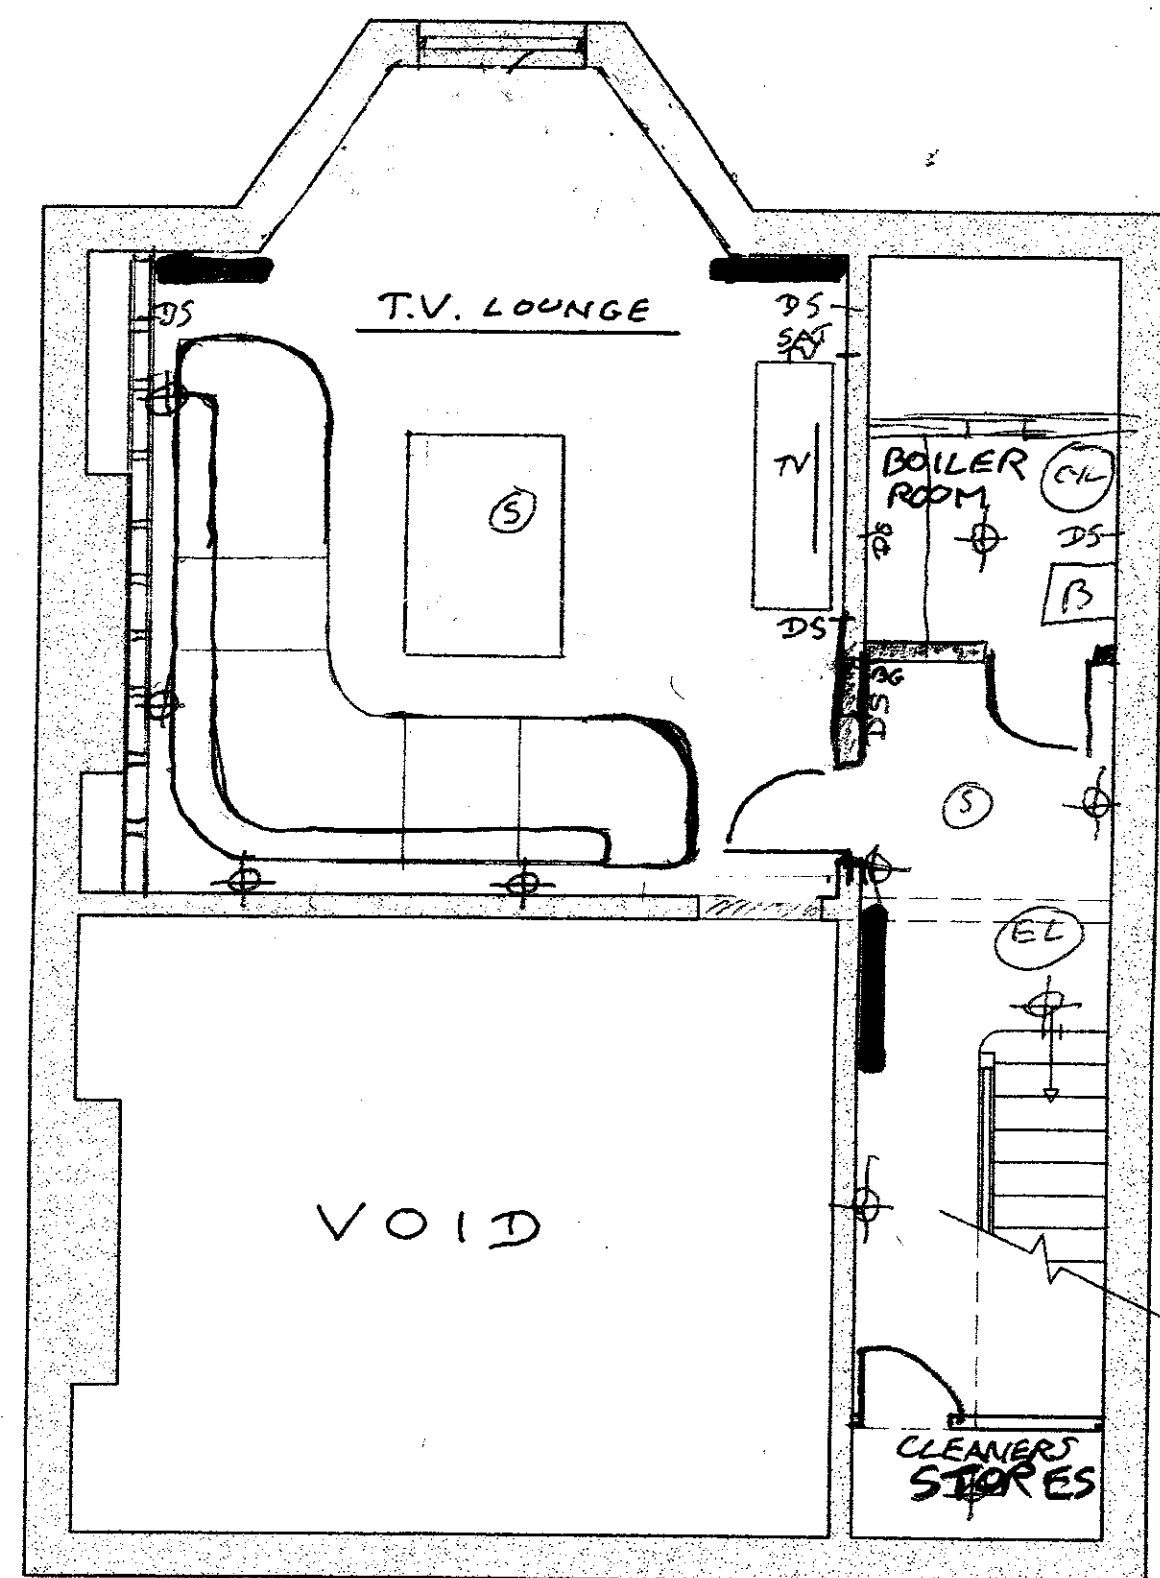

B BOILER-GAS
CYL HOT WATER CYLINDER
D TUMBLE DRYER
F/P FRIDGE FREEZER
R WARDROBE
CH CHEST OF DRAWERS

15/01/2009
26/11/15

⊕ LIGHT FITTING ON LIGHT SENSOR
⊕ LIGHT FITTING
— D.P. RADIATOR
DS ELECTRIC POINT
SAT TELEVISION POINT, SATELLITE TV, DAB, FM. PHONE.
BG FIRE ALARM BREAK GLASS
⊙ SMOKE DETECTOR
⊙ HEAT DETECTOR
⊙ EMERGENCY LIGHT

PROPOSED CELLAR PLAN

PROPOSED GROUND FLOOR PLAN

PROPOSED FIRST FLOOR

PROPOSED SECOND FLOOR

architectural	landscape	interiors	urban design	graphics	project services	SCALE	DRAWN	CHECKED	DATE	DESCRIPTION
This drawing is copyright. Figured dimensions take preference. All dimensions to be checked on site and any discrepancy or variation reported before proceeding.						1:50@A1, 1:100@A3	CH		SEPTEMBER 2009	36 Queens Drive, Liverpool
						PRESTON The Root House Clifton Fields PR4 0XG 01772 639550 FAX 01772 639555 e-mail prestonoffice@heyesarchitects.co.uk LIVERPOOL 36 Onel Chambers 14 Water Street L2 8TD 0151 255 1222 FAX 0151 255 1593 e-mail liverpool@heyesarchitects.co.uk				HEYES + COMPANY