


Heron Eccles Playing Fields

Artificial Turf Pitches



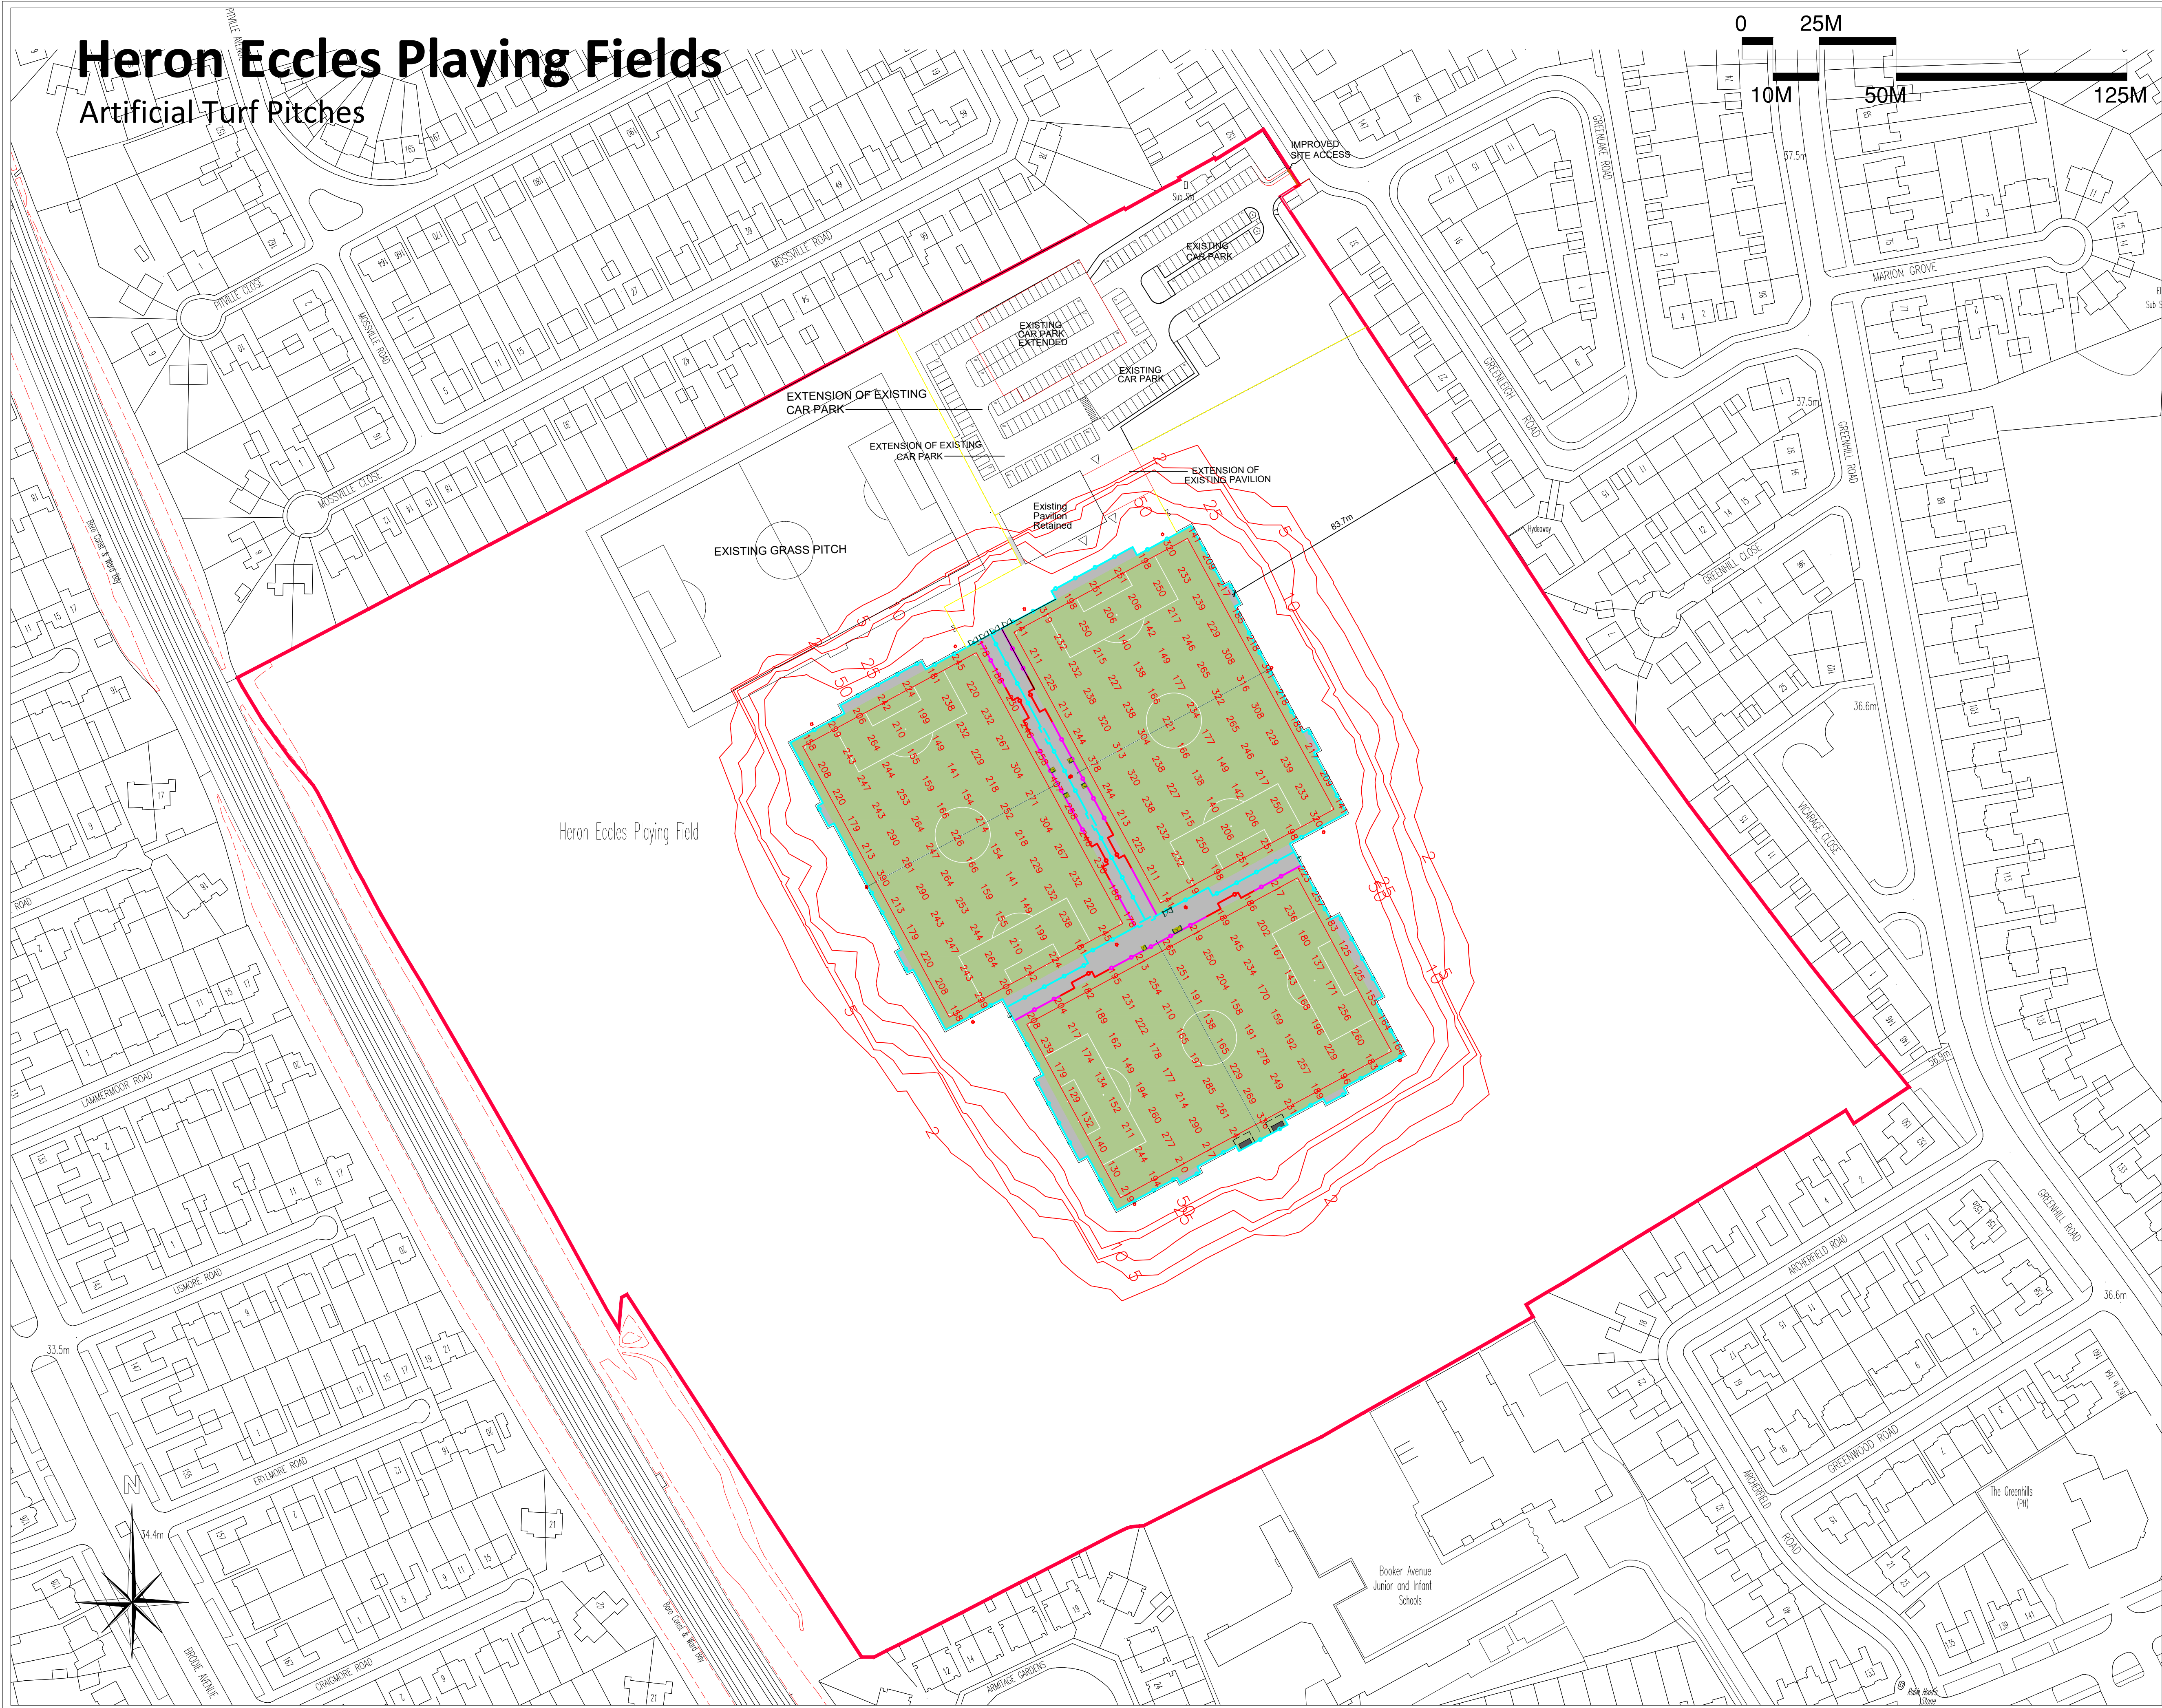

CONSULTANTS
Surfacing Standards Ltd
1st Floor, 100, North Street, Northampton, NN1 5JG
01603 400202

1 - DO NOT SCALE FROM DRAWING. ALL DIMENSIONS TO BE CHECKED ON SITE PRIOR TO COMMENCEMENT OF WORKS.
2 - THIS DRAWING IS COPYRIGHT TO SURFACING STANDARDS LTD
3 - ALL PERSONNEL SHOULD BE AWARE OF THE HEALTH AND SAFETY PLAN WHICH IS RETAINED IN THE SITE MANAGERS OFFICE

NOTES

00	PLANNING ISSUE	WB	10.06.16
REV	DESCRIPTION	BY	CHKI DATE



Surfacing Standards Limited
SPORTS PITCH CONSULTANTS

AUTHOR
Wesley Bugg

TITLE
Heron Eccles Playing Fields
Artificial Turf Pitches
Floodlighting Plan

PROJECT SS1989 HE	SCALE 1:1001	SIZE A1
DRAWING No. SSL1989 HE 01	REVISION 00	