 


Jericho Lane

Artificial Turf Pitches




SSL
Surfacing Standards Limited
Sports Pitch Consultants

CONSULTANTS
Surfacing Standards LTD
1st North House, Corby
Northants, NN17 5JG
01535 400202

1 - DO NOT SCALE FROM DRAWING. ALL DIMENSIONS TO BE CHECKED ON SITE PRIOR TO COMMENCEMENT OF WORKS.
2 - THIS DRAWING IS COPYRIGHT TO SURFACING STANDARDS LTD
3 - ALL PERSONNEL SHOULD BE AWARE OF THE HEALTH AND SAFETY PLAN WHICH IS RETAINED IN THE SITE MANAGERS OFFICE

NOTES

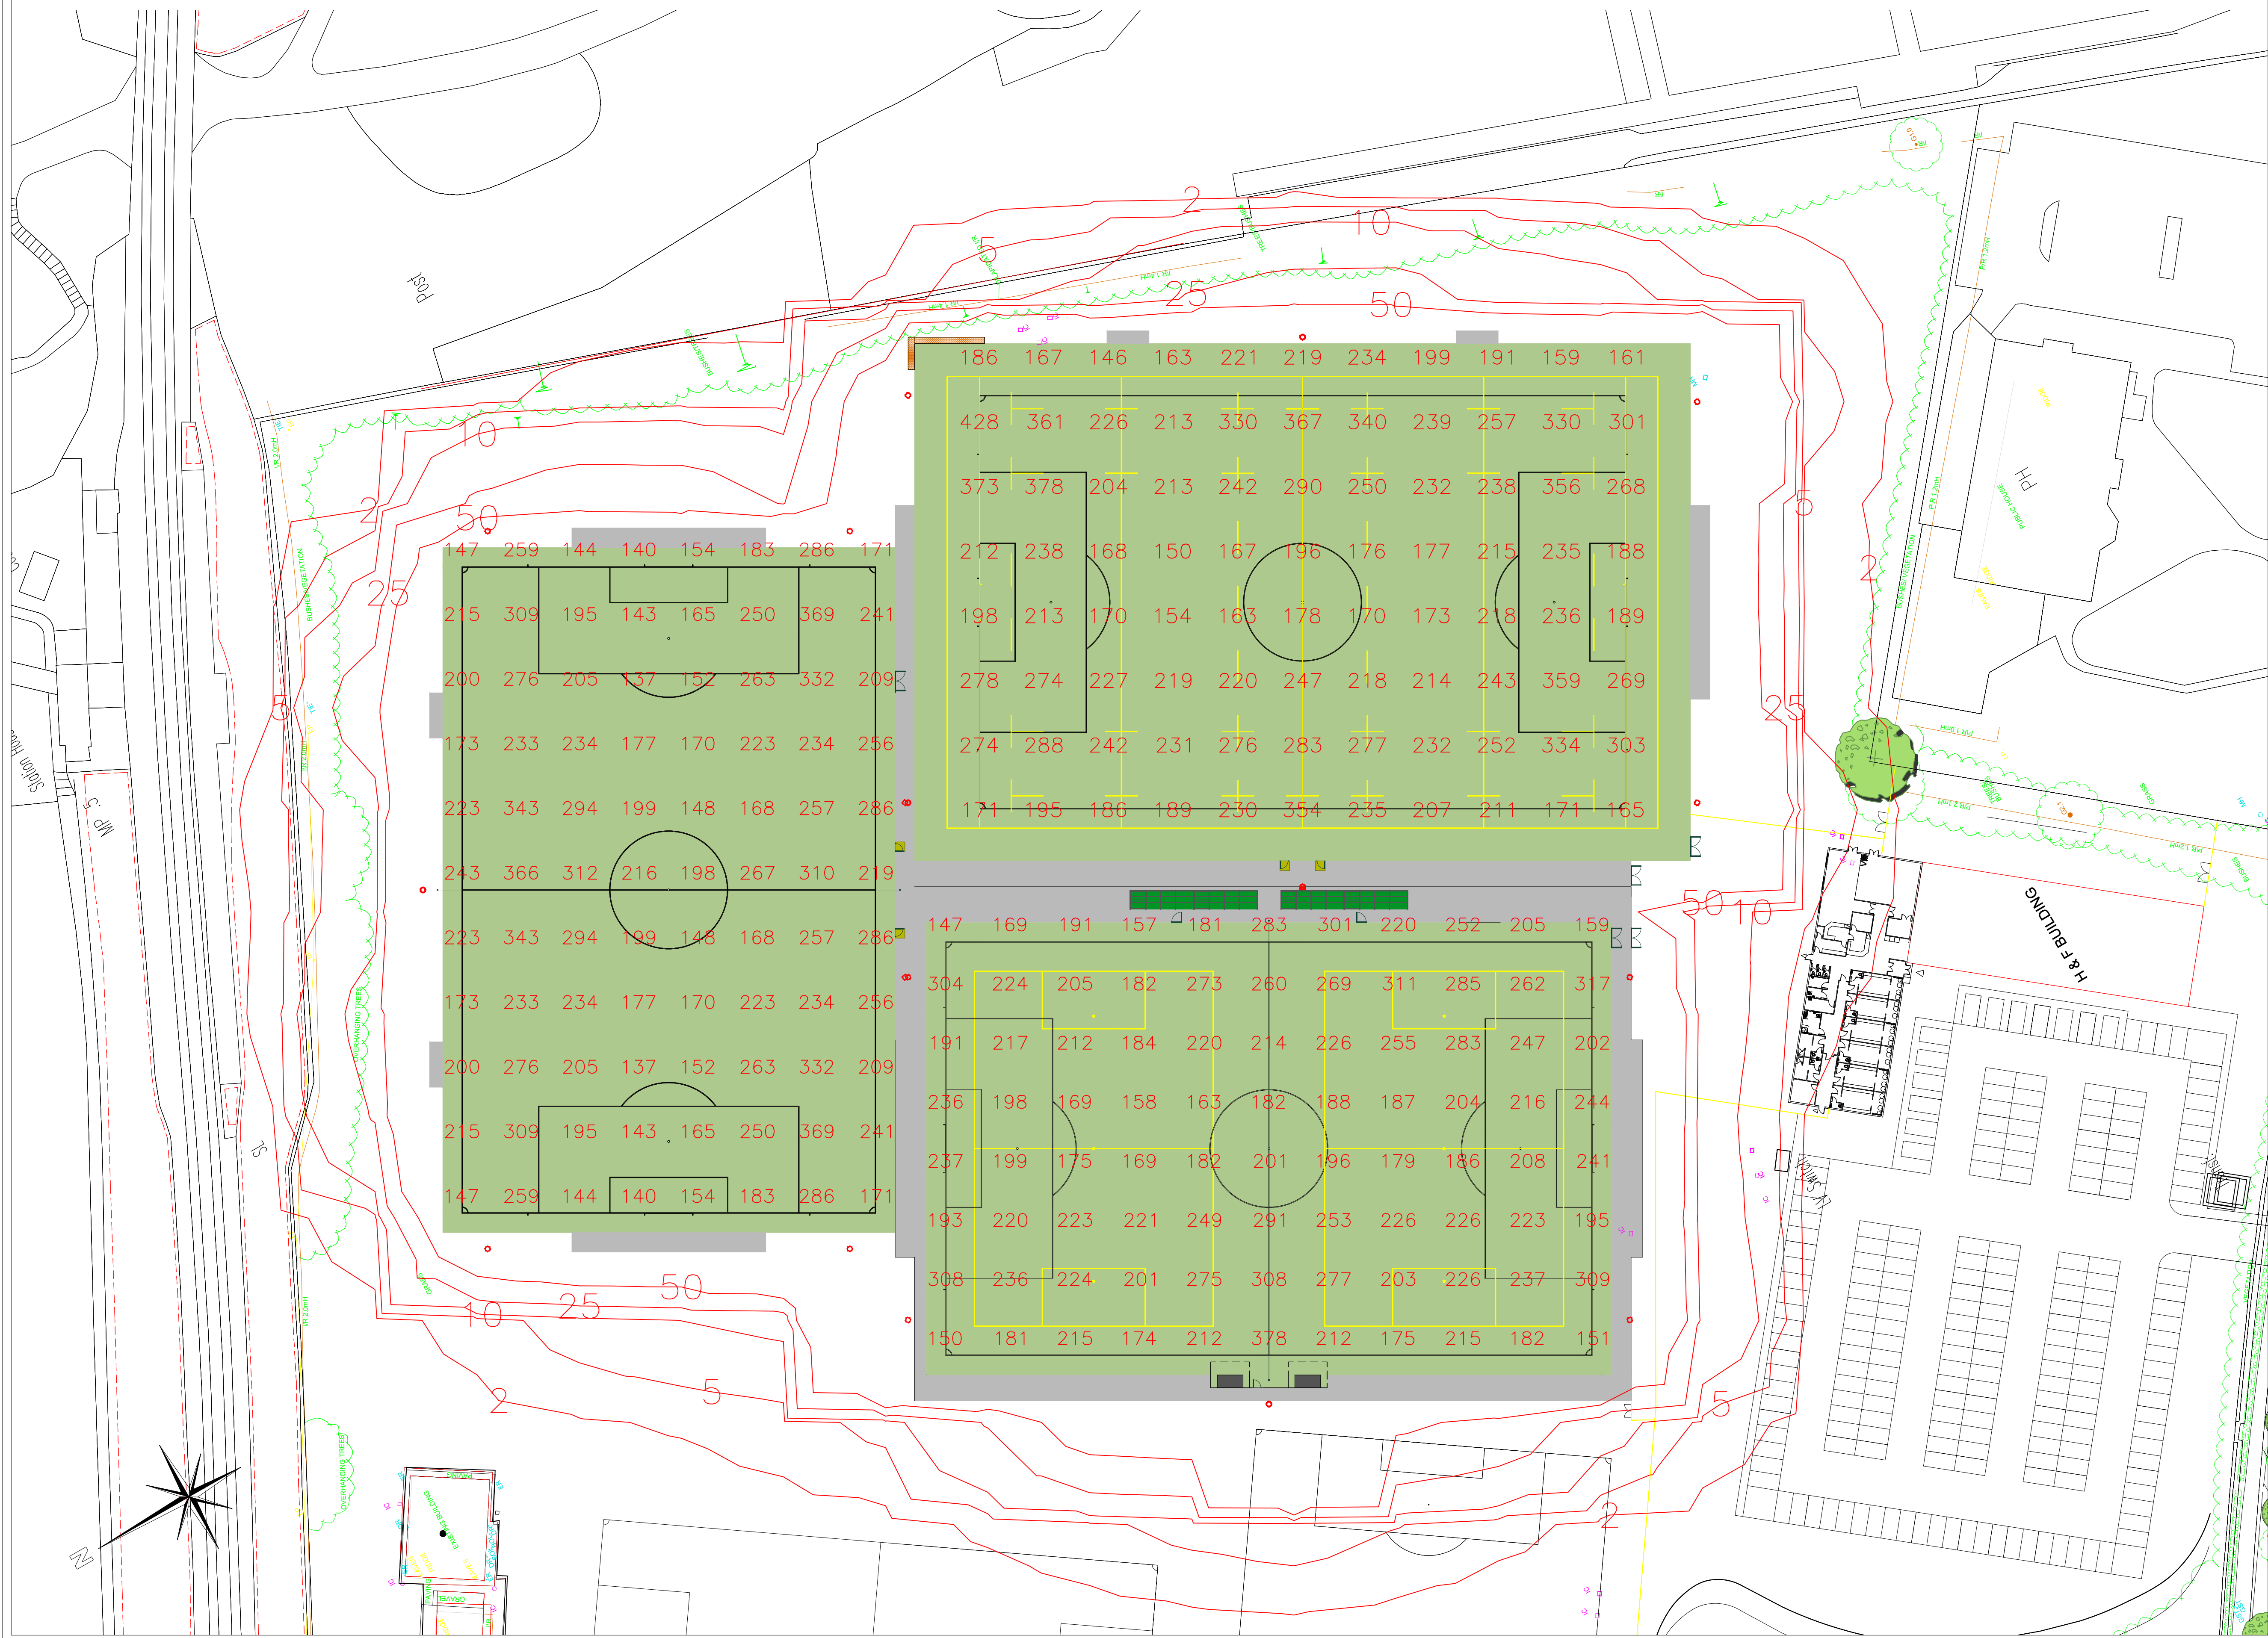

00	PLANNING ISSUE	WB	08.04.16
REV	DESCRIPTION	BY	CHKI DATE



AUTHOR Wesley Bugg			
TITLE Jericho Lane Artificial Turf Pitches ATP Floodlighting Plan			
PROJECT SS1989 JL	SCALE 1:500	SIZE A1	REVISION 00
DRAWING No SSL1989 JL 02			