
 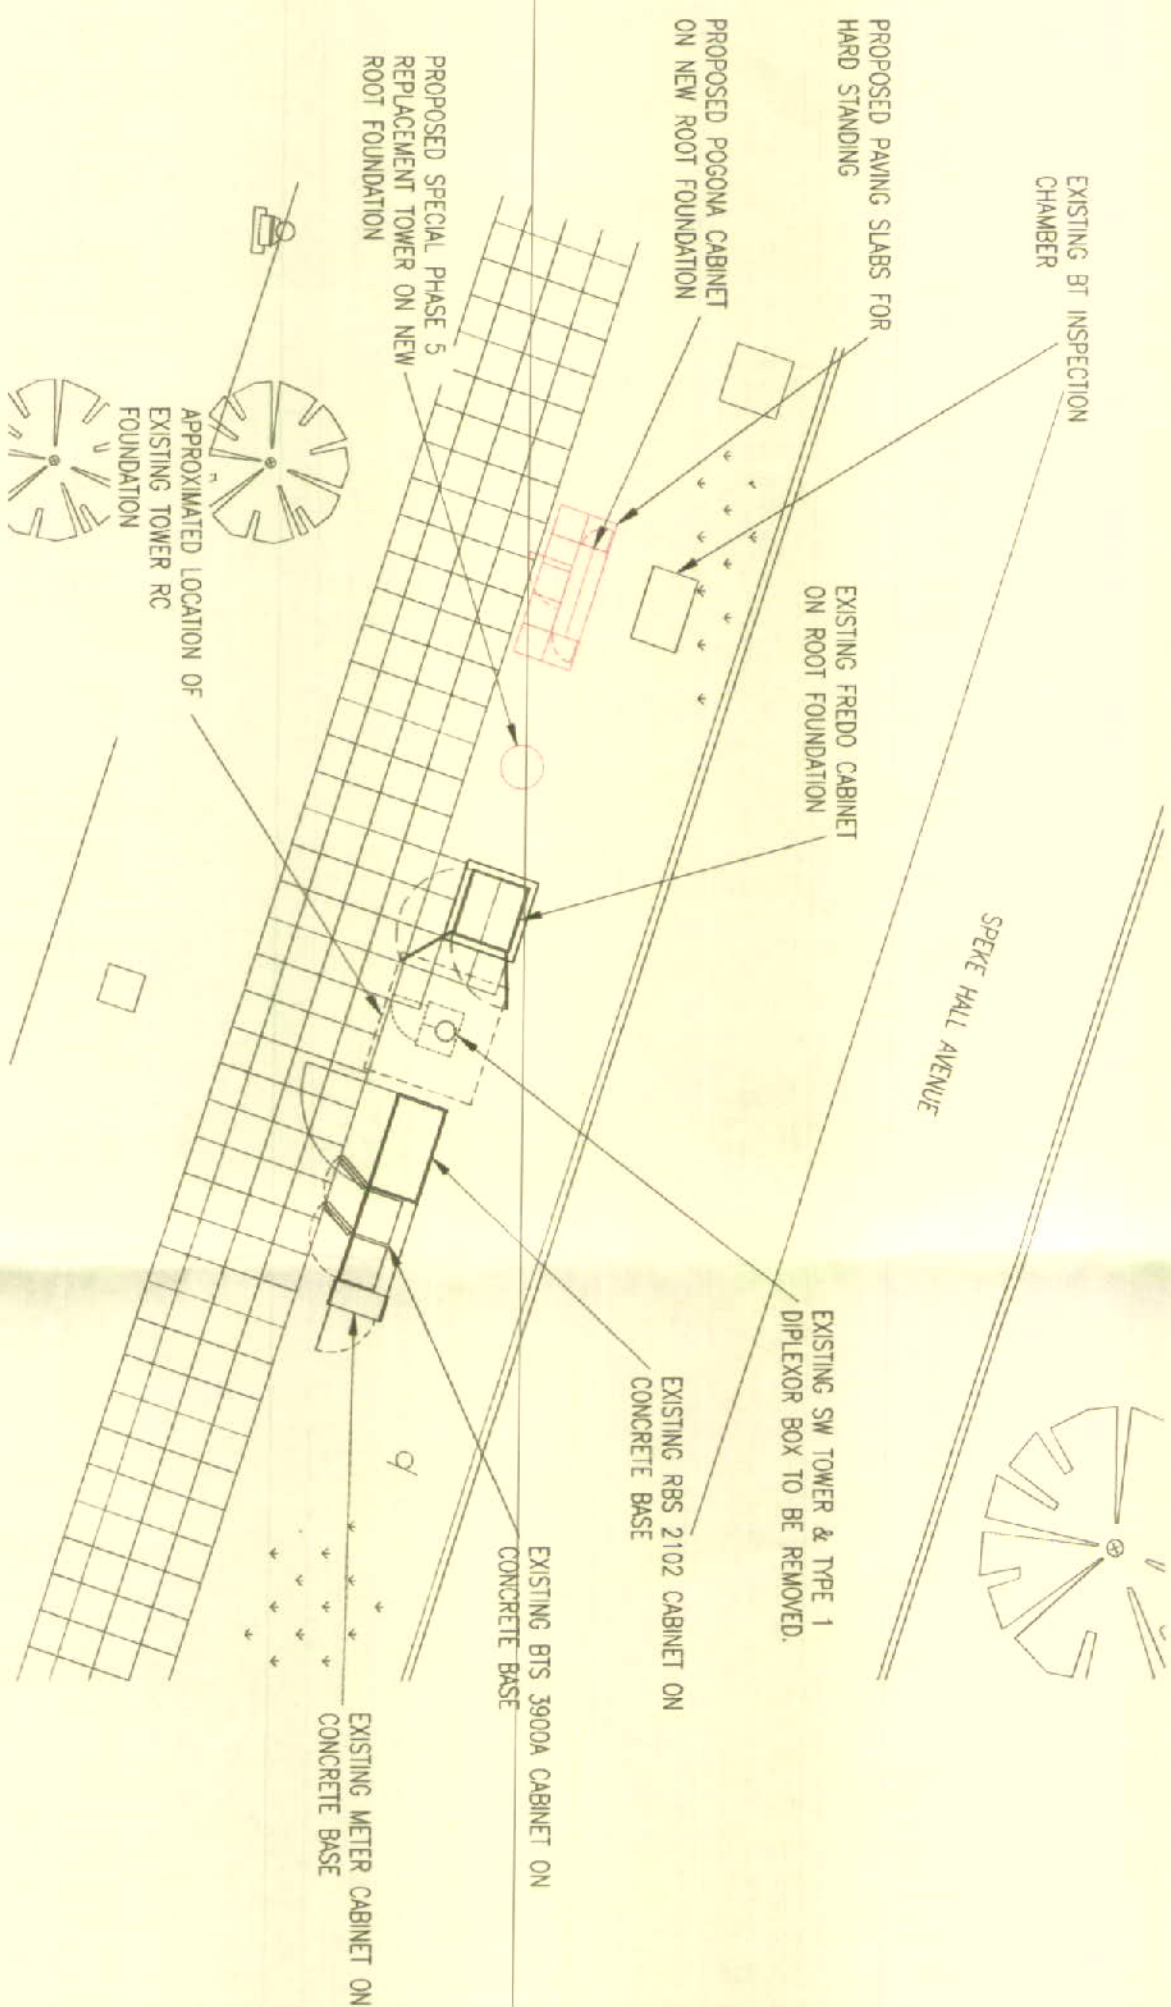




NOTE

1. STREETWORKS SAFETY SIGN ATTACHED TO TOWER 2000 BELOW ANTENNA ON ACCESS SIDE
2. ELECTRICAL SAFETY SIGN TO BE FITTED ON OUTSIDE OF METER CABINET DOOR (SECURE FLEX)
3. ENTRY SIGN TO BE FITTED ON INSIDE OF STREETWORKS CABINET DOORS
4. ANTENNA-1 SAFETY SIGN TO BE FITTED TO TOWER 200 BELOW EACH ANTENNA ON BORE SIGHT

SITE PLAN

SCALE 1:100

LOCATION OF PROPOSED SAMSUNG CABINET:-
DMS: 53.20:40.643N 2.51:55.088W

RD10091 (R1.0) CON. CONFIG. RD10009 (R1.0) CONFIG.
NON SIMILAR U-C2

ISPT/0685

19/3/15

No.	Revision	Date	By	chkd
A1	ISSUED FOR APPROVAL	25/02/15	ORG	AW

MBNL

6 Anglo Office Park
67 White Lion Road
Amersham
HP7 9FB
Tel: 01494 762 823
Email: info@mbnl.co.uk

WHP Wilkinson Helsby
Unit 17B, Asley Way Industrial Estate
Asley Lane, Swillington, Leeds
LS26 8XT
Tel: 0113 3023650 Fax: 0113 2876834
e-mail: info@whphelsby.co.uk

Site Name & Address:
LAMP 58 SPEKE HALL AVE,
SPEKE HALL AVENUE, SPEKE, LIVERPOOL,
MERSEYSIDE, L24 1UY

Title:
PROPOSED TELECOMMUNICATIONS
STREETWORKS UPGRADE
SITE LAYOUT

Purpose of Issue:
APPROVAL

Drawing No:
76135 - 02

Cell No:
76135
MBNL ID:
LPL065

Issue:	Scale:	AS STATED	Chk'd:	AW	Date:	25/02/15
A1	Org	25/02/15	App:	AW	Date:	25/02/15